


PROJECT

EAST END SUBSTATION  
RESTORATION & EXPANSION PROJECT, PHASE 2  
(13.2kV GIS) ST. THOMAS, USVI

DRAWING INDEX

DRAWINGS INCLUDED IN THIS PACKAGE						
DRAWING _	DRAWING NAME	ISSUE A: 07-25-19	ISSUE 0: 10-17-19	ISSUE 1: 12-03-19		
		PHASE 2 BID REVIEW	PHASE BID	PHASE BID		
STD-18257-E-100	SUBSTATION UNDERGROUND POWER DUCT BANK PLAN	•	•			
STD-18257-E-202	GIS BUILDING ELECTRICAL PLAN, SCHEDULES	•	•	•		
STD-18257-E-600	34.5/13.2KV SUBSTATION ONE LINE DIAGRAM	•	•			
STD-18257-E-603	RELAY PANEL ELEVATIONS RP1 THRU RP11, SCADA / COMMUNICATIONS PANEL		•			
STD-18257-E-605	13.2KV RELAY PANEL ELEVATIONS & BILL OF MATERIALS		•	•		
STD-18257-E-608	COMMUNICATIONS DIAGRAM	•	•			
STD-18257-E-700	AC ELEMENTARY DIAGRAM D-T1 LOW SIDE PROTECTION RELAY 13.2KV RP5	•	•			
STD-18257-E-701	DC ELEMENTARY DIAGRAM D-T1 LOW SIDE PROTECTION RELAY 13.2KV RP5	•	•			
STD-18257-E-702	AC ELEMENTARY DIAGRAM D-FRRID-F9 FEEDER PROTECTION RELAYS 13.2KV RP5	•	•			
STD-18257-E-703	DC ELEMENTARY DIAGRAM D-FRRID-F9 FEEDER PROTECTION RELAYS 13.2KV RP5	•	•			
STD-18257-E-704	AC ELEMENTARY DIAGRAM D-F7/SPARE FEEDER PROTECTION RELAYS 13.2KV RP6	•	•			
STD-18257-E-705	DC ELEMENTARY DIAGRAM D-F7/SPARE FEEDER PROTECTION RELAYS 13.2KV RP6	•	•			
STD-18257-E-706	AC ELEMENTARY DIAGRAM 13.2KV BUS DIFFERENTIAL PROTECTION (87B) 13.2KV RP6	•	•			
STD-18257-E-707	DC ELEMENTARY DIAGRAM 13.2KV BUS DIFFERENTIAL PROTECTION (87B) 13.2KV RP6	•	•			
STD-18257-E-708	DC ELEMENTARY DIAGRAM DPAC-2 RP6	•	•			
STD-18257-E-709	DC ELEMENTARY DIAGRAM DPAC-6 13.2KV GIS CUBICAL D-110	•	•			
STD-18257-E-710	RELAY PANEL 5 WIRING DIAGRAM	•	•			
STD-18257-E-711	RELAY PANEL 6 WIRING DIAGRAM	•	•			


LOCATION MAP

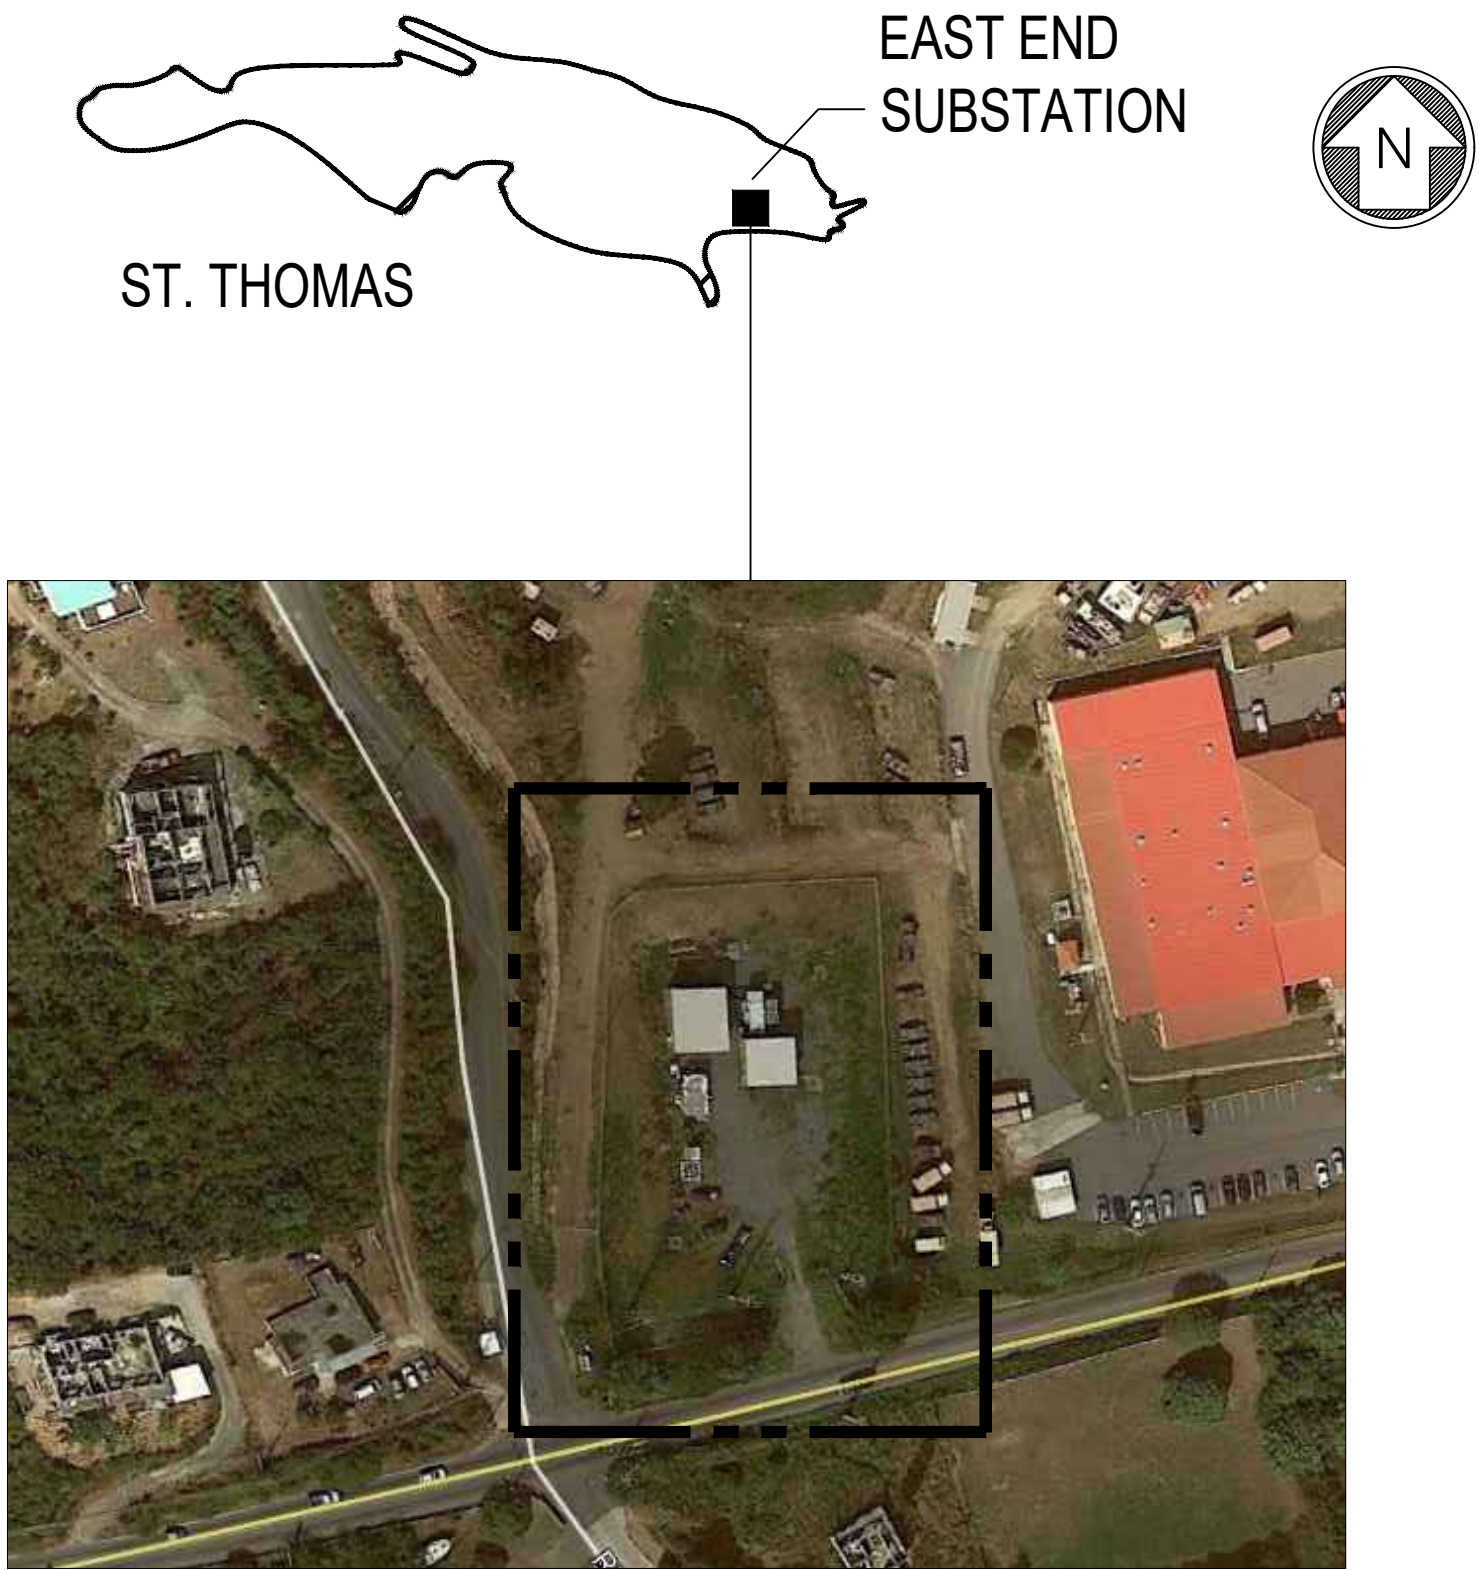

SCOPE OF WORK

- FURNISH & INSTALL A NEW 13.2KV GAS INSULATED SWITCHGEAR (GIS) CONSISTING OF AN INCOMING MAIN AND FOUR FEEDER BREAKERS.
- PROVIDE FACTORY ACCEPTANCE TESTING OF THE NEW 13.2KV GIS
- FURNISH & INSTALL EX-HAUST PLENUM THROUGH THE EXIST GIS BUILDING
- PROVIDE STARTUP, TESTING & COMMISSIONING OF THE NEW 13.2KV GIS
- FURNISH & INSTALL AN ELEVATED PLATFORM FOR THE NEW 13.2KV GIS. THE PLATFORM SHALL BE SIMILAR TO THE 34.5KV GIS PLATFORM THAT IS BEING CONSTRUCTED UNDER PHASE 1. THE PLATFORM SHALL BE A "DELEGATED DESIGN". THE GIS PLATFORM SHALL BE DESIGNED BY A LICENSED PROFESSIONAL STRUCTURAL ENGINEER RETAINED BY THE GIS VENDOR. THE GIS VENDOR SHALL SHALL PROVIDE SIGNED& SEALED SHOP DRAWINGS FOR REVIEW & APPROVAL
- FURNISH & INSTALL 15KV CABLES AS FOLLOWS:
  - 3 SETS EACH OF 3 -1/C #750 KCMIL, 15KV CABLE, IN 3 EX ISTING 6" PVC/RGS CONDUITS FROM EXISTING POWER TRANSFORMER T-D1 TO INCOMING MAIN BREAKER D-110
  - 1 SET OF 3 - 1/C #750 KCMIL, 15KV CABLE, IN 1 - EXISTING 6" PVC CONDUIT FROM FEEDER BREAKER D-RR TO THE EXISTING RIDGE ROAD RISER POLE LOCATED ACROSS THE STREET. CONDUIT RISER ON POLE SHALL BE NEW.
  - 1 SET OF 3 - 1/C #750 KCMIL, 15KV CABLE, IN 1 - EXISTING 6" PVC CONDUIT FROM FEEDER BREAKER D-F9 TO THE EXISTING FEEDER 90 RISER POLE LOCATED INSIDE THE SUBSTATION FENCED AREA. CONDUIT RISER ON POLE SHALL BE NEW.
  - 1 SET OF 3 - 1/C #750 KCMIL, 15KV CABLE, IN 1 - EXISTING 6" PVC CONDUIT FROM FEEDER BREAKER D-F7 TO THE EXISTING FEEDER 70 RISER POLE LOCATED NEAR MANHOLE #4A. CONDUIT RISER ON POLE SHALL BE NEW.
- TEST 15KV CABLES
- FURNISH & INSTALL TWO 13.2KV RELAY PANELS (RPS AND RP6) TO BE LOCATED IN THE EXISTING NEWLY CONSTRUCTED CONTROL BUILDING. BOLT RELAY PANELS TO THE FLOOR SLAB.
- FURNISH & INSTALL RELAYS, METERS, LOCKOUTS, REMOTE BREAKER CONTROL SWITCHES, DPAC, TEST SWITCHES, TEST BL OCKS, FUSES, TERMINAL BLOCKS, ETC.
- FURNISH & INSTALL ALL PROTECTION & SCADA CABLES IN EXISTING RACEWAYS BETWEEN THE EXISTING GIS BUILDING AND THE CONTROL BUILDING AND IN THE EXISTING CABLE TRAY WITHIN THE CONTROL BUILDING
- PROVIDE TESTING & COMMISSIONING OF THE NEW 13.2KV RELAYS & METERS
- FURNISH & INSTALL 120 VOLT AC POWER IN EXISTING RACEWAYS TO THE GIS AND THE TWO RELAY PANELS
- FURNISH & INSTALL LIGHTS UNDER THE 13.2KV GIS PLATFORM

ENGINEER:

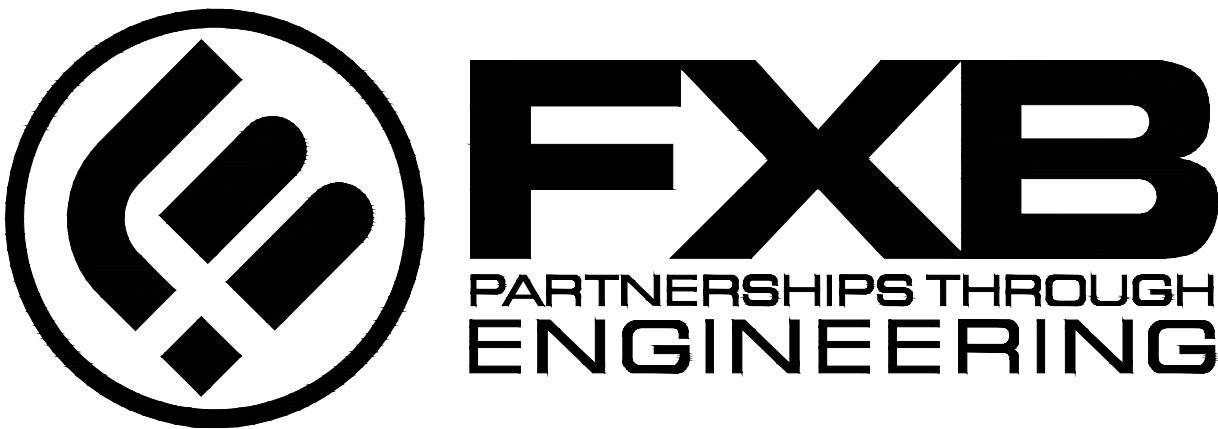


5 Christy Drive, Suite 307  
Chadds Ford, PA 19317  
610.558.3464 office  
www.fxbinco.com


Engineering Excellence Since 1968

OWNER:

 Virgin Islands Water &  
Power Authority St. Thomas  
U.S. Virgin Islands

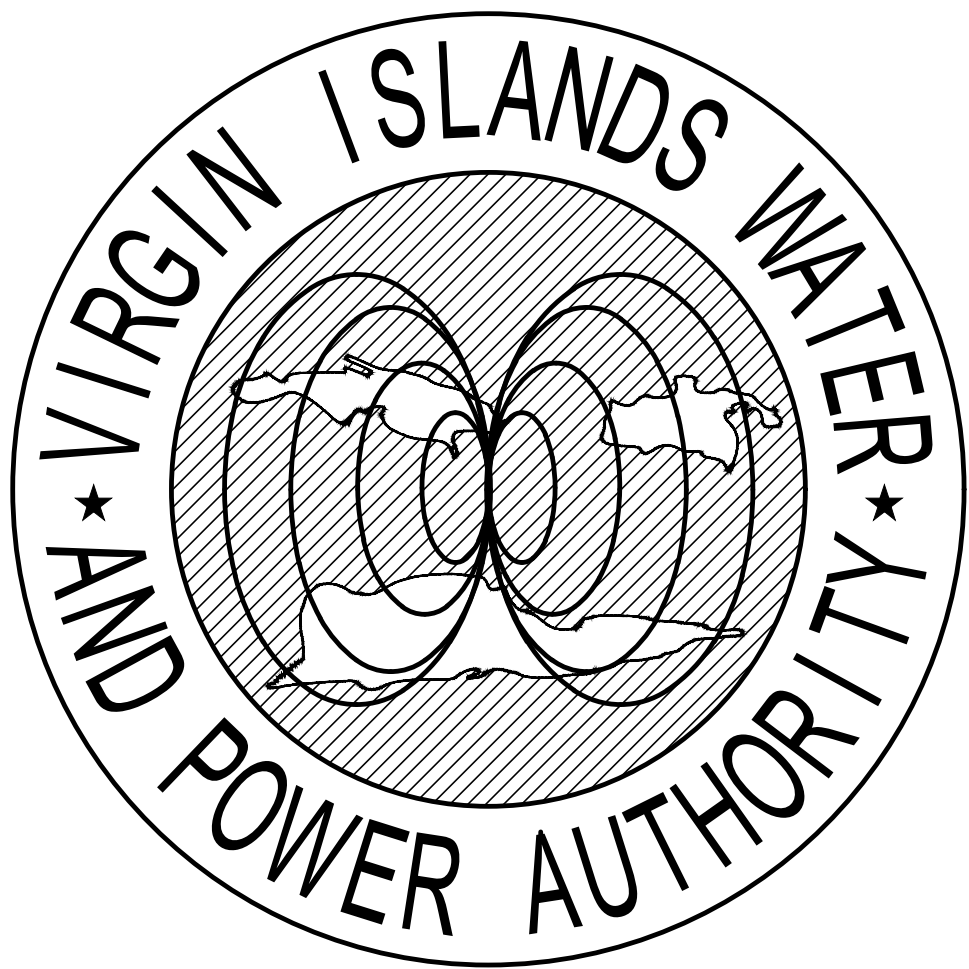






## SUBSTATION UNDERGROUND DUCT BANK PLAN

SCALE: 1" = 10'-0"

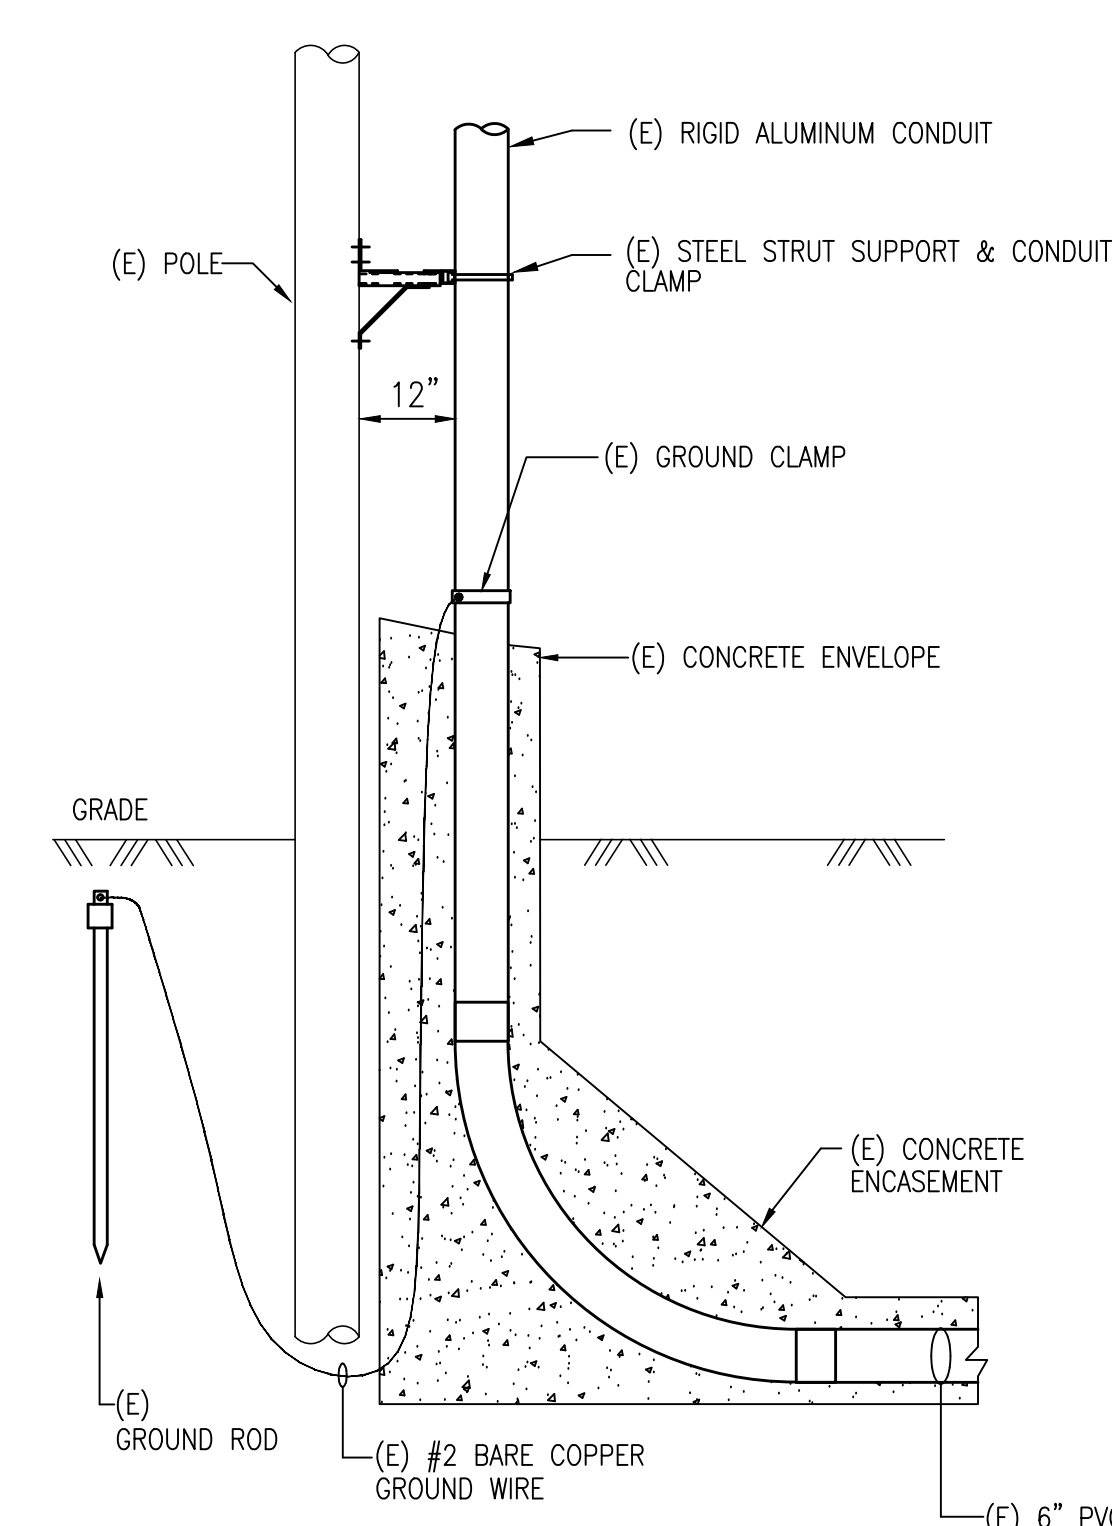

FEEDER RR,7D,9D RISER  
POLE BASE DETAIL  
NOT TO SCALE

NOTE: RISER CONDUITS ARE EXISTING. CONTRACTOR SHALL PULL NEW CABLES AND TERMINATE AT RISER POLE IN ACCORDANCE WITH VIWAPA STANDARDS. COORDINATE WITH VIWAPA, "MOP REQUIRED."

5 Christy Drive, Suite 307  
Chadds Ford, PA 19317  
610.558.3464 office  
www.fxbinco.com

Engineering Excellence Since 1958

Engineers Seal

Client



Virgin Islands  
Water and Power  
Authority  
U.S. Virgin Islands

Project Name:

East End Substation  
Restoration &  
Expansion Project  
St. Thomas, USVI  
Phase 2

[illegible]

Drawn By:	P.
Chkd By:	P.
Date:	10.17.
Scale:	As Noted
Project Number:	VIT 182

Drawing Title:


SUBSTATION  
UNDERGROUND  
POWER DUCT BANK  
PLAN

Drawing Number

STD-18257-E-100

Engineers Seal

Client:

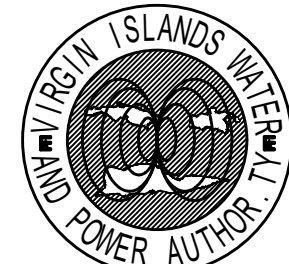

*Virgin Islands*  
**Water and Power**  
*Authority*  
**U.S. Virgin Islands**

Project Name:

East End Substation  
Restoration &  
Expansion Project  
St. Thomas, USVI  
Phase 2

Issue / Revision:

#	Date	Description
A	07.25.19	Issue for Phase 2 Bid Review
0	10.17.19	Issue for Phase 2 Bid
1	12.03.19	Issue for Phase 2 Bid


Drawn By: PJB  
Checked By: PJB  
Date: 12.03.19  
Scale: As Noted  
Project Number: VIT 18257  
Drawing Title:

GIS BUILDING ELECTRICAL  
PLAN & SCHEDULES

Drawing Number:

STD-18257-E-202


© 2018 FXB, Inc.

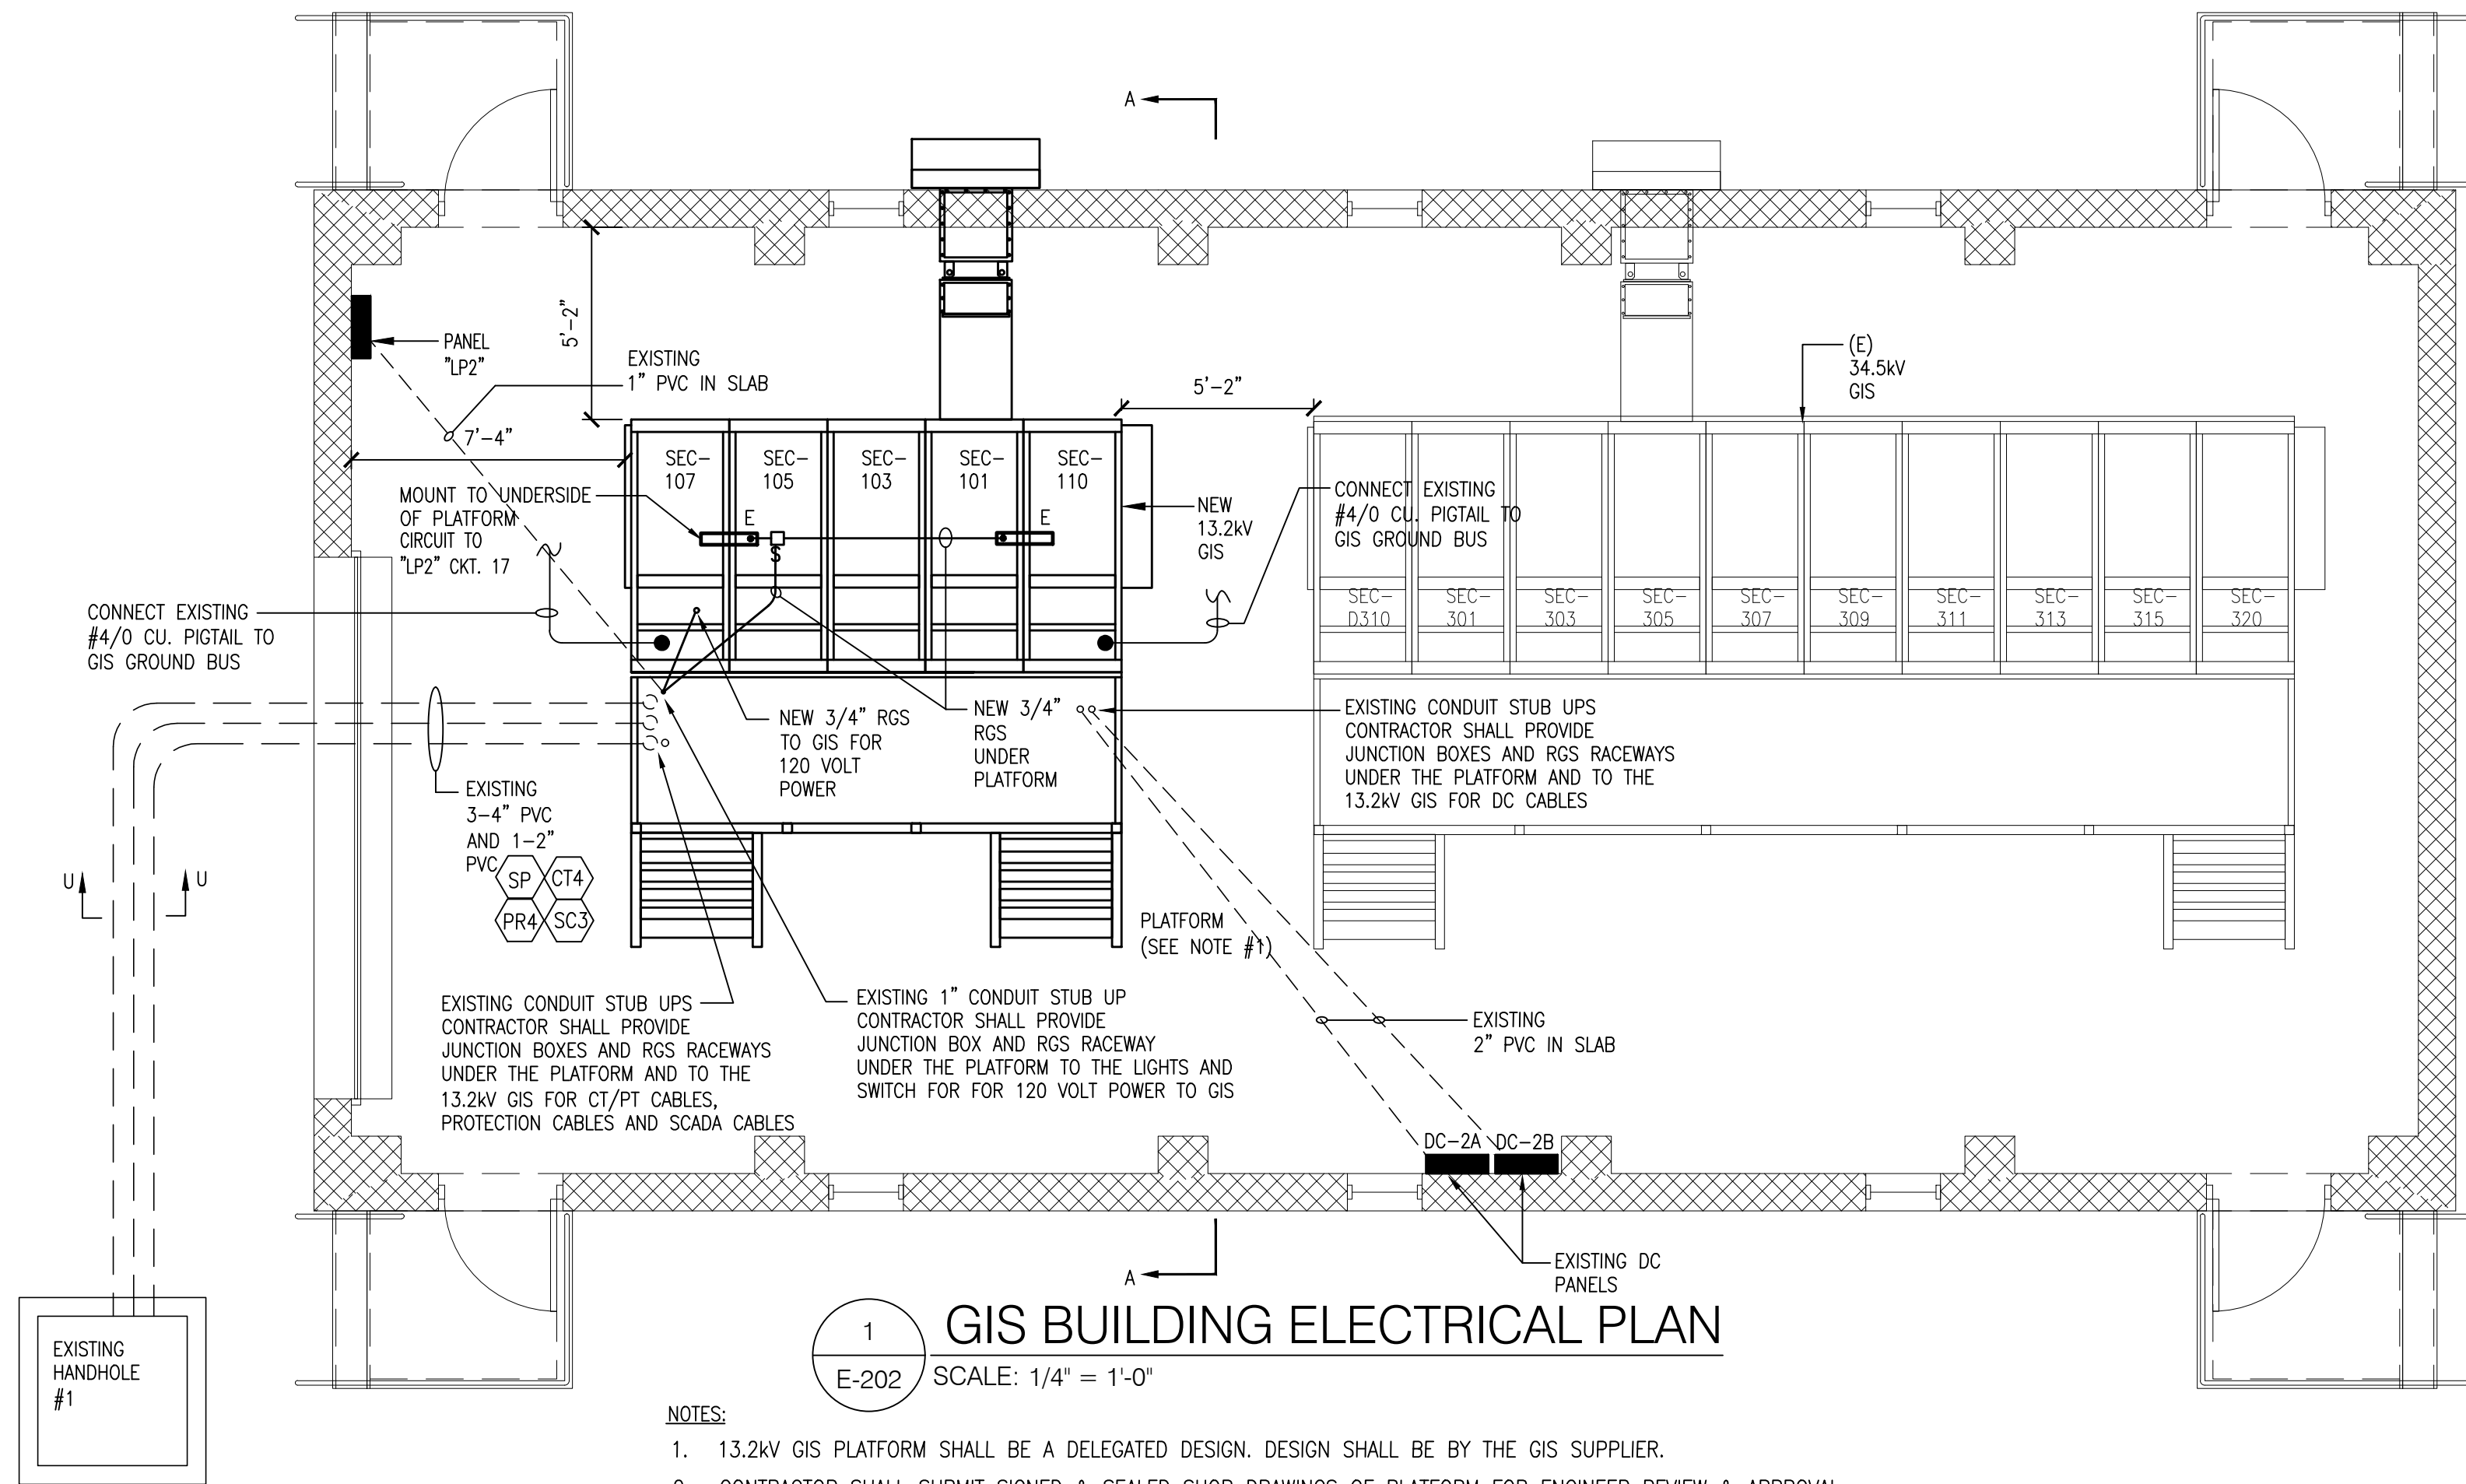

NOTES:

- 13.2kV GIS PLATFORM SHALL BE A DELEGATED DESIGN. DESIGN SHALL BE BY THE GIS SUPPLIER.
- CONTRACTOR SHALL SUBMIT SIGNED & SEALED SHOP DRAWINGS OF PLATFORM FOR ENGINEER REVIEW & APPROVAL.
- FURNISH & INSTALL ONE (1) SEL 2440 DPAC IN SECTION 110 FOR SCADA WIRING
- FOR EACH BREAKER, MONITOR THE FOLLOWING POINTS VIA THE SEL 2440 DPAC:

TRIP COIL MONITOR 1  
TRIP COIL MONITOR 2  
43 LOCAL/SUPERVISORY SWITCH STATUS  
SF6 GAS ALARM

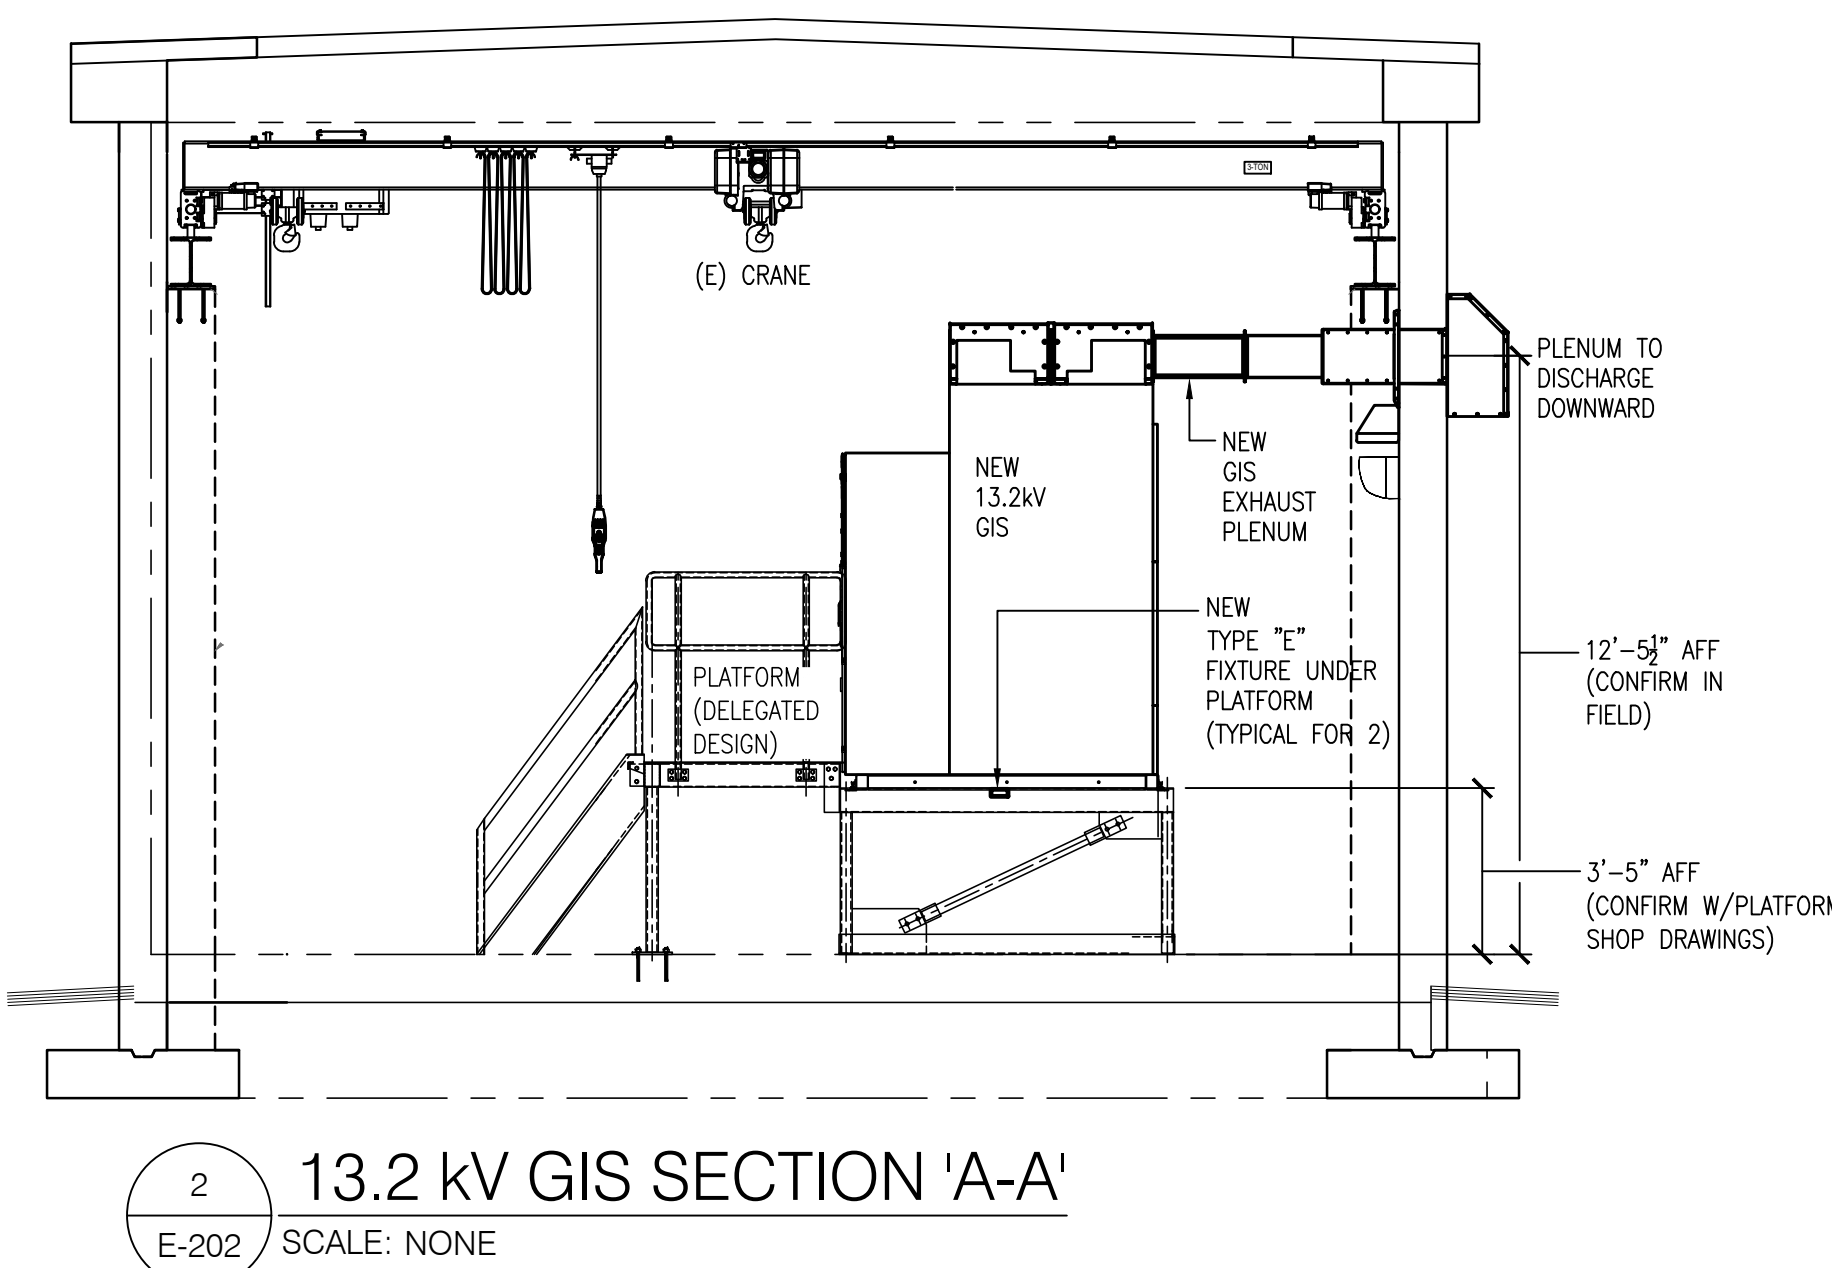

2 13.2 kV GIS SECTION 'A-A'  
E-202 SCALE: NONE

### MEDIUM VOLTAGE TERMINATION SCHEDULE

ITEM	QUANTITY	DESCRIPTION	DESCRIPTION	INSTALLED BY	FURNISHED BY
①	9	15kV CABLE TERMINATION KIT, CABLE SIZE #750 KCMIL CU., 133% EPR INSULATION, 1/3 CONCENTRIC NEUTRAL CABLE (SEE APPROVED CABLE DATA SHEET), WITH MOUNTING BRACKET	TERMINATION AT POWER TRANSFORMER D-T1 13.2kV AIR TERMINAL CHAMBER	E.C.	E.C.
②	9	15kV CABLE TERMINATION KIT, CABLE SIZE #750 KCMIL CU., 133% EPR INSULATION, 1/3 CONCENTRIC NEUTRAL CABLE (SEE APPROVED CABLE DATA SHEET), WITH MOUNTING BRACKET	TERMINATION AT RISER POLES	E.C.	E.C.
③	21	SEPARABLE CONNECTOR FOR TERMINATION IN 13.2kV GIS	TERMINATIONS @ GIS	E.C.	GIS MANUFACTURER
④	9	CABLE FAULT INDICATOR, SELF POWERED, LOCAL LED INDICATION WITH AUTOMATIC RESET,	FAULT INDICATOR	E.C.	E.C.

NOTE: EQUIPMENT SHALL BE AS SPECIFIED ABOVE OR APPROVED EQUAL.

### MEDIUM VOLTAGE RACEWAY SCHEDULE

MEDIUM VOLTAGE RACEWAY SCHEDULE													
TAG	FROM	TO	CABLES / CONDUCTORS PER CONDUIT						CONDUIT			PURPOSE	
			VOLTAGE	PHASE	NEUTRAL	GROUND	INSULATION	TEMP/ RATING	QUANTITY	SIZE	TYPE		
①	TRANSFORMER D-T1	13.2kV BREAKER D-110	15kV	3-1/C	#750 KCMIL CU.	1/3 CONCENTRIC	N/A	133% EPR	MV105	3	6"	(E) SCHEDULE 40 PVC	13.2kV GIS FEEDER
②	13.2kV BREAKER D-101	13.2kV RISER POLE FOR RIDGE ROAD	15kV	3-1/C	#750 KCMIL CU.	1/3 CONCENTRIC	N/A	133% EPR	MV105	1	6"	(E) SCHEDULE 40 PVC	FEEDER RIDGE ROAD
③	13.2kV BREAKER D-103	13.2kV RISER POLE FOR FEEDER 9D	15kV	3-1/C	#750 KCMIL CU.	1/3 CONCENTRIC	N/A	133% EPR	MV105	1	6"	(E) SCHEDULE 40 PVC	FEEDER 9D
④	13.2kV BREAKER D-105	13.2kV RISER POLE FOR FEEDER 7D	15kV	3-1/C	#750 KCMIL CU.	1/3 CONCENTRIC	N/A	133% EPR	MV105	1	6"	(E) SCHEDULE 40 PVC	FEEDER 7D

NOTE: MEDIUM VOLTAGE CABLE IS SUPPLIED BY VIMPA & RECEIVED, TESTED AND INSTALLED BY CONTRACTOR

### PROTECTION & CONTROL RACEWAY SCHEDULE

TAG	FROM	TO	CONDUCTOR IDENTIFICATION PER CONDUIT	CONDUIT			PURPOSE
				QUANTITY	SIZE	TYPE	
PR4	CONTROL BUILDING EXTERIOR PULL BOX	GIS BUILDING (13.2kV GIS)	SEE CABLE SCHEDULE	1	4"	PVC	PROTECTION
CT4	CONTROL BUILDING EXTERIOR PULL BOX	GIS BUILDING (13.2kV GIS)	SEE CABLE SCHEDULE	1	4"	PVC	PROTECTION CT'S
SC3	CONTROL BUILDING EXTERIOR PULL BOX	GIS BUILDING (13.2kV GIS)	SEE CABLE SCHEDULE	1	2"	PVC	SCADA CABLES TO 13.2kV GIS

NOTE: CONDUITS ARE EXISTING TO REMAIN.

### LIGHTING FIXTURE SCHEDULE

TYPE	LAMPS		MOUNTING	VOLTAGE	DESCRIPTION
	NO.	WATTS			
E	1	19	LED	120	2'-0" LED STRIP LIGHT MOUNTED TO UNDERSIDE OF GIS PLATFORM

(E) PANEL SCHEDULE "DC-1A" VOLTS: RATED @ 250 VDC LOCATION: CONTROL BUILDING SHORT CIRCUIT RATING: 10 KAIC MIN.  
AMPS: 100A MLO MOUNTING: SURFACE

CIR. NO.	DESCRIPTION	WIRE SIZE	FUSE AMPS	POLES	FUSE AMPS	POLES	WIRE SIZE	DESCRIPTION	CIR. NO.
1	87L/L3-OB00 POWER SUPPLY (RELAY PANEL 7)	#12	20	2	20	2	#12	DPAC-1 POWER SUPPLY (RELAY PANEL 1)	2
3	87L/L3-OC00 POWER SUPPLY (RELAY PANEL 7)	#12	20	2	20	2	#12	DPAC-2 POWER SUPPLY (RELAY PANEL 6)	4
5	87L/L3-OD0E1 POWER SUPPLY (RELAY PANEL 8)	#12	20	2	20	2	#12	87B 34.5kV BUS 1/2 POWER SUPPLY (RELAY PANEL 9)	6
7	87L/L3-OD0E2 POWER SUPPLY (RELAY PANEL 8)	#12	20	2	20	2	#12	67 LS/D-T2 & METER POWER SUPPLY (RELAY PANEL 10)	8
9	67 LS / D-T1 & METER D-110 POWER SUPPLY (RELAY PANEL 5)	#12	20	2	20	2	#12	87T/D-T1 & 86T POWER SUPPLY (RELAY PANEL 11)	10
11	67/D-FRR & METER D-101 POWER SUPPLY (RELAY PANEL 5)	#12	20	2	20	2	#12	67/D-F9 & METER D-103 POWER SUPPLY (RELAY PANEL 5)	12
13	67/SPARE & METER D-107 POWER SUPPLY (RELAY PANEL 6)	#12	20	2	20	2	#12	67/D-F7 & METER D-105 POWER SUPPLY (RELAY PANEL 6)	14
15	SCADA EQUIPMENT POWER SUPPLY	#12	20	2	20	2	#12	87B & 86B (13.2KV) POWER SUPPLY (RELAY PANEL 6)	16
17	SPARE		20	2	20	2		SPARE	18
19	SPARE		20	2	20	2		SPARE	20
21	SPARE		20	2	20	2		SPARE	22
23	SPARE		20	2	20	2		SPARE	24
25	SPARE		20	2	20	2		SPARE	26
27	SPARE		20	2	20	2		SPARE	28
29	SPARE		20	2	20	2		SPARE	30

NOTE: PANEL AND ALL CIRCUIT BREAKERS ARE EXISTING TO REMAIN.

(E) PANEL SCHEDULE "DC-2A" VOLTS: RATED @ 250 VDC LOCATION: GIS BUILDING SHORT CIRCUIT RATING: 10 KAIC MIN.  
AMPS: 100A MCB MOUNTING: SURFACE

CIR. NO.	DESCRIPTION	WIRE SIZE	FUSE AMPS	POLES	FUSE AMPS	POLES	WIRE SIZE	DESCRIPTION	CIR. NO.
1	BREAKER D-110 TC1 & CLOSE COIL	#12	20	2	20	2	#12	BREAKER D-310 TC1 & CLOSE COIL	2
3	BREAKER D-101 TC1 & CLOSE COIL	#12	20	2	20	2	#12	BREAKER D-301 TC1 & CLOSE COIL	4
5	BREAKER D-103 TC1 & CLOSE COIL	#12	20	2	20	2	#12	BREAKER D-303 TC1 & CLOSE COIL	6
7	BREAKER D-105 TC1 & CLOSE COIL	#12	20	2	20	2	#12	BREAKER D-305 TC1 & CLOSE COIL	8
9	BREAKER D-107 TC1 & CLOSE COIL	#12	20	2	20	2	#12	BREAKER D-307 TC1 & CLOSE COIL	10
11	DPAC-4 POWER SUPPLY (34.5kV GIS)	#12	20	2	20	2	#12	BREAKER D-309 TC1 & CLOSE COIL	12
13	DPAC-6 POWER SUPPLY (13.5kV GIS)	#12	20	2	20	2	#12	BREAKER D-311 TC1 & CLOSE COIL	14
15	SPARE		20	2	20	2	#12	BREAKER D-313 TC1 & CLOSE COIL	16
17	SPARE		20	2	20	2	#12	BREAKER D-315 TC1 & CLOSE COIL	18
19	MAIN		100	2	20	2	#12	BREAKER D-320 TC1 & CLOSE COIL	20

NOTE: PANEL AND ALL CIRCUIT BREAKERS ARE EXISTING TO REMAIN.

(E) PANEL SCHEDULE "DC-2B" VOLTS: RATED @ 250 VDC LOCATION: GIS BUILDING SHORT CIRCUIT RATING: 10 KAIC MIN.  
AMPS: 100A MCB MOUNTING: SURFACE

CIR. NO.	DESCRIPTION	WIRE SIZE	FUSE AMPS	POLES	FUSE AMPS	POLES	WIRE SIZE	DESCRIPTION	CIR. NO.
1	BREAKER D-110 TC2	#12	20	2	20	2	#12	BREAKER D-310 TC2	2
3	BREAKER D-101 TC2	#12	20	2	20	2	#12	BREAKER D-301 TC2	4
5	BREAKER D-103 TC2	#12	20	2	20	2	#12	BREAKER D-303 TC2	6
7	BREAKER D-105 TC2	#12	20	2	20	2	#12	BREAKER D-305 TC2	8
9	BREAKER D-107 TC2	#12	20	2	20	2	#12	BREAKER D-307 TC2	10
11	DPAC-5 POWER SUPPLY (34.5kV GIS)	#12	20	2	20	2	#12	BREAKER D-309 TC2	12
13	SPARE	#12	20	2	20	2	#12	BREAKER D-311 TC2	14
15	SPARE		20	2	20	2	#12	BREAKER D-313 TC2	16
17	SPARE		20	2	20	2	#12	BREAKER D-315 TC2	18
19	MAIN		100	2	20	2	#12	BREAKER D-320 TC2	20

NOTE: PANEL AND ALL CIRCUIT BREAKERS ARE EXISTING TO REMAIN.



Engineers Seal

Client:



**Virgin Islands  
Water and Power  
Authority  
U.S. Virgin Islands**

Project Name:

**East End Substation  
Restoration &  
Expansion Project  
St. Thomas, USVI  
Phase 1 and 2**

Issue / Revision:

#	Date	Description
A	05.31.19	Issue for VMAPA Review
B	08.08.19	Issue for final review of 13.2kV GIS
C	08.19.19	Revised per 08/19/19 meeting
D	10.17.19	Issue for Phase 2 Bid

Drawn By:

PJB

Checked By:

PJB

Date:

08.19.19

Scale:

As Noted

Project Number:

VIT 18257


Drawing Title:

**34.5/13.2kV  
SUBSTATION  
ONE LINE DIAGRAM**

Drawing Number:

**STD-18257-E-600**


© 2018 FXB, Inc.

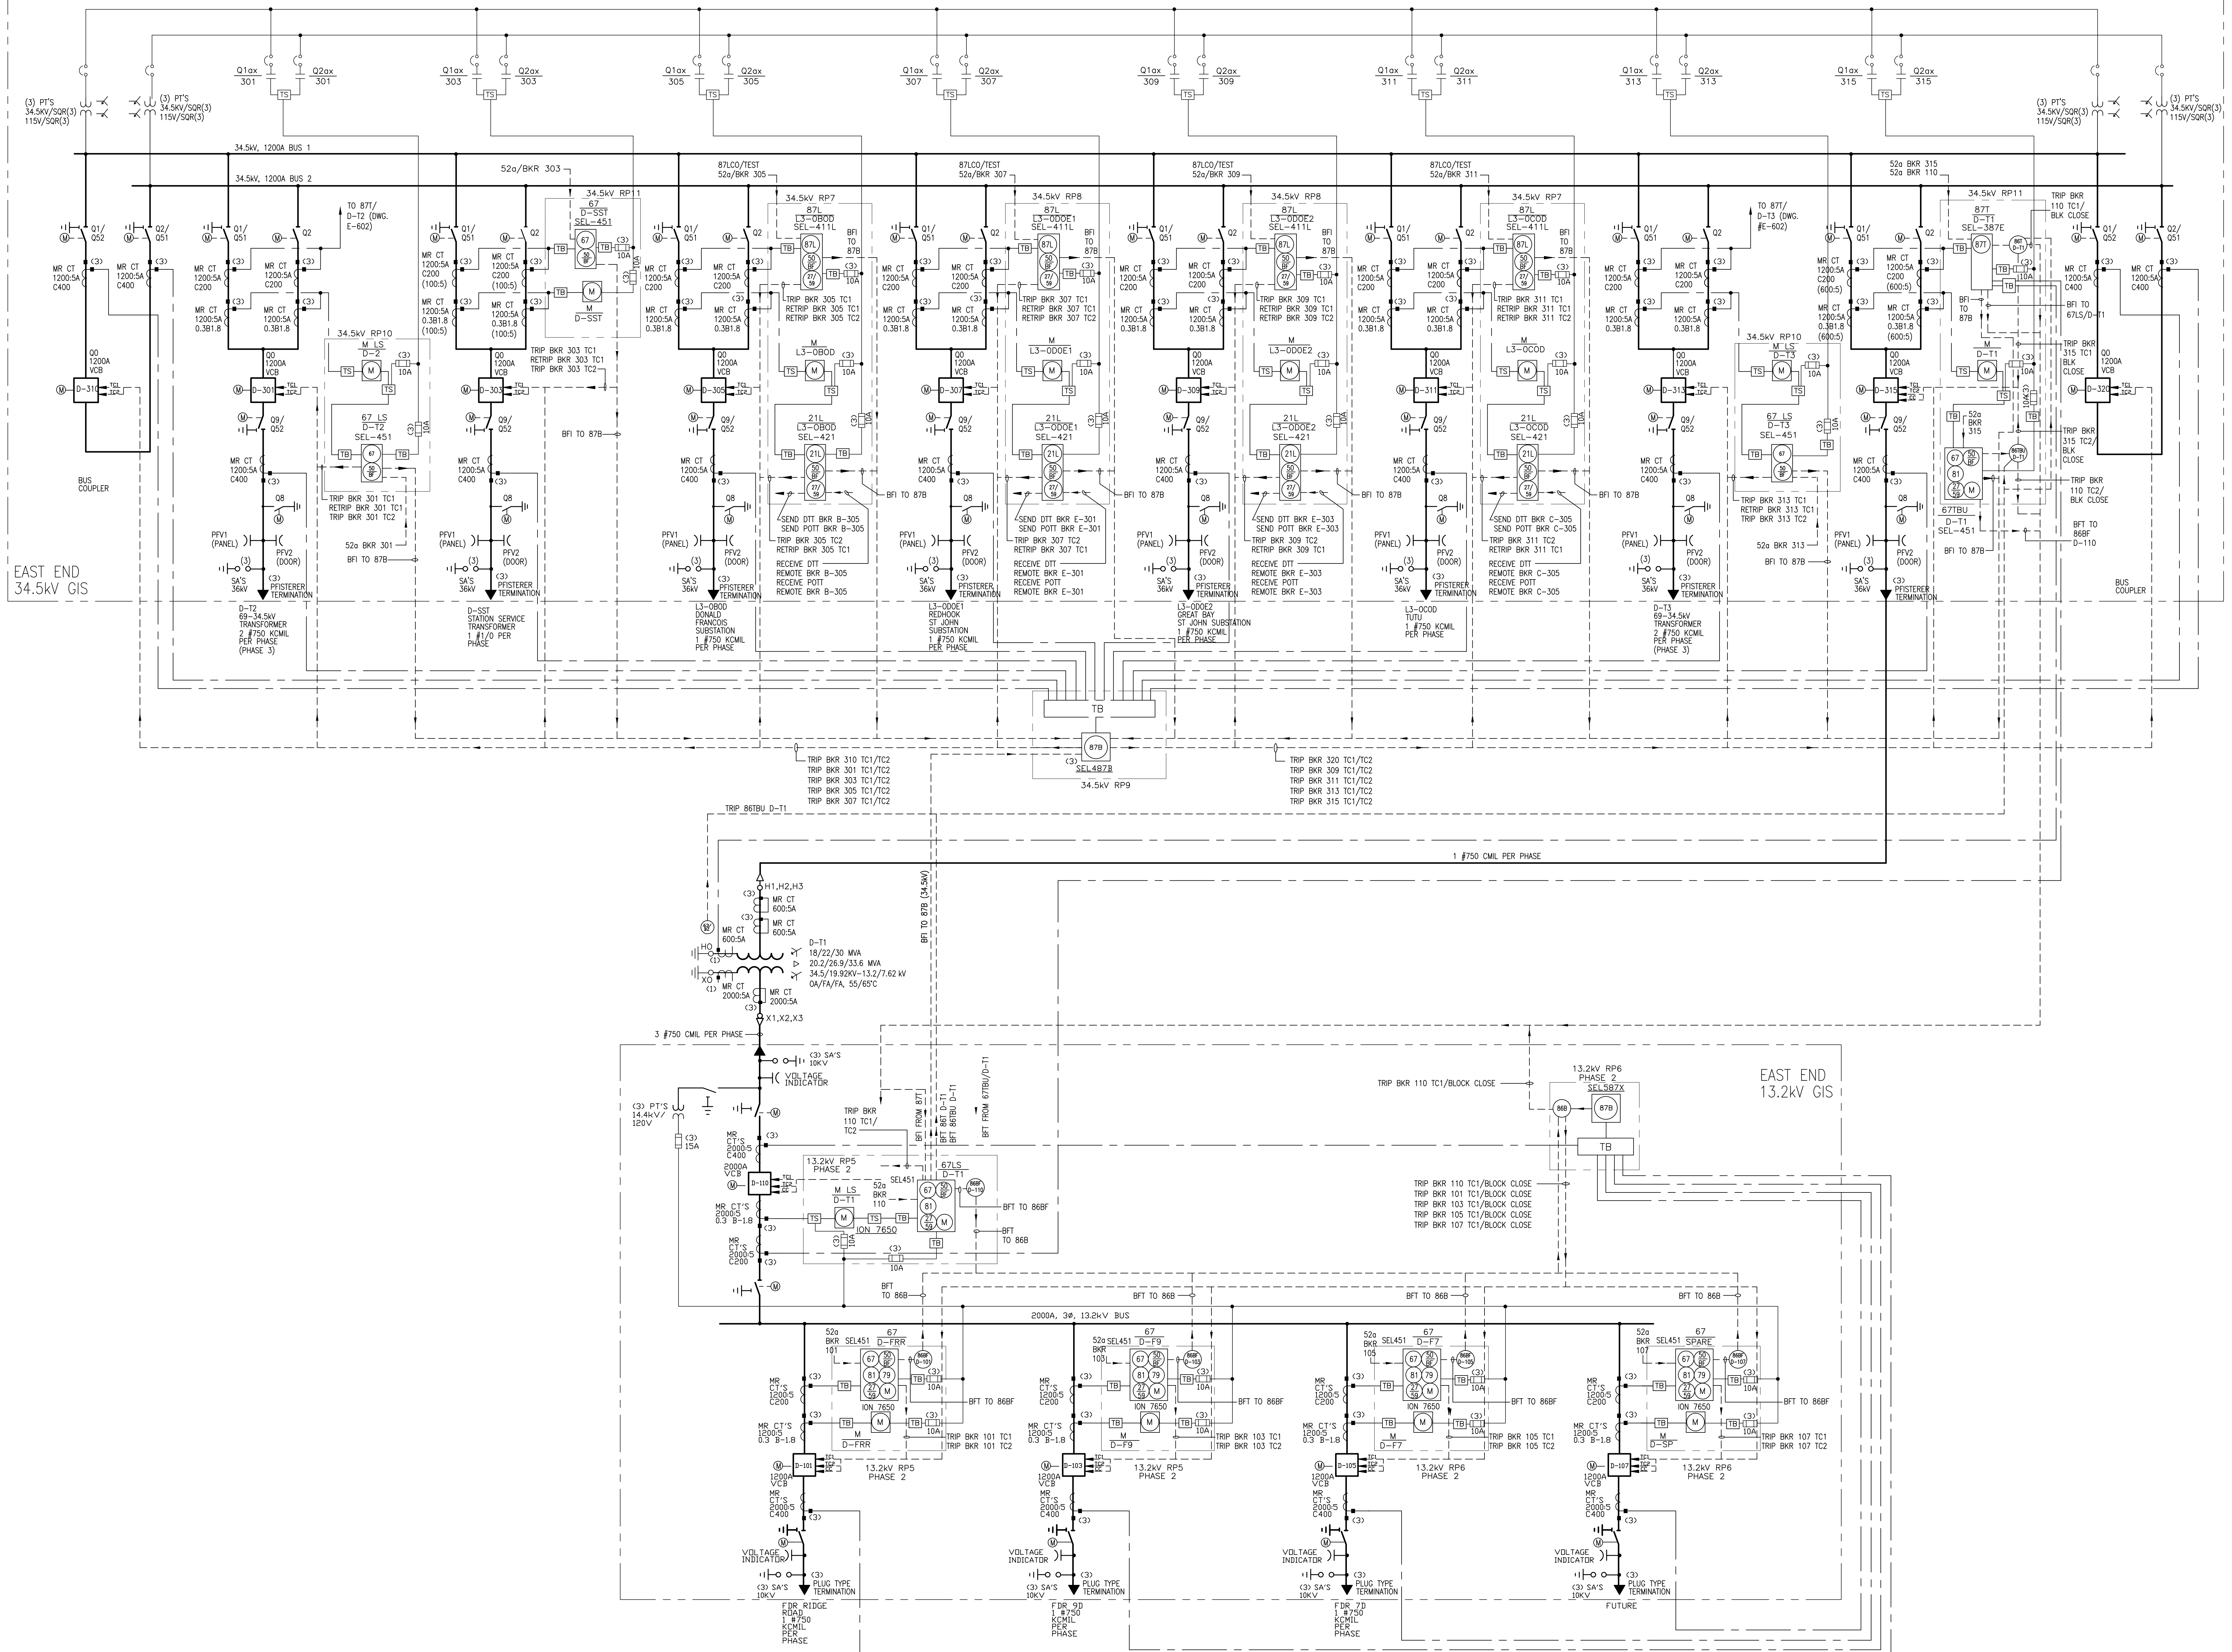



Sea

Click

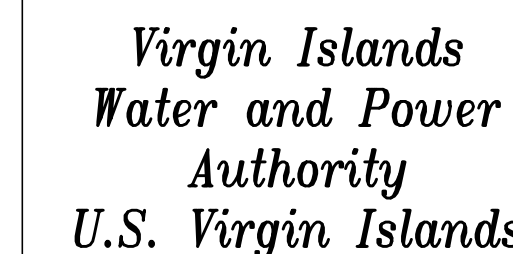

Project Name

East End Substation  
Restoration &  
Expansion Project  
St. Thomas, USVI  
PHASE 2

Issue / Revisions

[illegible]

Drawn By: \_\_\_\_\_

Chkd By:

Date: \_\_\_\_\_

Scale:

Project Number:	As Not
-----------------	--------

VII 182


RELAY PANEL  
ELEVATIONS  
RP1 THRU RP11, SCADA /  
COMMUNICATIONS  
PANEL

Drawing Number

STD-18257-E-603

Sheet Number of

Sheet Number of

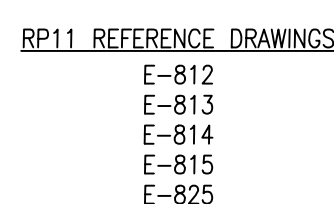


PHASE 2 13.2KV  
SCOPE OF WORK

## RELAY PANEL ELEVATION

## RP-1 THRU RP-11 & COMMUNICATIONS PANEL



SCALE: 1"=1'-0"

NOTE: DOOR REMOVED FOR CLARITY

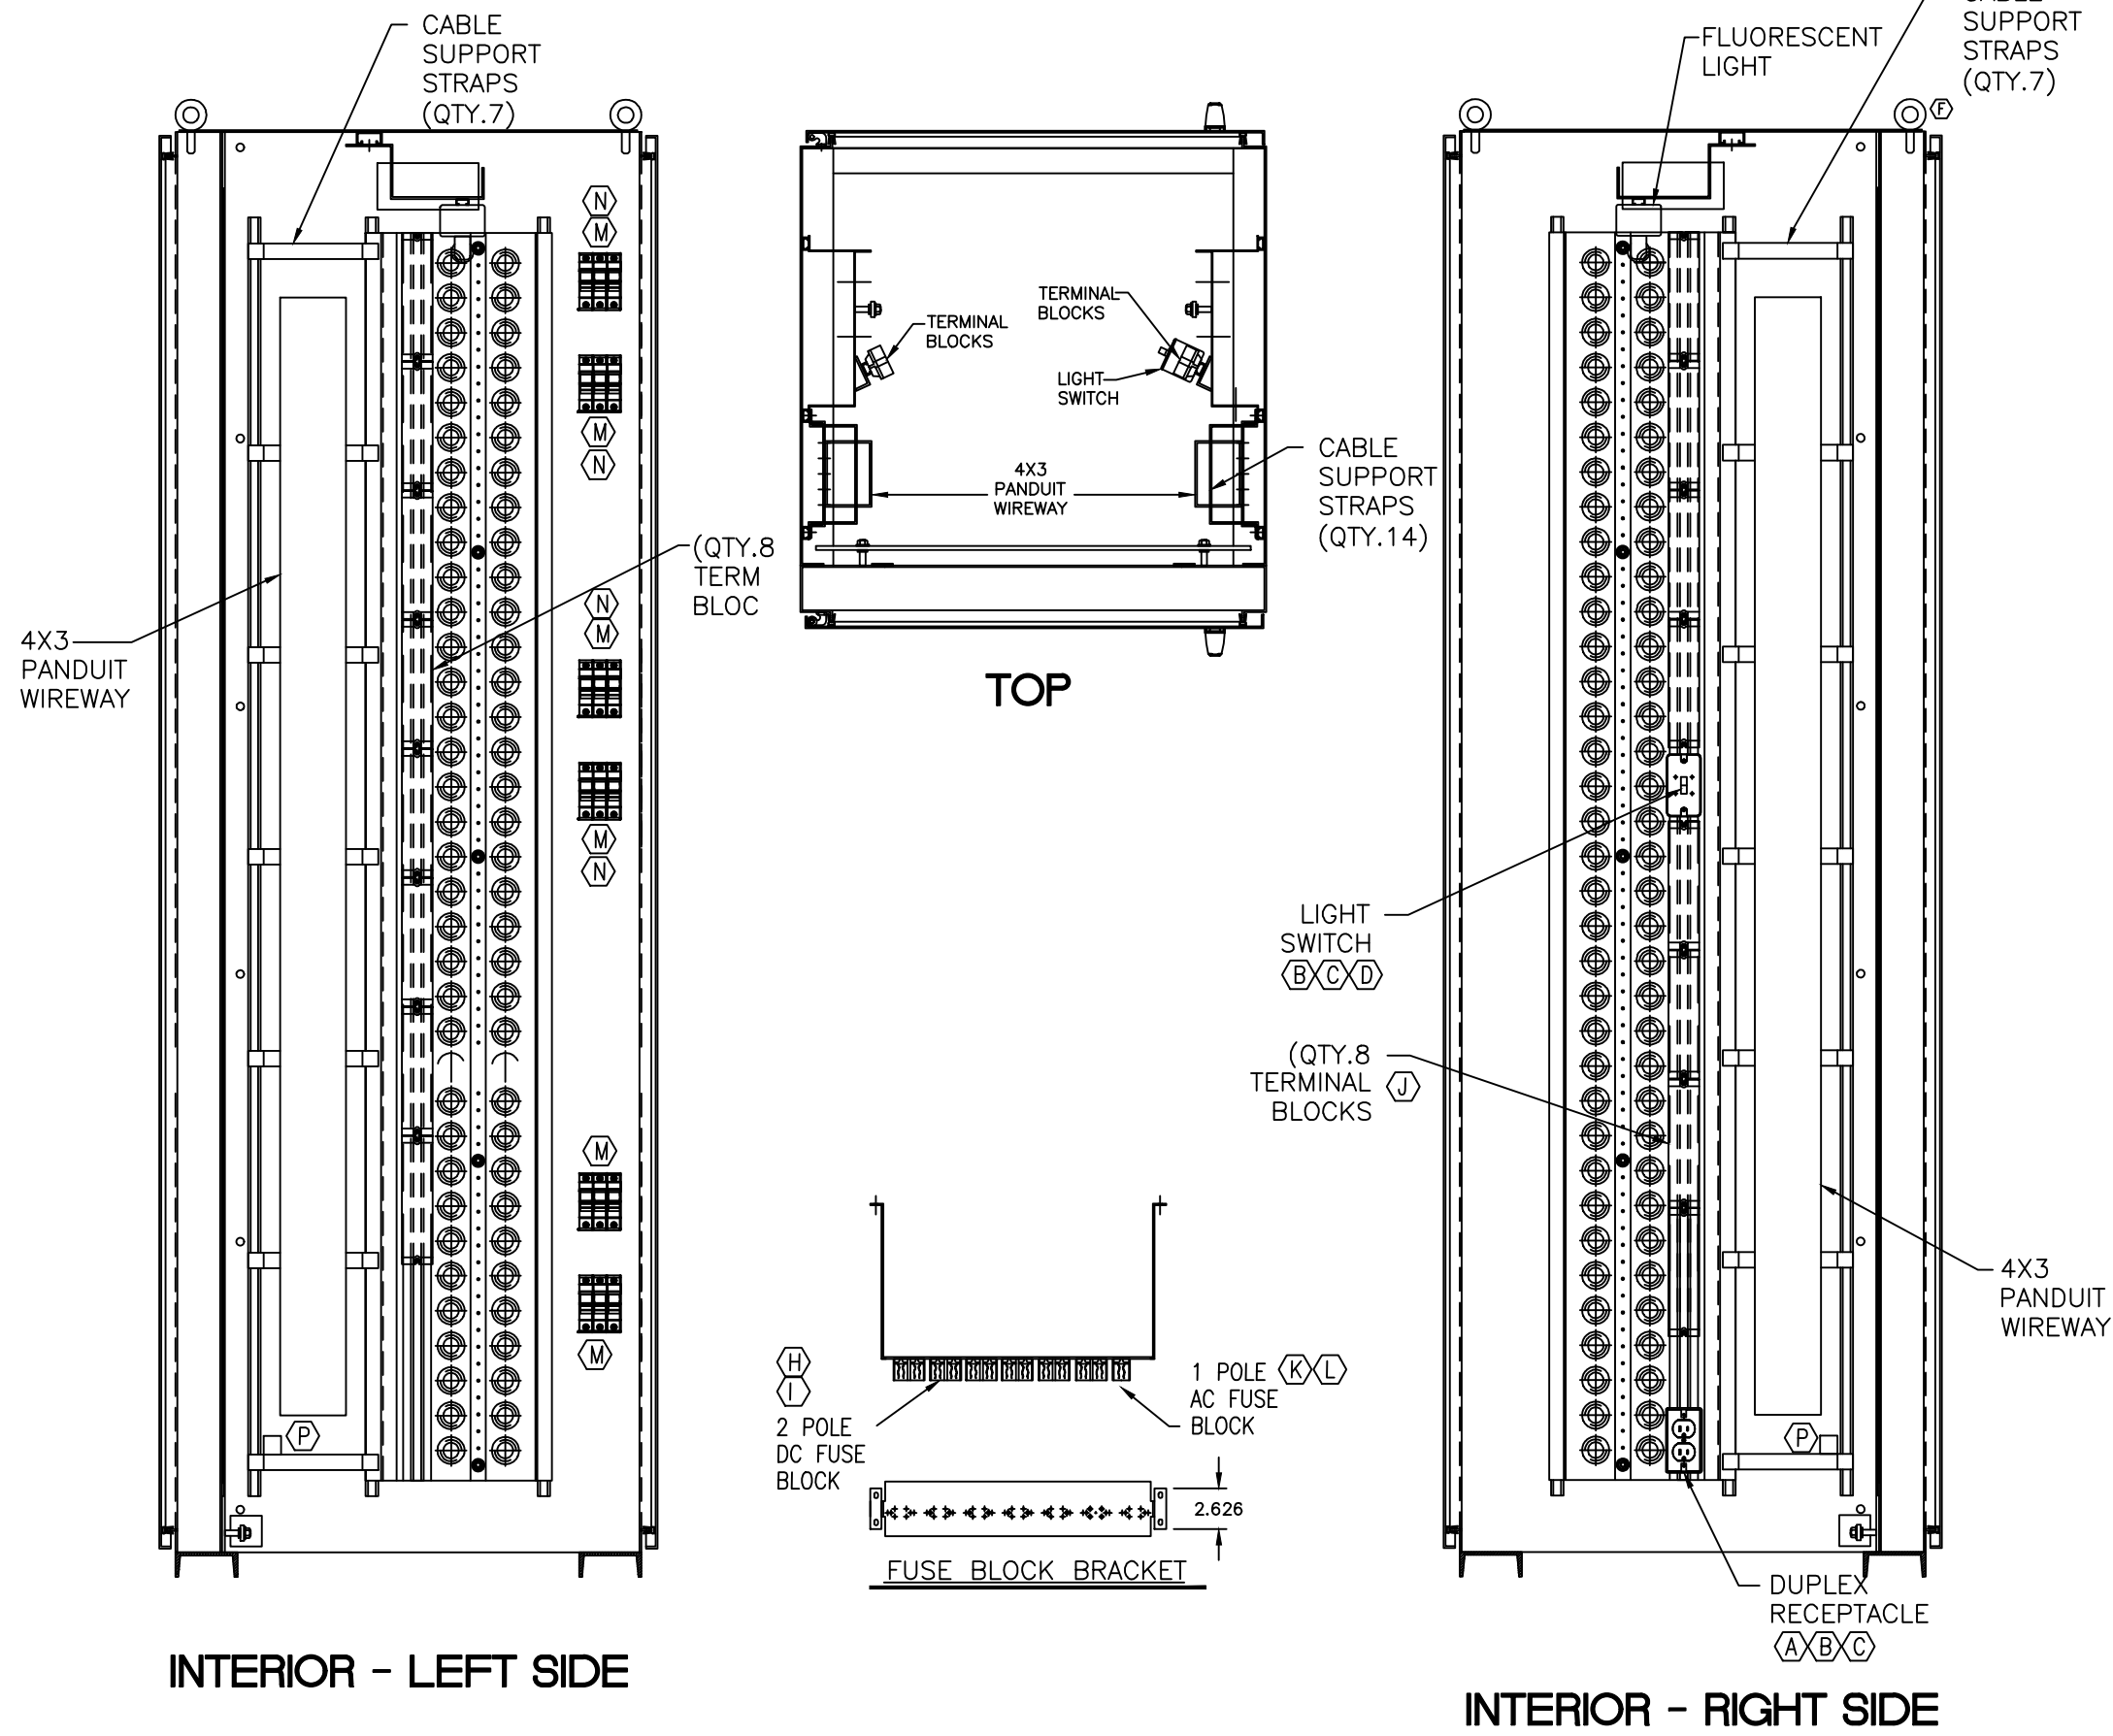

BILL OF MATERIALS				
DEVICE	STYLE NUMBER	QTY	MFR	DESCRIPTION
(A)	CR15	1	HUBBELL	DUPLEX RECEPTACLE, 3-WIRE GROUNDING, 15A, 125 VOLT
(B)	QB0001	2	T&B	HANDY BOX, DRAWN, GALVANIZED, 2 X 4, 1-7/8 DEPTH, WITH 1/2" KNOCKOUTS.
(C)		2	HUBBELL	SWITCH OR DUPLEX COVER PLATE
(D)	CS115	1	HUBBELL	SWITCH, SINGLE POLE, 15A, 120/277 VOLTS.
(E)		1		18" FLOURESCENT OR LED LIGHT FIXTURE, WITH LAMP
(F)		4		EYE BOLTS
(G)	BTC3104	2	T&B	MECHANICAL GROUNDING LUG #4-3/0 AWG.
(H)	F30A2S	6	MARATHON	FUSE BLK, 2-POLE, 30 AMP, 250 VOLT, CLASS H
(I)	NON10	12	BUSSMAN	FUSE, TYPE NON, ONE-TIME, CLASS H, 10A.
(J)	EB25B12	16	G.E.	TERMINAL BLOCK, TYPE EB-25, 1-PIECE, 12-CIRCUIT, 600-V, 30-A, WITH WASHER-HEAD SCREWS AND WHITE MARKING STRIP.
(K)	F30A1S	1	MARATHON	FUSE BLK, 1-POLE, 30AMP, 250 VOLT, CLASS H
(L)	NON10	1	BUSSMAN	FUSE, TYPE NON, ONE-TIME, CLASS H, 10A
(M)	CHM3D	6	BUSSMAN	AC FUSE HOLDER
(N)	NON05	18	BUSSMAN	FUSES, 5 AMP
(P)	DRS-1215	1	TRIPPLITE	RACKMOUNT ECONOMY SURGE SUPPRESSOR 14 OUTLET (6 FRONT/8 BACK)

- NOTES:**
- ALL DIMENSIONS ARE IN INCHES.
  - PANELS SHALL BE FABRICATED FROM 11 GA CRS.
  - PANELS TO BE BRACED AS REQUIRED TO INSURE A SMOOTH AND LEVEL SURFACE. ALL EXPOSED WELDS TO BE GROUND SMOOTH.
  - INTERIOR FINISH TO BE - HIGH GLOSS WHITE  
EXTERIOR FINISH TO BE - ANSI 61 GLOSS GRAY
  - BILL OF MATERIAL LIST IS TYPICAL FOR 2 13.2KV RELAY PANELS

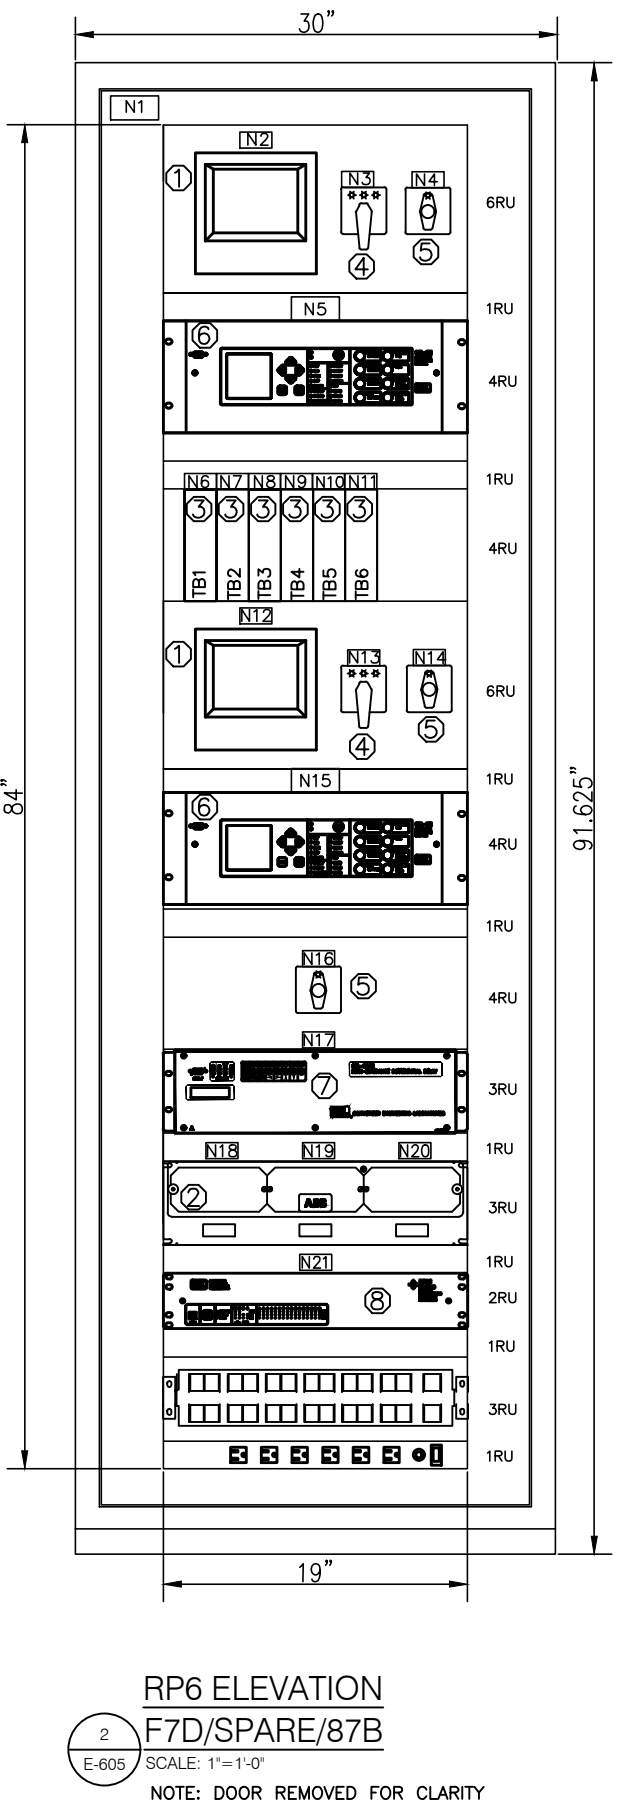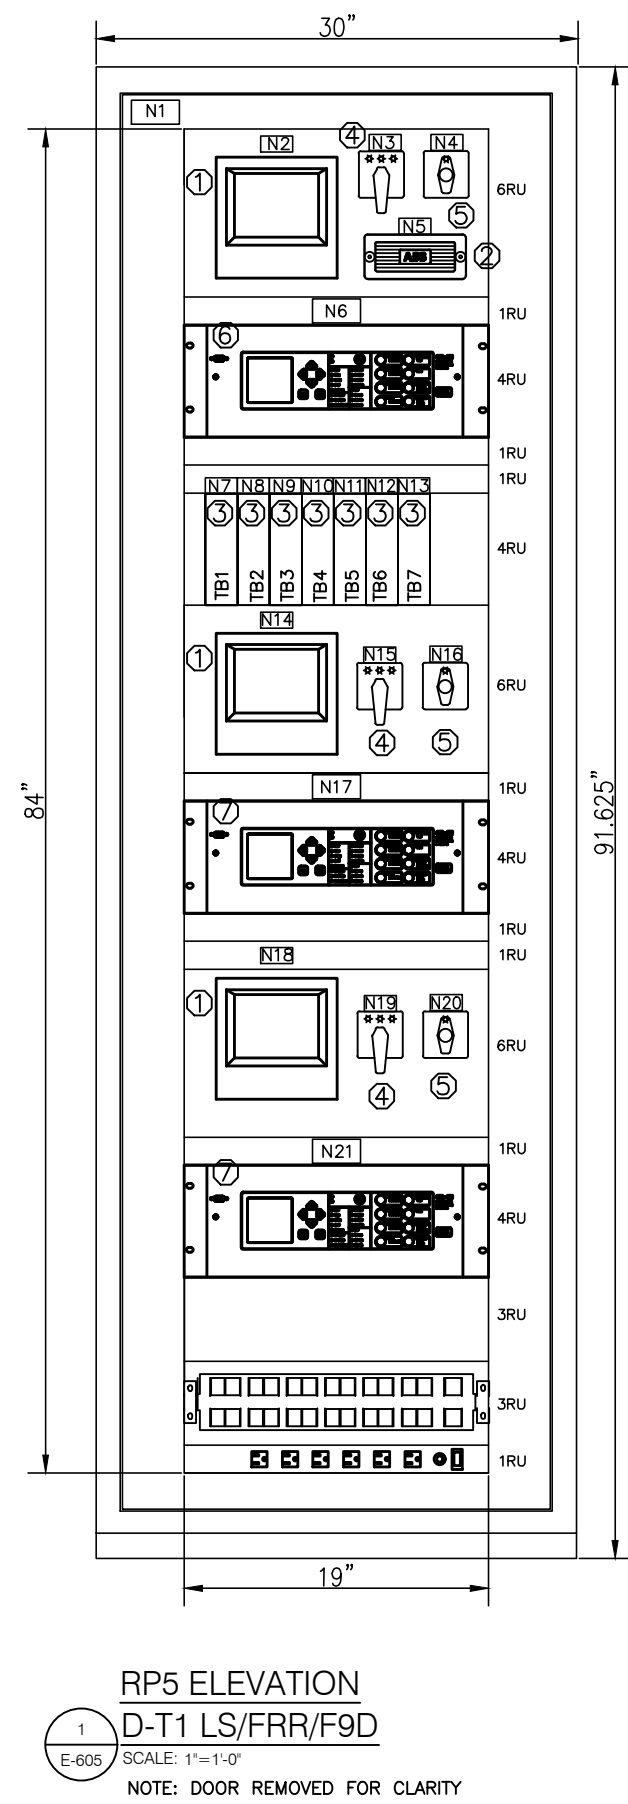

## BILL OF MATERIALS

ITEM	DESCRIPTION	QTY	MANUFACT.	CATALOG No.
①	POWER METER	3	ION (SCHNEIDER)	M7650 AOC0B6F1A0A
②	TEST SWITCH (FT-1)	2	ABB	F 129A528G01 (CODE 26)
③	TEST BLOCK	7	AREVA	MMLG01
④	CB CONTROL SWITCH, 6 DECKS, TRIP/CLOSE & PULL TO LOCK, WITH TRIP COIL MONITOR	3	ELECTROSWITCH	24PD58D
⑤	LOCKOUT RELAY (MANUAL RESET), 4 DECKS, W/TRIP COIL MONITOR & FAULT INDICATOR	3	ELECTROSWITCH	78P B GXR X 04 D
⑥	TRANSFORMER FEEDER PROTECTION RELAY	1	SEL	04515625XC0X4H224XX2X W/ HARNESS WA04510BC2A
⑦	FEEDER PROTECTION RELAY	2	SEL	04515625XC0X4H224XX2X W/ HARNESS WA04510BC2A

2 ELECTROSWITCH

## NAMEPLATE SCHEDULE

NO.	FIRST LINE	SECOND LINE	SIZE	TEXT
N1	RP5 13.2KV		3" X 1-1 1/2"	5/16"
N2	M-D-110		2" X 1"	3/16"
N3	CB-D-110		2" X 1"	3/16"
N4	86BF D-110		2" X 1"	3/16"
N5	TS1 M-D-110		2" X 1"	3/16"
N6	67LS	D-T1	3" X 1-1 1/2"	3/16"
N7	TB1-67 DT1		2" X 1"	3/16"
N8	TB2-67 DT1		2" X 1"	3/16"
N9	TB3-67 DT1		2" X 1"	3/16"
N10	TB4-67 FRR		2" X 1"	3/16"
N11	TB5-67 FRR		2" X 1"	3/16"
N12	TB6-67 F9D		2" X 1"	3/16"
N13	TB7-67 F9D		2" X 1"	3/16"
N14	M-D-101		2" X 1"	3/16"
N15	CB-D-101		2" X 1"	3/16"
N16	86BF D-101		2" X 1"	3/16"
N17	67	D-FRR	3" X 1-1 1/2"	3/16"
N18	M-D-103		2" X 1"	3/16"
N19	CB-D-103		2" X 1"	3/16"
N20	86BF D-103		2" X 1"	3/16"
N21	67	D-F9	3" X 1-1 1/2"	3/16"

## BILL OF MATERIALS


ITEM	DESCRIPTION	QTY	MANUFACT.	CATALOG No.
①	POWER METER	2	ION (SCHNEIDER)	M7650 AOC0B6F1A0A
②	TEST SWITCH (FT-19) NO. OF POLES 10+10+10 ARRANGEMENT POSITION A: P C-C P C-C P C-C P POSITION B: P C-C P C-C P C-C P POSITION C: P C-C P C-C P C-C P COVER: FULL CLEAR TERMINALS: SCREW TERMINALS	1	ABB	TBD
③	TEST BLOCK	6	AREVA	MMLG01
④	CB CONTROL SWITCH, 6 DECKS, TRIP/CLOSE & PULL TO LOCK, WITH TRIP COIL MONITOR	2	ELECTROSWITCH	24PD58D
⑤	LOCKOUT RELAY (MANUAL RESET), 4 DECKS, W/TRIP COIL MONITOR & FAULT INDICATOR	3	ELECTROSWITCH	78P B GXR X 04 D
⑥	FEEDER PROTECTION RELAY	2	SEL	04515625XC0X4H224XX2X W/ HARNESS WA04510BC2A
⑦	THREE PHASE BUS DIFFERENTIAL RELAY	1	SEL	0587Z0X625H2ZXX
⑧	DPAC CONTROLLER	1	SEL	24402H12A1A11631

## NAMEPLATE SCHEDULE

NO.	FIRST LINE	SECOND LINE	SIZE	TEXT
N1	RP6 13.2KV		3" X 1-1 1/2"	5/16"
N2	M-D-105		2" X 1"	3/16"
N3	CB-D-105		2" X 1"	3/16"
N4	86BF D-105		2" X 1"	3/16"
N5	67	D-F7	3" X 1-1 1/2"	3/16"
N6	TB1-67 D-F7		2" X 1"	3/16"
N7	TB2-67 D-F7		2" X 1"	3/16"
N8	TB3-67 SPARE		2" X 1"	3/16"
N9	TB4-67 SPARE		2" X 1"	3/16"
N10	TB5-86B			
N11	TB6-86B		2" X 1"	3/16"
N12	M-D-107		2" X 1"	3/16"
N13	CB-D-107		2" X 1"	3/16"
N14	86BF D-107		2" X 1"	3/16"
N15	67	SPARE	3" X 1-1 1/2"	3/16"
N16	86B	13.2KV BUS	3" X 1-1 1/2"	3/16"
N17	87B	13.2KV BUS	3" X 1-1 1/2"	3/16"
N18	TS1-87B		2" X 1"	3/16"
N19	TS2-87B		2" X 1"	3/16"
N20	TS3-SPARE		2" X 1"	3/16"
N21	DPAC-2		2" X 1"	3/16"

Seal:

Client:

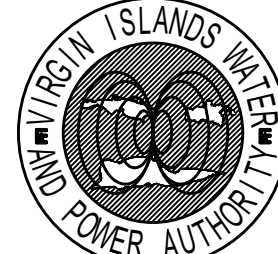

*Virgin Islands  
Water and Power  
Authority  
U.S. Virgin Islands*

Project Name:

East End Substation  
Restoration &  
Expansion Project  
St. Thomas, USVI  
PHASE 2

Issue / Revisions:

#	Date	Description
0	10/17/19	Issue for Phase 2 Bid
1	12/03/19	Issue for Phase 2 Bid

Drawn By: PJB  
Checked By: PJB  
Date: 12.03.19  
Scale: As Noted  
Project Number: VIT 18257  
Drawing Title:

13.2KV RELAY PANEL  
ELEVATIONS  
&  
BILL OF MATERIALS

Drawing Number:


STD-18257-E-605

Sheet Number of

© 2019 FXB, Inc





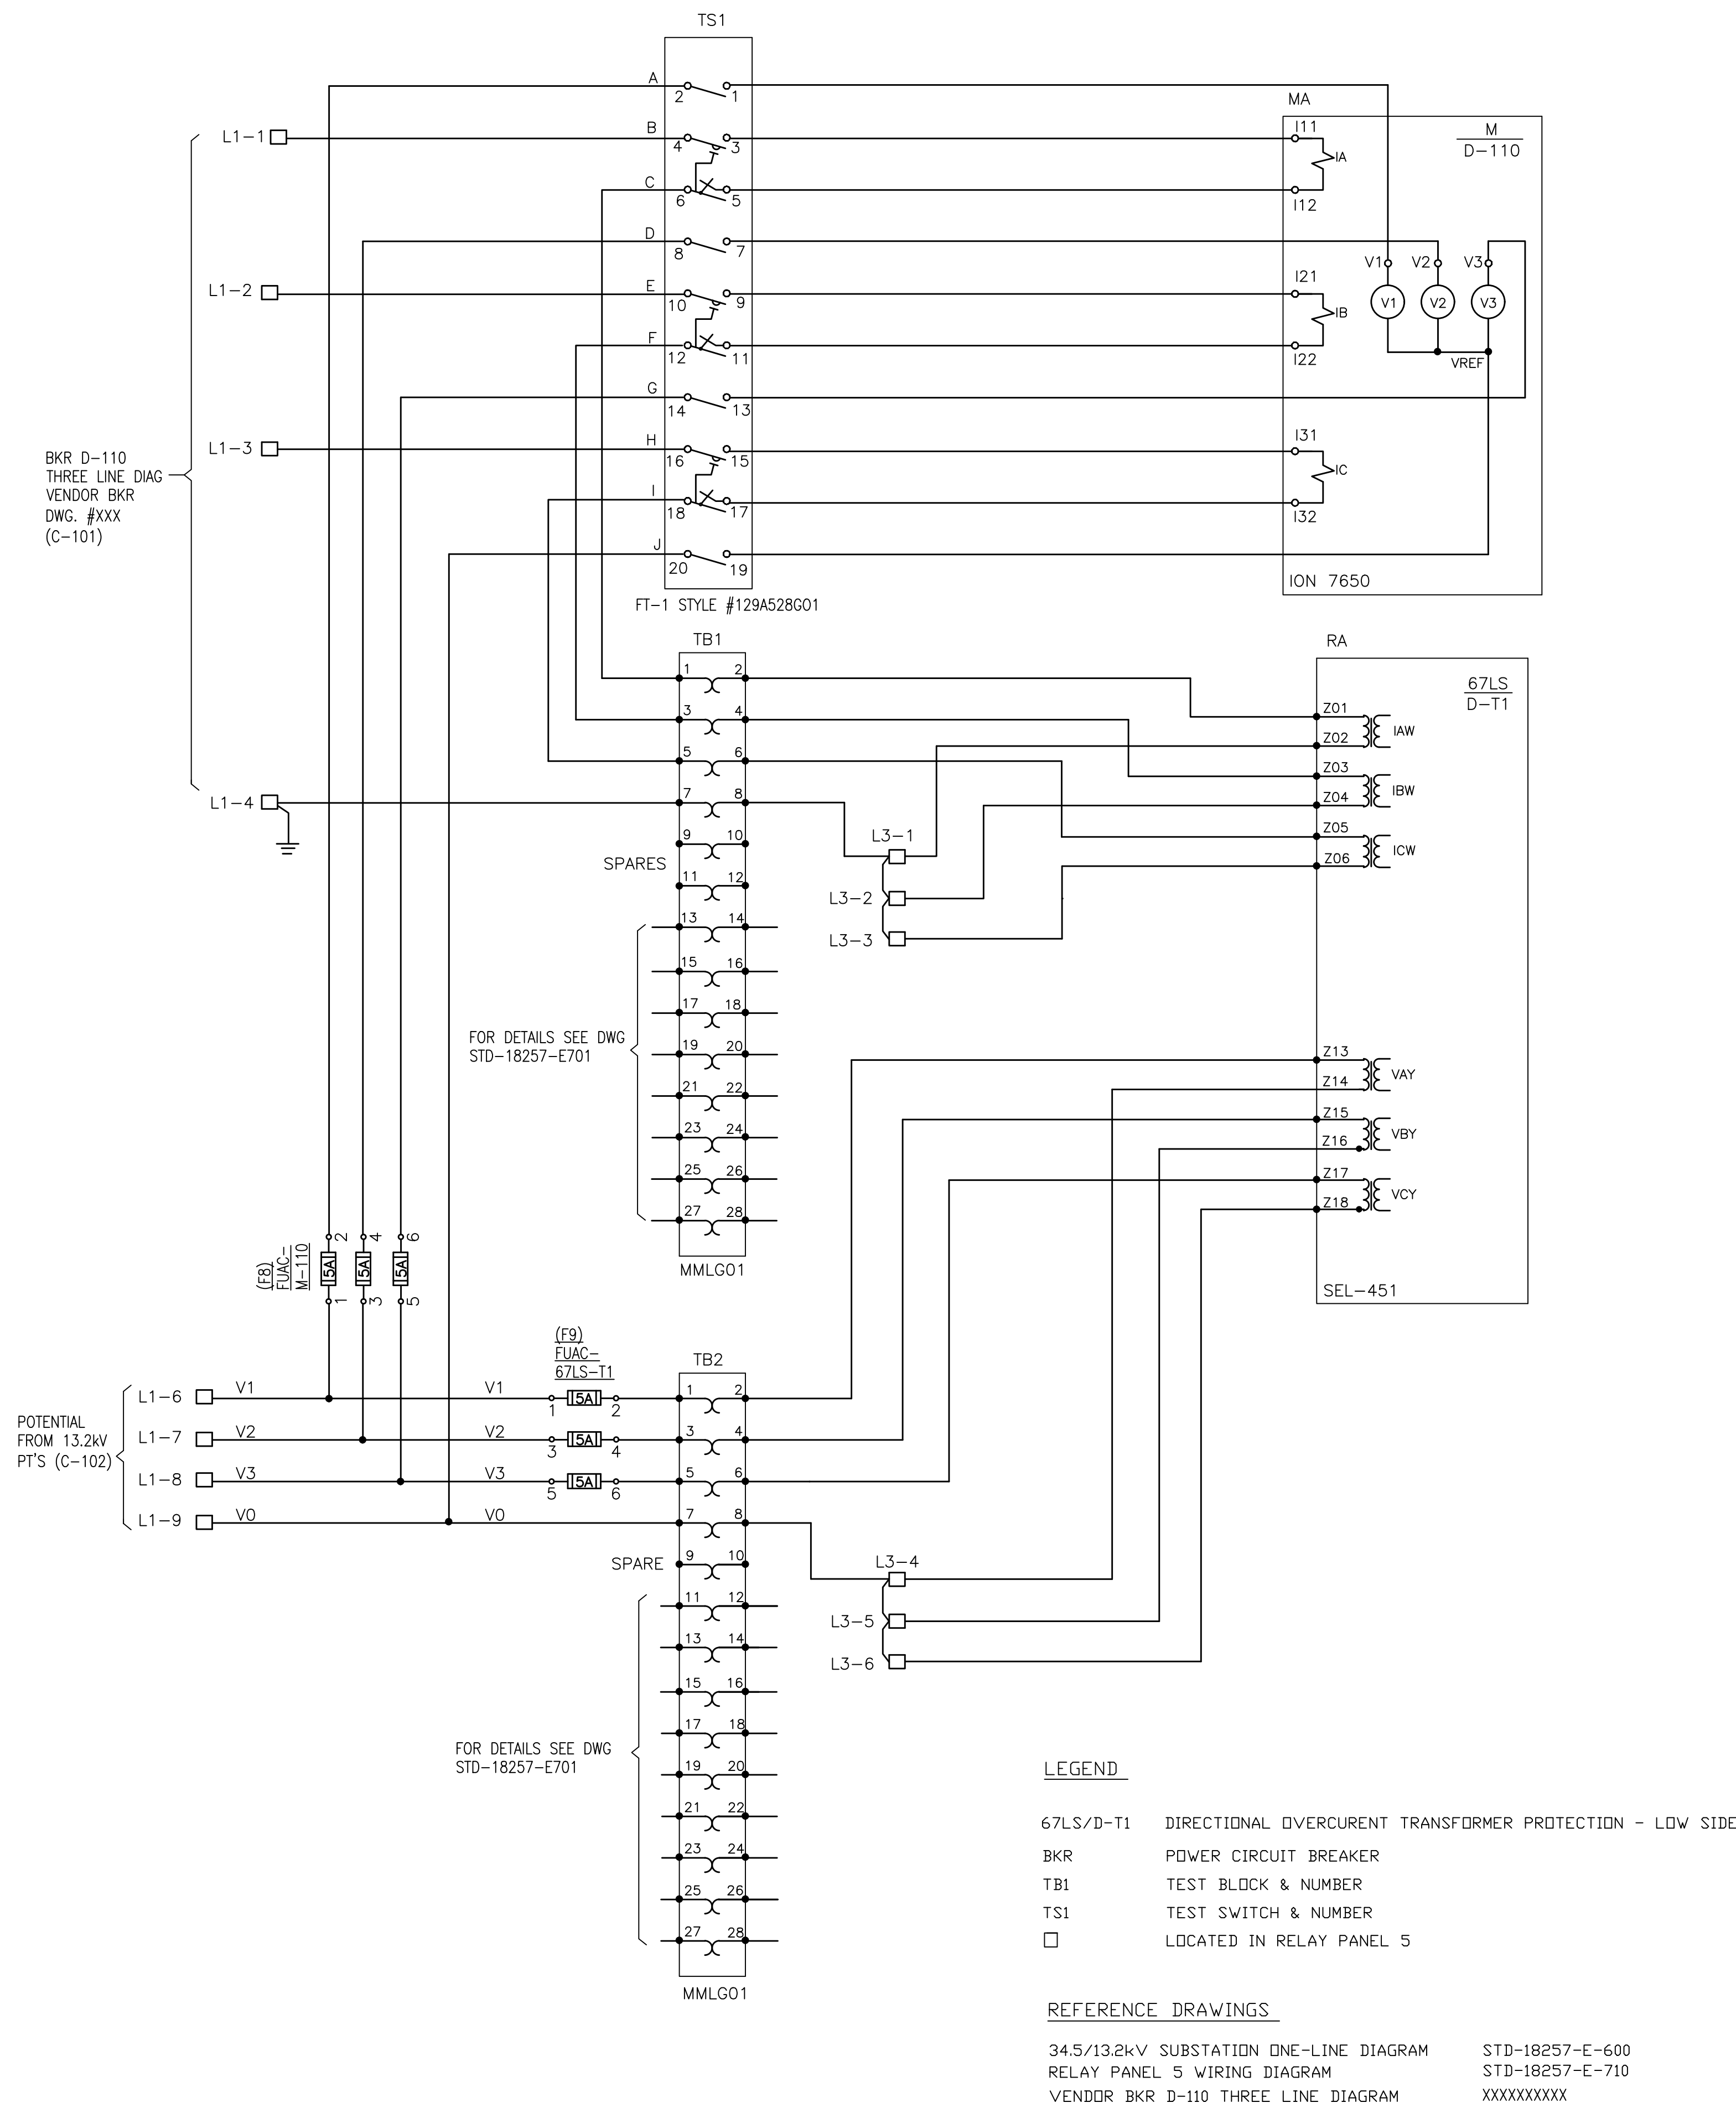

Seal:

Client:



*Virgin Islands  
Water and Power  
Authority  
U.S. Virgin Islands*

Project Name:

East End Substation  
Restoration &  
Expansion Project  
St. Thomas, USVI  
Phase 2 (13.2kV GIS)

Issue / Revisions:

#	Date	Description
A	07.25.19	Issue for Phase 2 Bid Review
O	10.17.19	Issue for Phase 2 Bid

Drawn By: PJB  
Checked By: PJB  
Date: 10.17.19  
Scale: As Noted  
Project Number: VIT 18257

Drawing Title:  
**AC ELEMENTARY  
DIAGRAM  
D-T1 LOW SIDE  
PROTECTION RELAY  
13.2kV RP5**

Drawing Number:

**STD-18257-E-700**

Sheet Number 1 of 1  
©2019 FXB, Inc






5 Christy Drive, Suite 307  
Chadds Ford, PA 19317  
610.558.3464 office  
www.fxbinco.com

Engineering Excellence Since 1968

Seal:

Client:

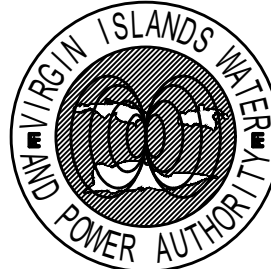

Virgin Islands  
Water and Power  
Authority  
U.S. Virgin Islands

Project Name:

East End Substation  
Restoration &  
Expansion Project  
St. Thomas, USVI  
Phase 2 (13.2kV GIS)

Issue / Revisions:

#	Date	Description
A	07.25.19	Issue for Phase 2 Bid Review
O	10.17.19	Issue for Phase 2 Bid

Drawn By: PJB

Checked By: PJB

Date: 10.17.19

Scale: As Noted

Project Number: VIT 18257





Drawing Title:

DC ELEMENTARY  
DIAGRAM  
D-T1 LOW SIDE  
PROTECTION RELAY  
13.2kV RP5

Drawing Number:

STD-18257-E-701

Sheet Number 1 of 1  
©2019 FXB, Inc

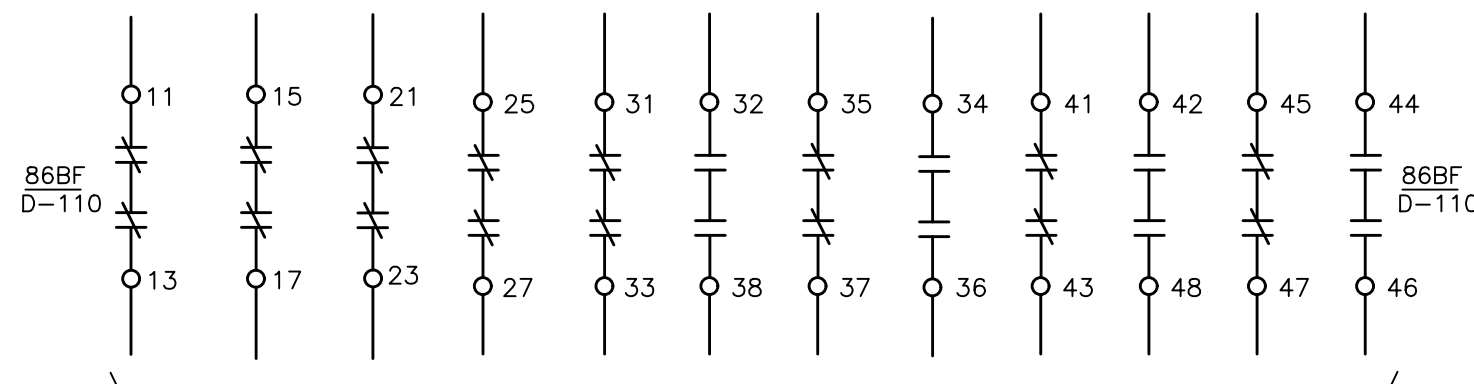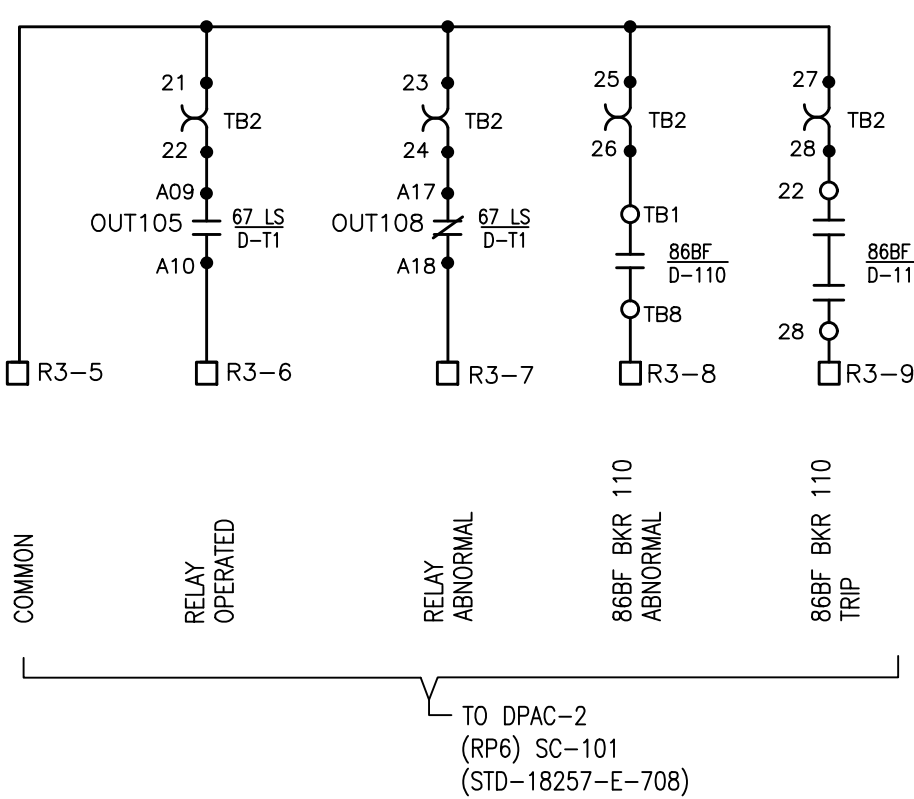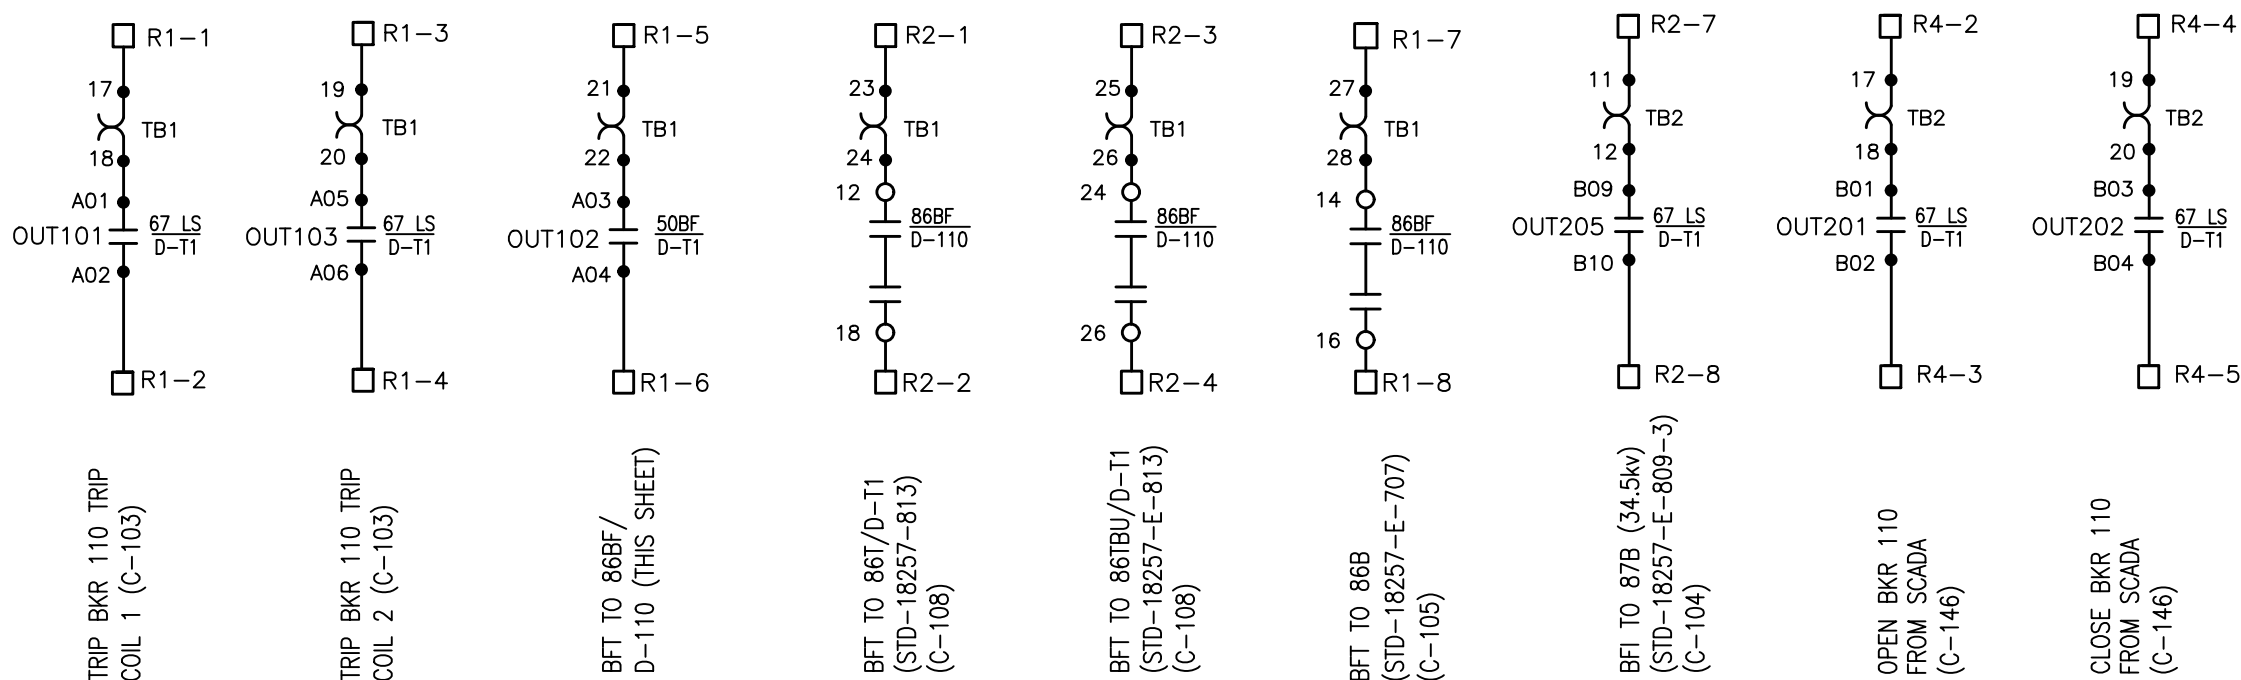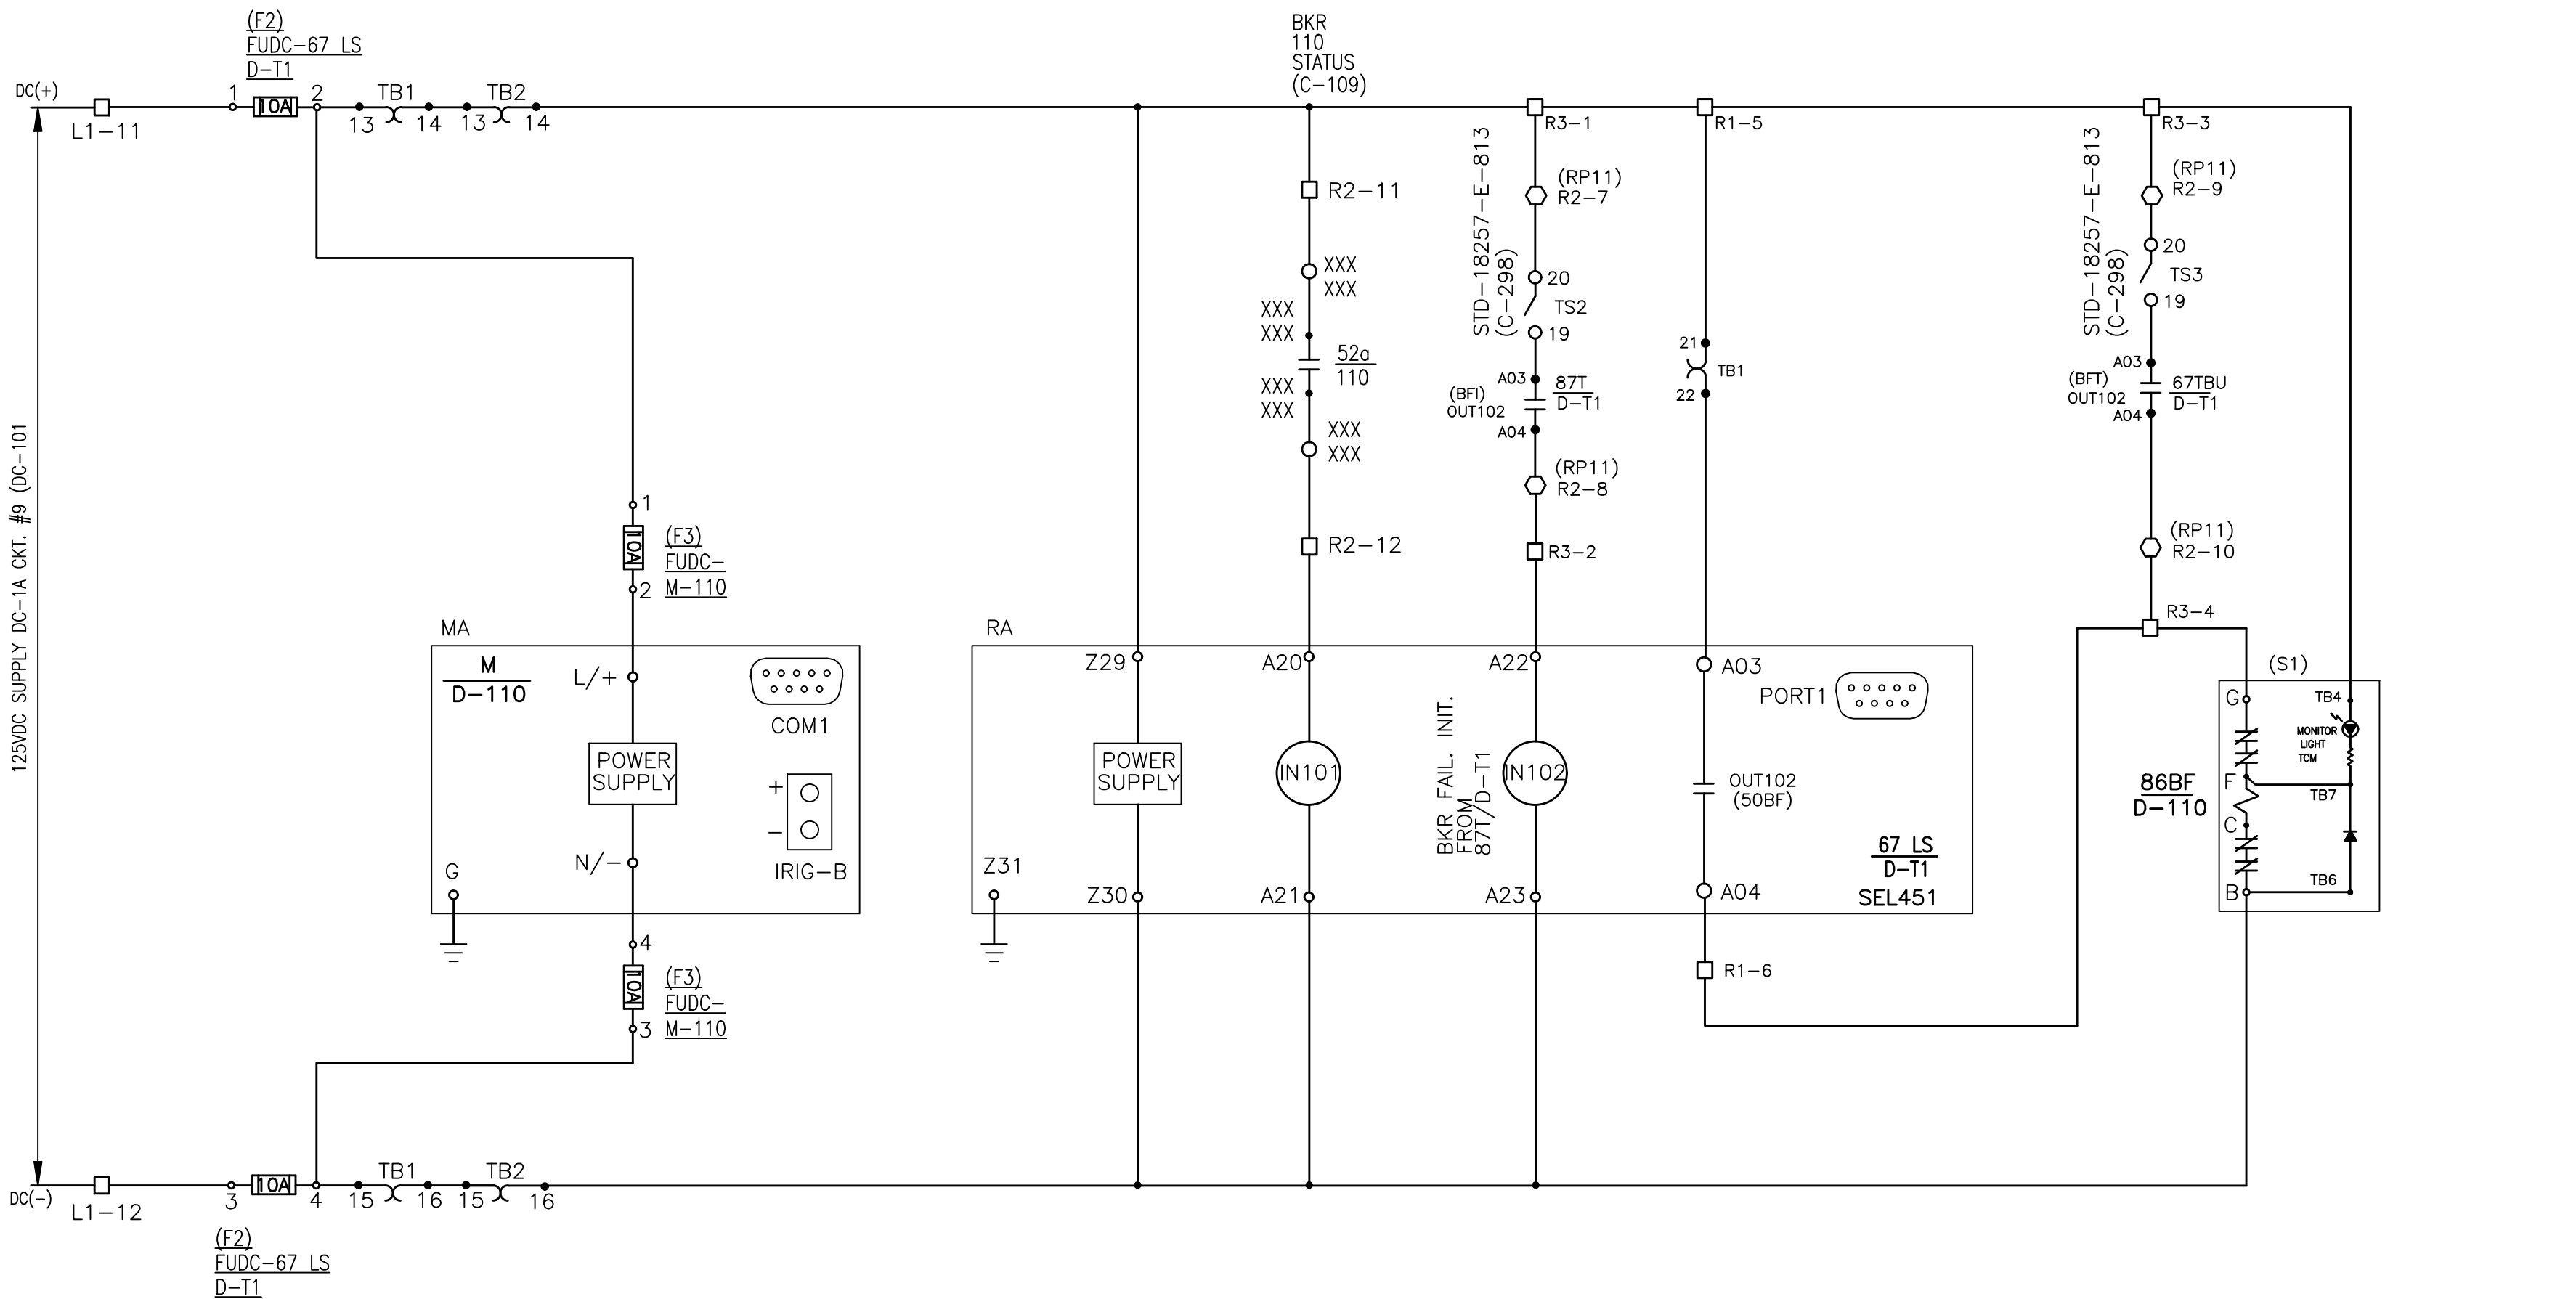


DC ELEMENTARY DIAGRAM  
D-T1

LEGEND

- 67LS DIRECTIONAL OVERCURRENT TRANSFORMER LOW SIDE
- TB1 TEST BLOCK & NUMBER
- TS1 TEST SWITCH & NUMBER
- BKR POWER CIRCUIT BREAKER
- LOCATED IN RELAY PANEL 5
- LOCATED AT 13.2KV GIS

REFERENCE DRAWINGS

- 34.5/13.2kV SUBSTATION ONE-LINE DIAGRAM
- RELAY PANEL 5 WIRING DIAGRAM
- DC ELEMENTARY DIAGRAM 13.2kV BUS DIFFERENTIAL PROTECTION
- DC ELEMENTARY DIAGRAM DPAC-2
- DC ELEMENTARY DIAGRAM BUS 1-2 DIFFERENTIAL RELAY 34.5kV
- DC ELEMENTARY DIAGRAM D-T1 PRIMARY/SECONDARY RELAY
- VENDOR BKR D-110 DC ELEMENTARY DIAGRAMS
- STD-18257-E-600
- STD-18257-E-710
- STD-18257-E-707
- STD-18257-E-708
- STD-18257-E-809-3
- STD-18257-E-813
- XXXXXXXXXX

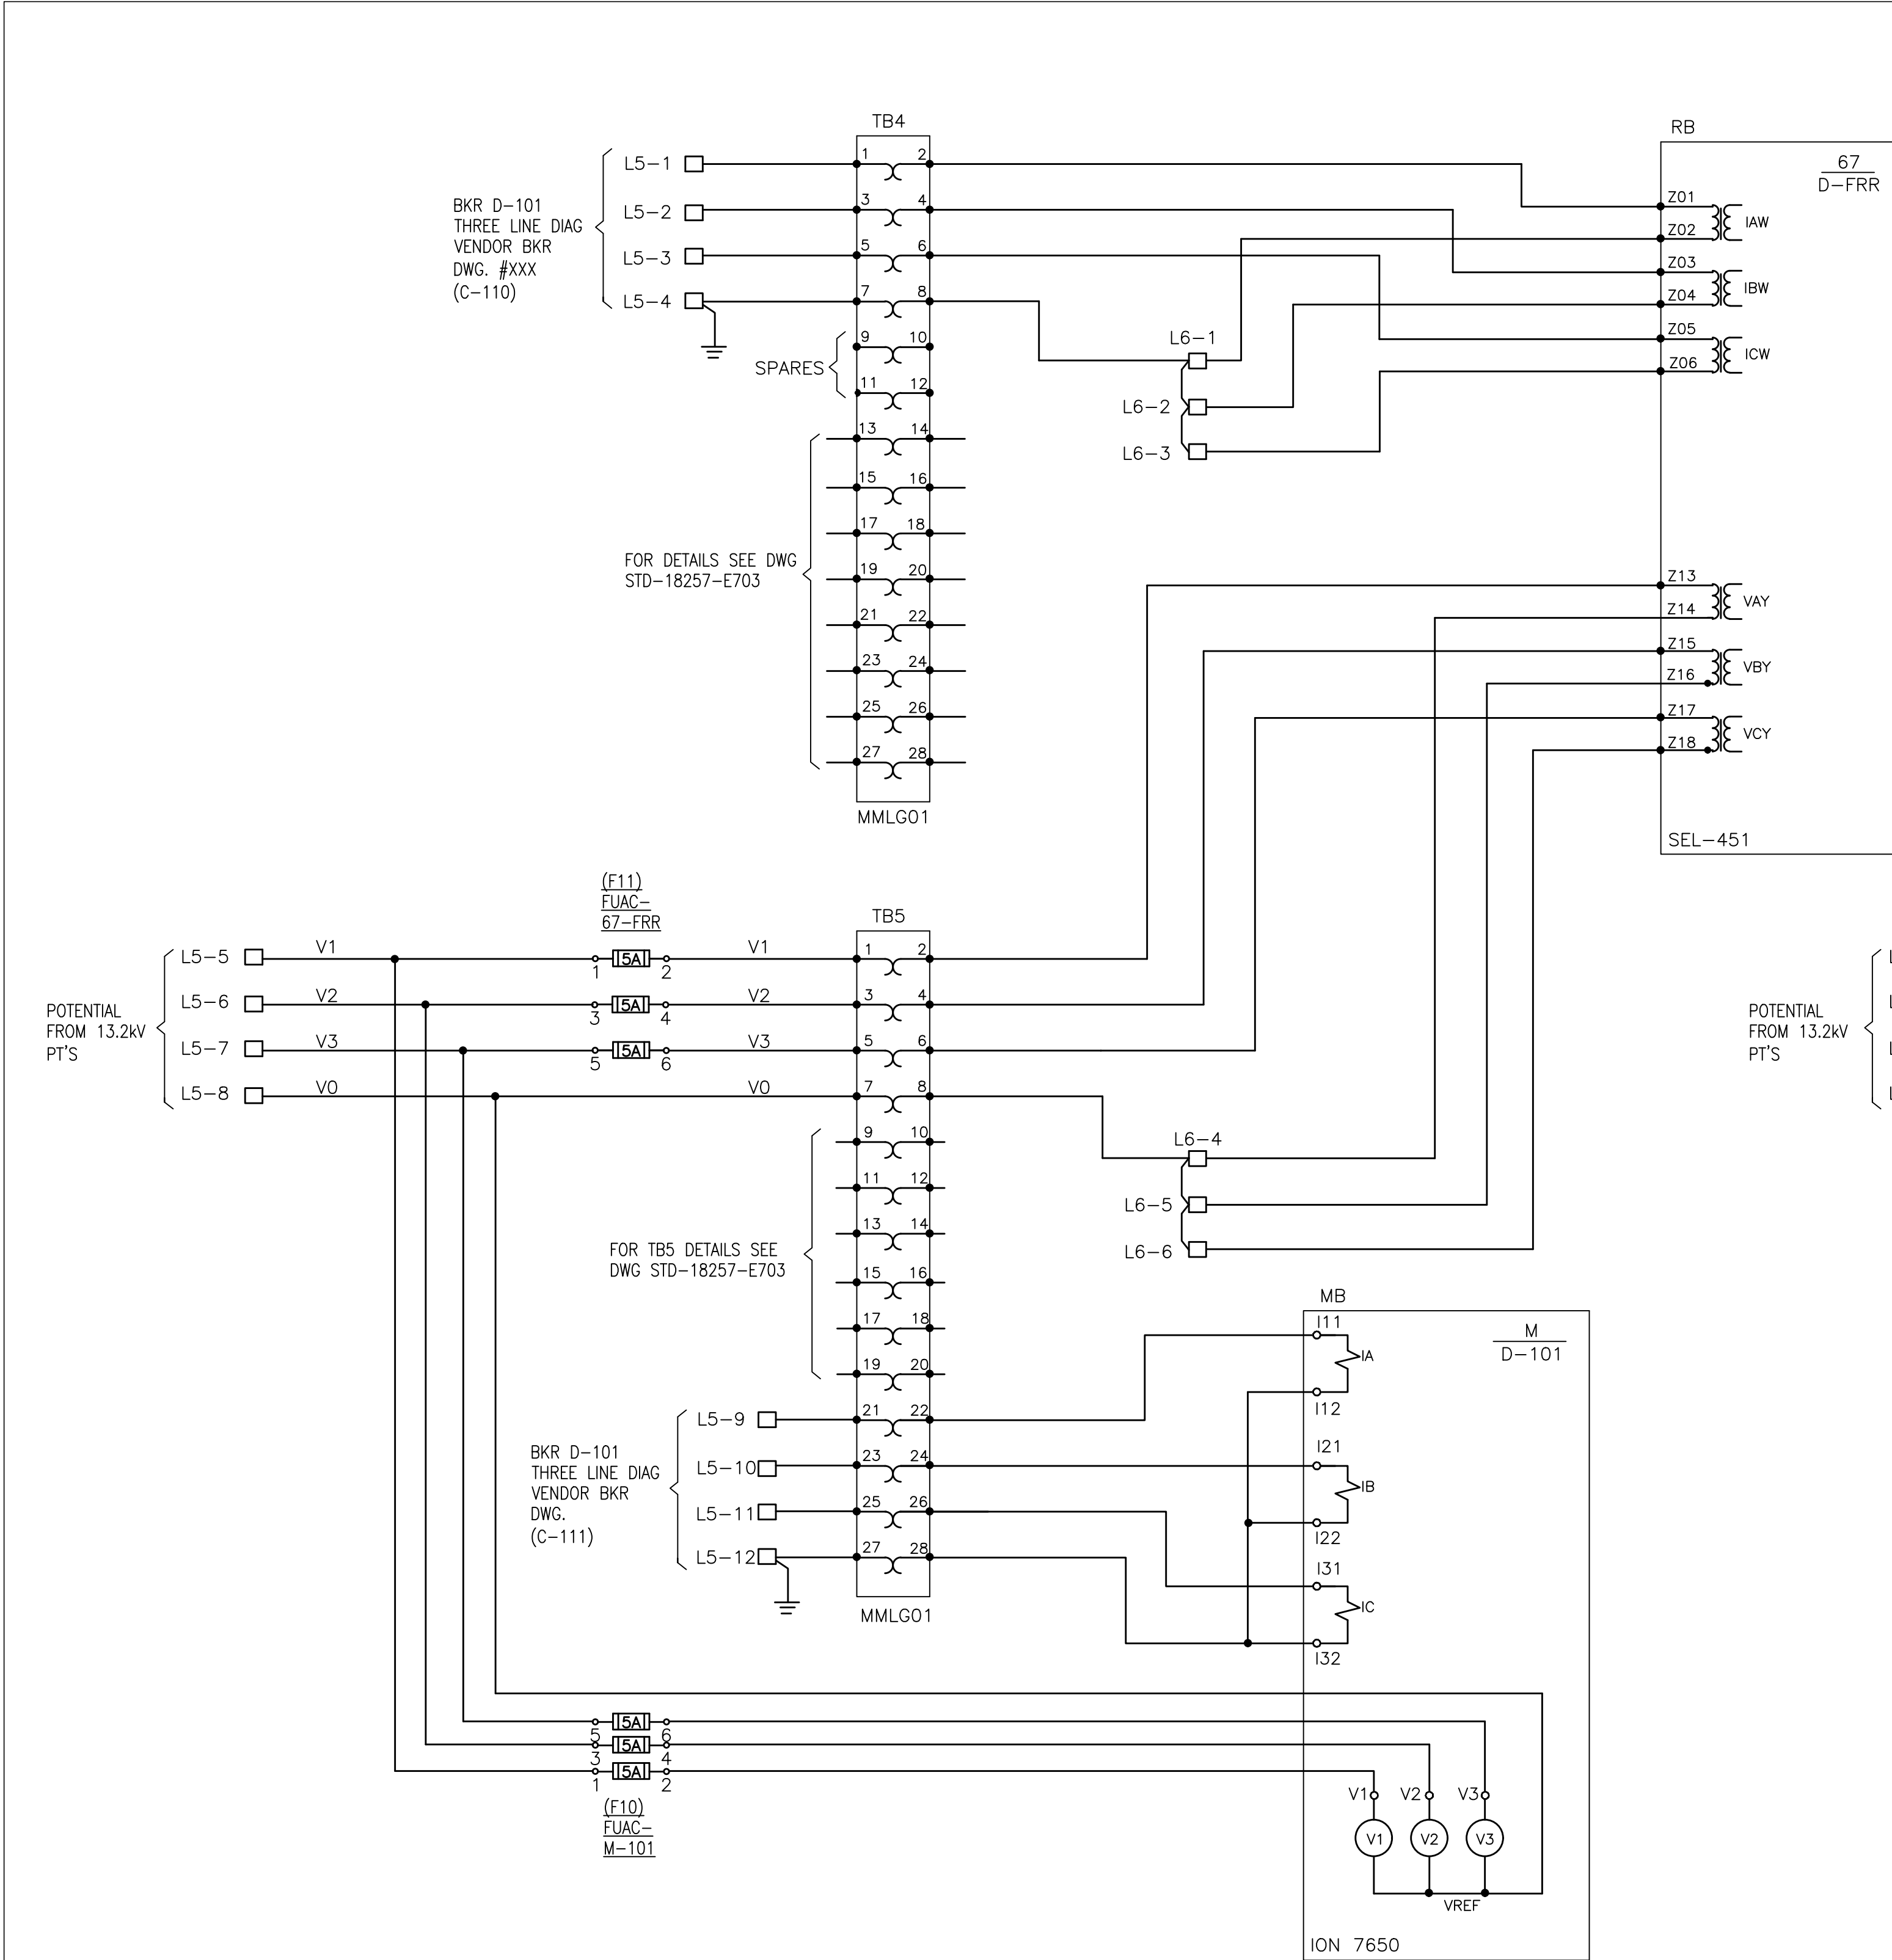


AC ELEMENTARY DIAGRAM  
D-FRR

LEGEND

- 67 DIRECTIONAL OVERCURRENT RELAY
- BKR POWER CIRCUIT BREAKER
- TB1 TEST BLOCK & NUMBER
- TS1 TEST SWITCH & NUMBER
- LOCATED IN RELAY PANEL 5

REFERENCE DRAWINGS


- SUBSTATION ONE-LINE DIAGRAM
- RELAY PANEL 5 WIRING DIAGRAM
- VENDOR BKR D-101 THREE LINE DIAGRAM
- VENDOR BKR D-103 THREE LINE DIAGRAM

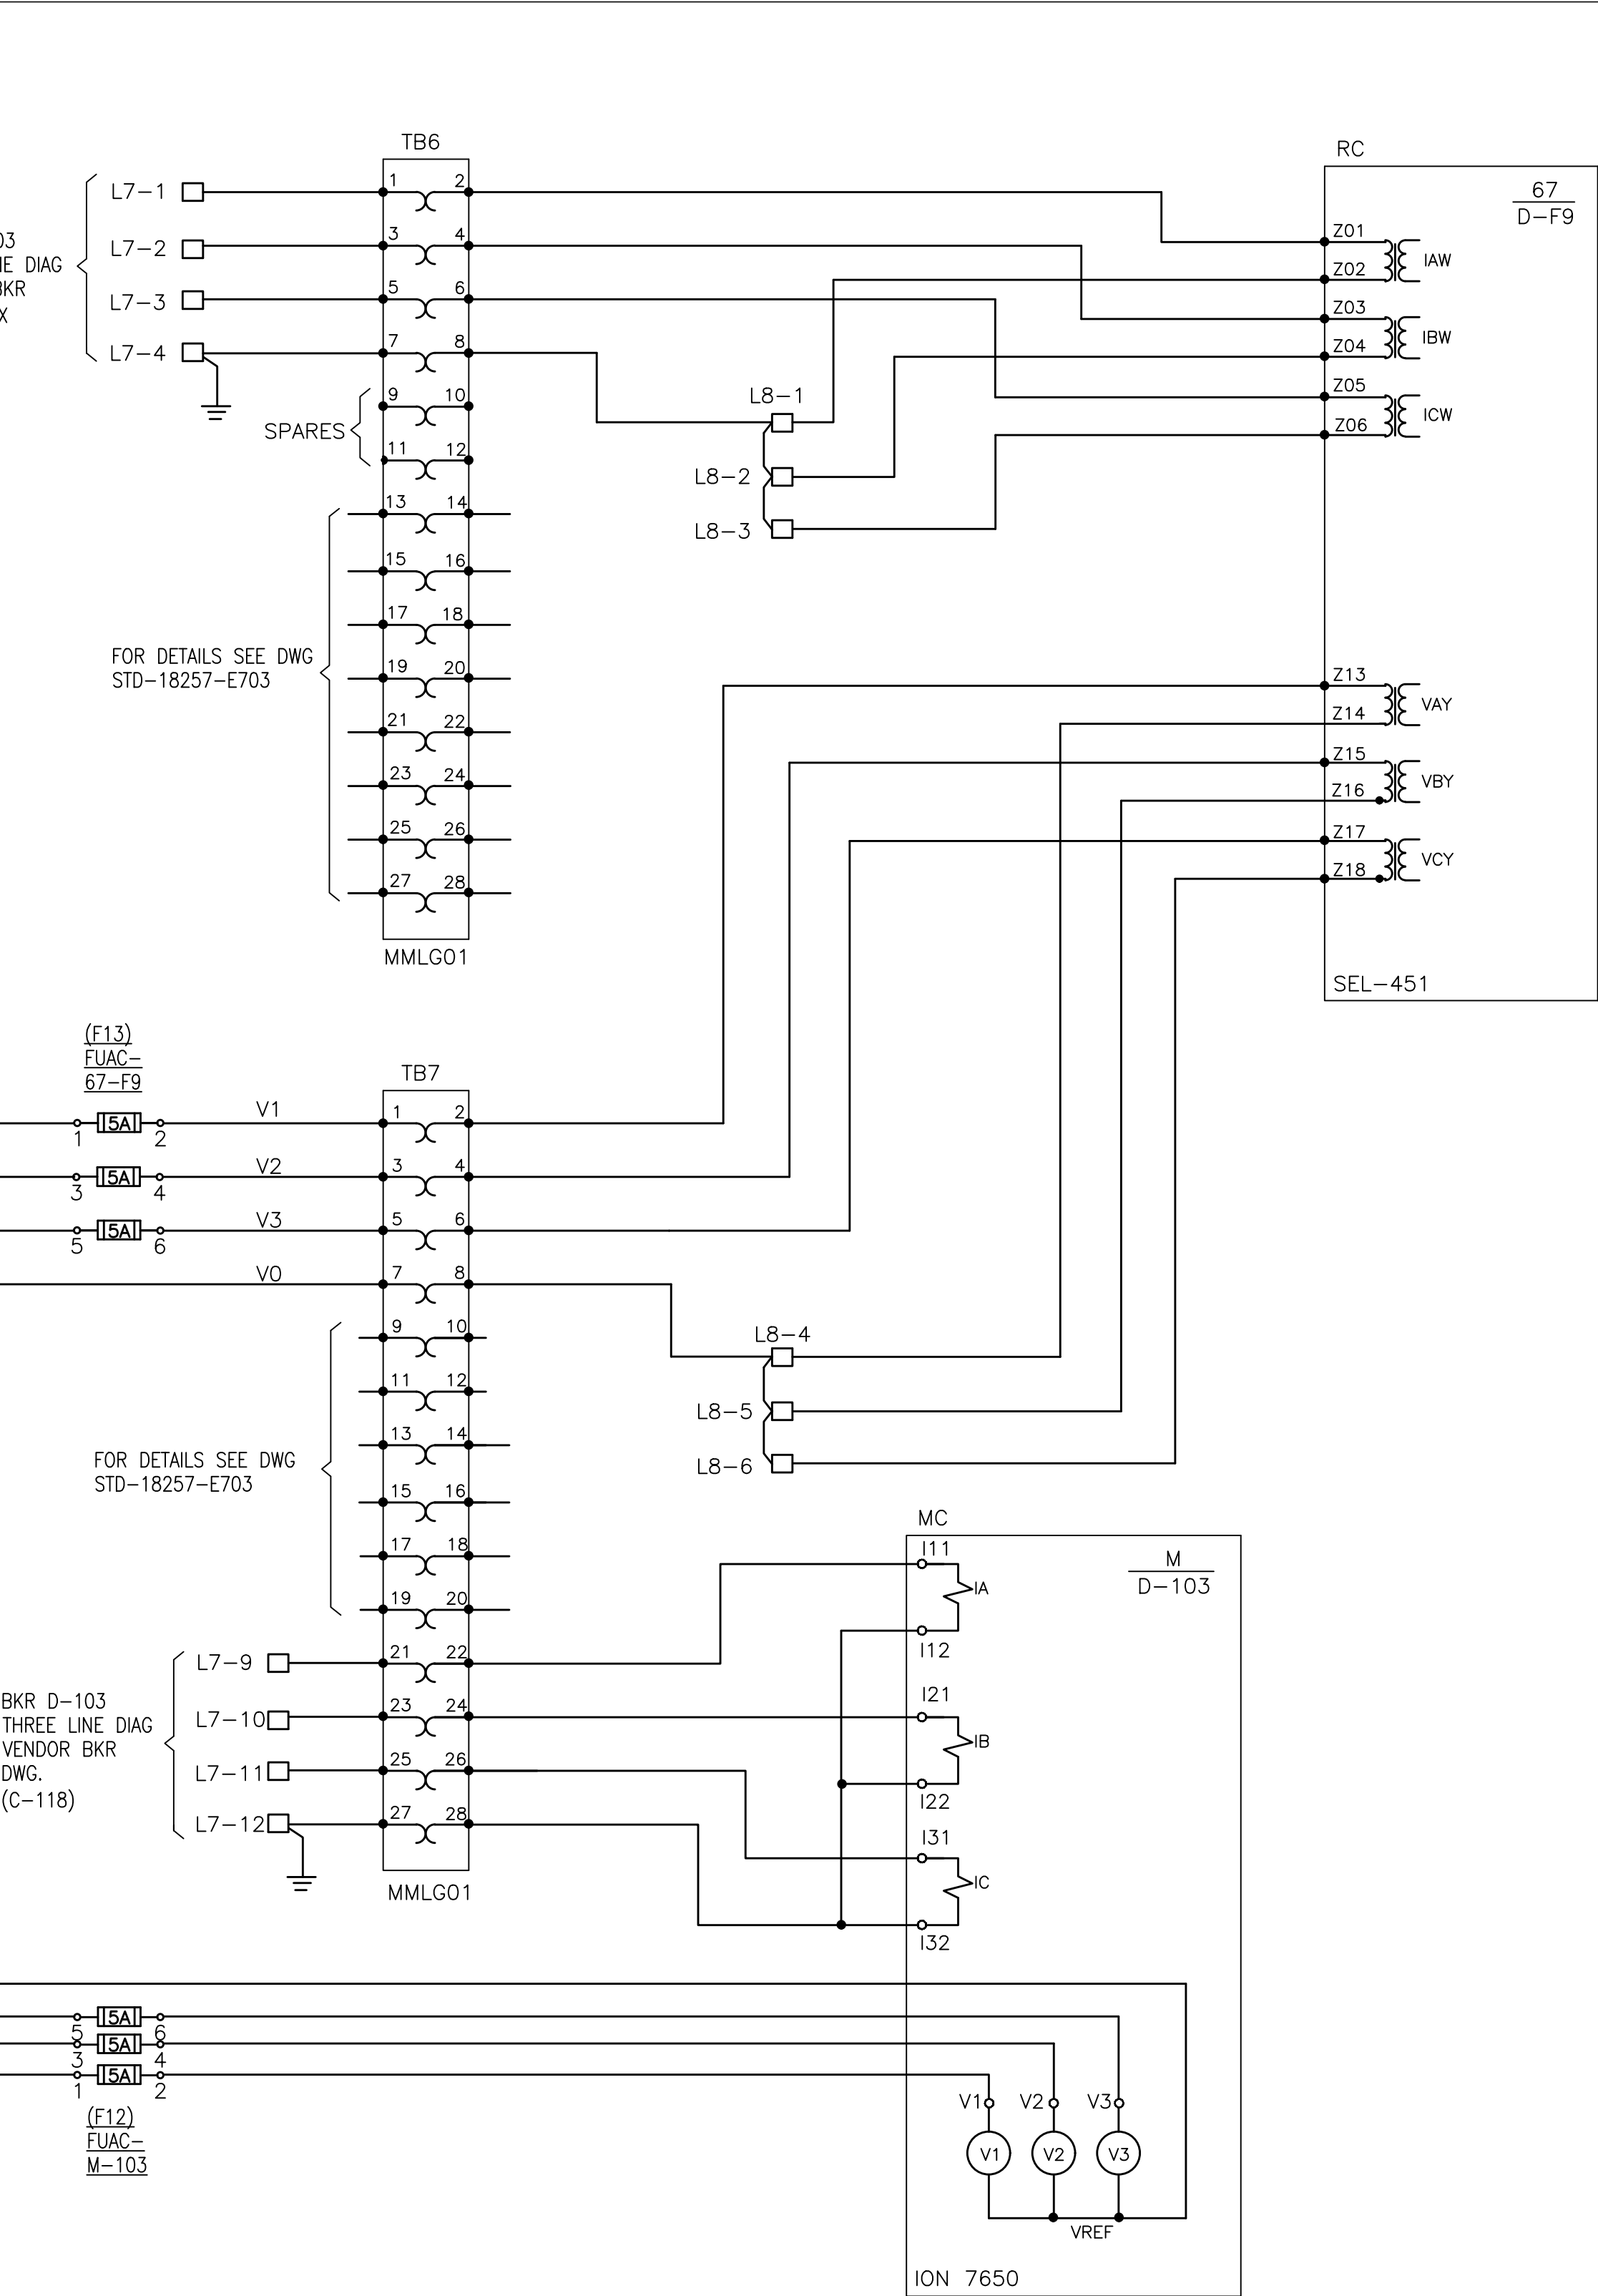

AC ELEMENTARY DIAGRAM  
D-F9

Seal:

Client:

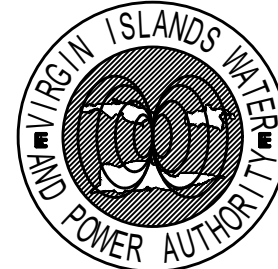

Virgin Islands  
Water and Power  
Authority  
U.S. Virgin Islands

Project Name:

East End Substation  
Restoration &  
Expansion Project  
St. Thomas, USVI  
Phase 2 (13.2kV GIS)

Issue / Revisions:

#	Date	Description
A	07.25.19	Issue for Phase 2 Bid Review
O	10.17.19	Issue for Phase 2 Bid

Drawn By:	PJB
Checked By:	PJB
Date:	10.17.19
Scale:	As Noted
Project Number:	VIT 18257



Drawing Title:  
**AC ELEMENTARY  
DIAGRAM D-FRR/D-F9  
FEEDER PROTECTION  
RELAYS  
13.2kV RP5**

Drawing Number:

**STD-18257-E-702**


Sheet Number 1 of 1  
©2019 FXB, Inc



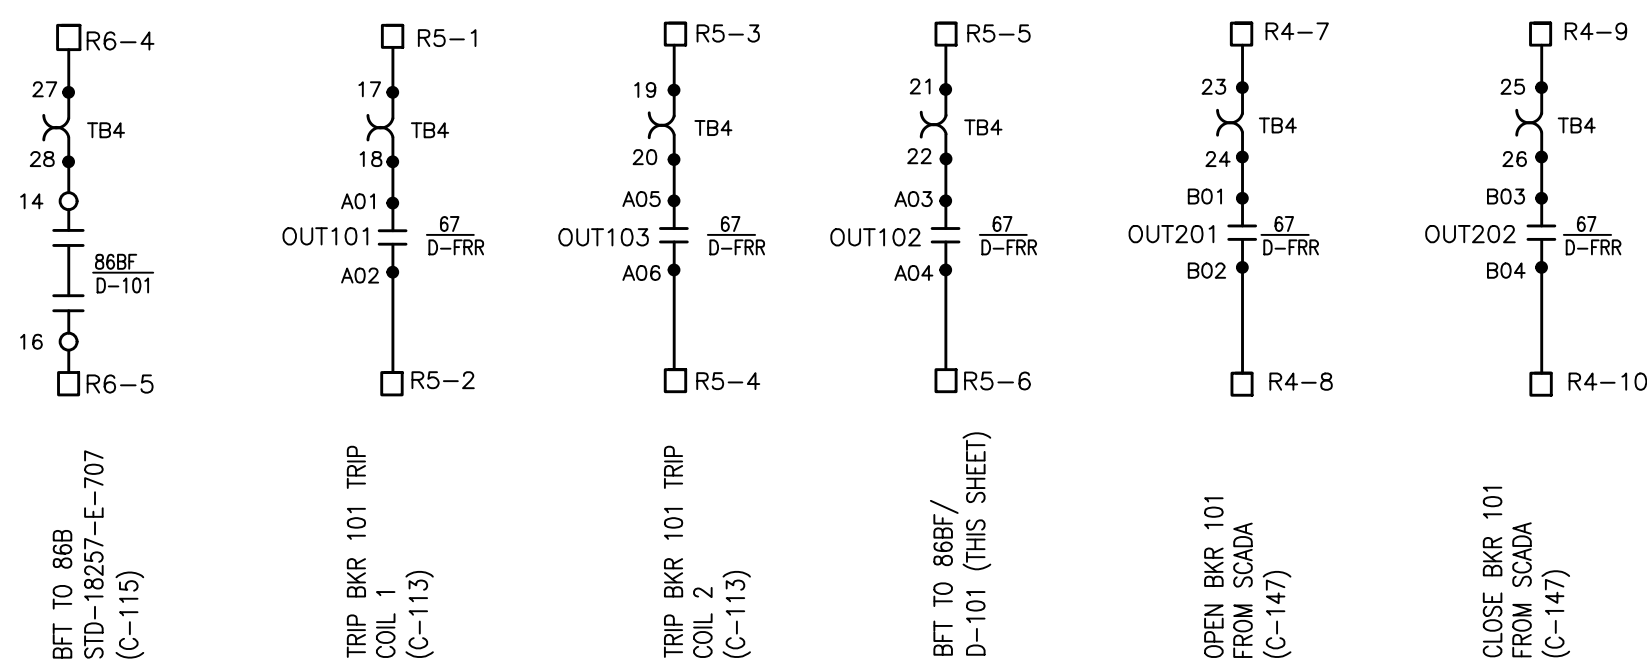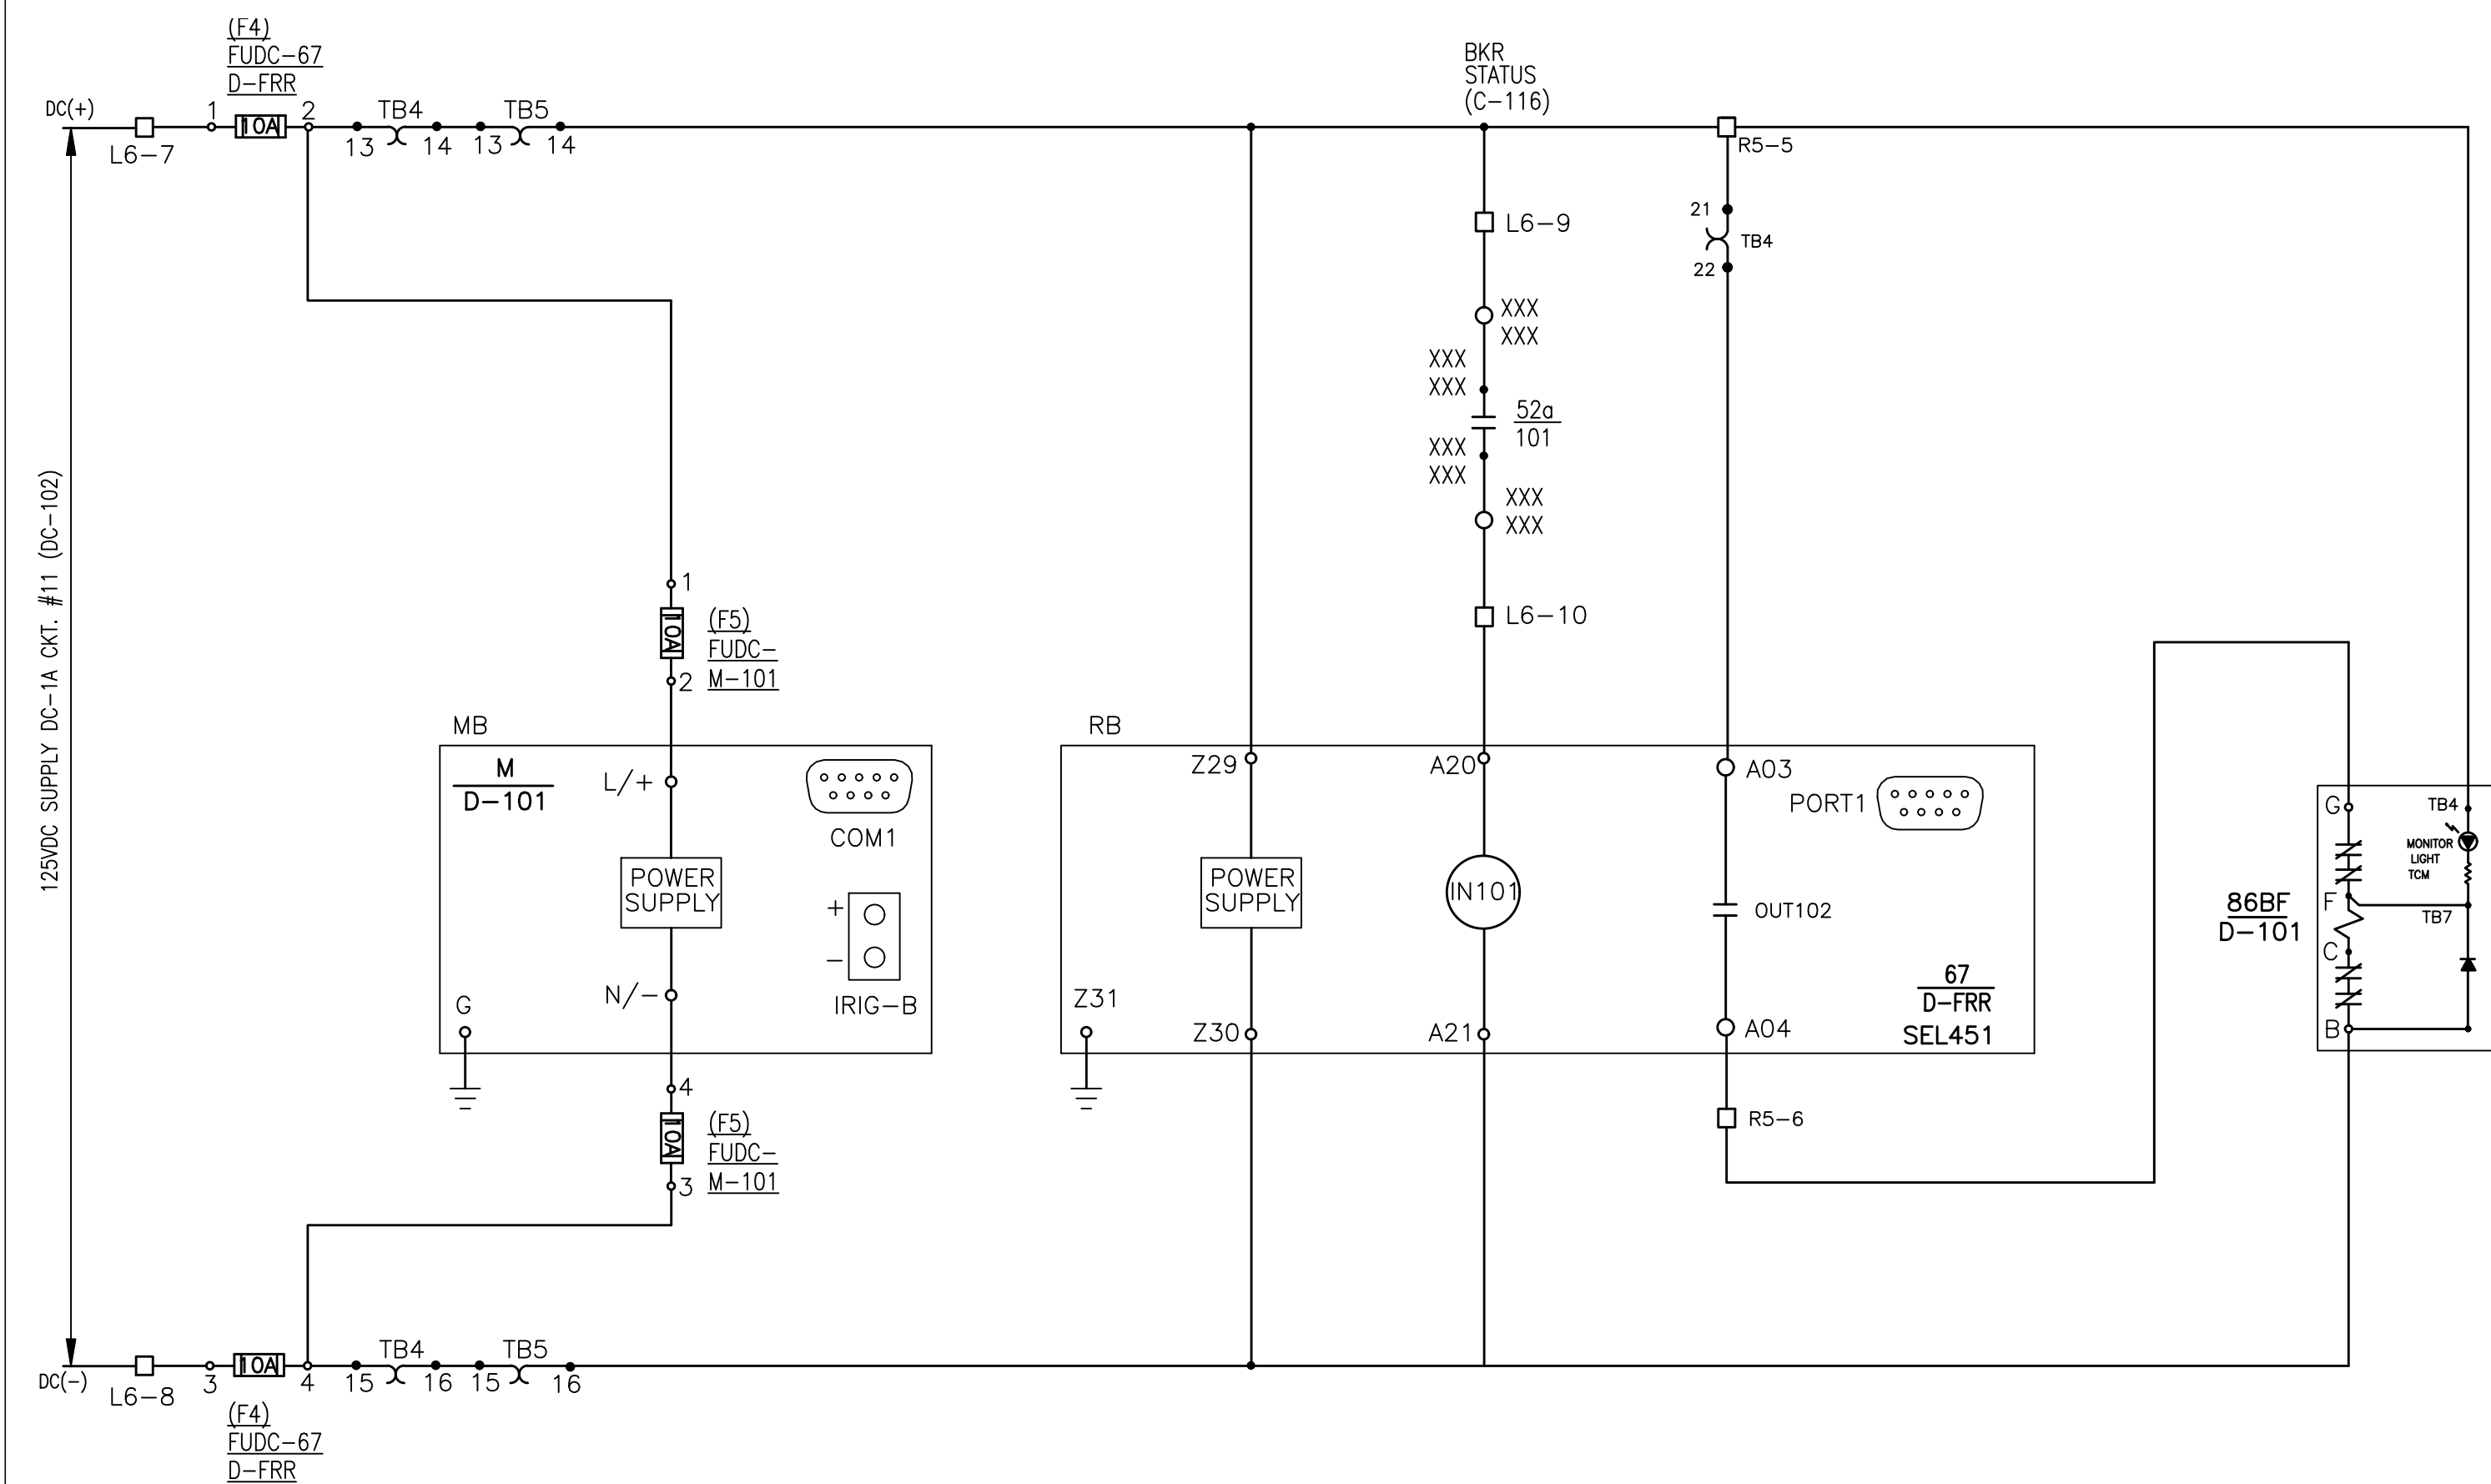


## OUTPUTS



## SCADA CONTROL

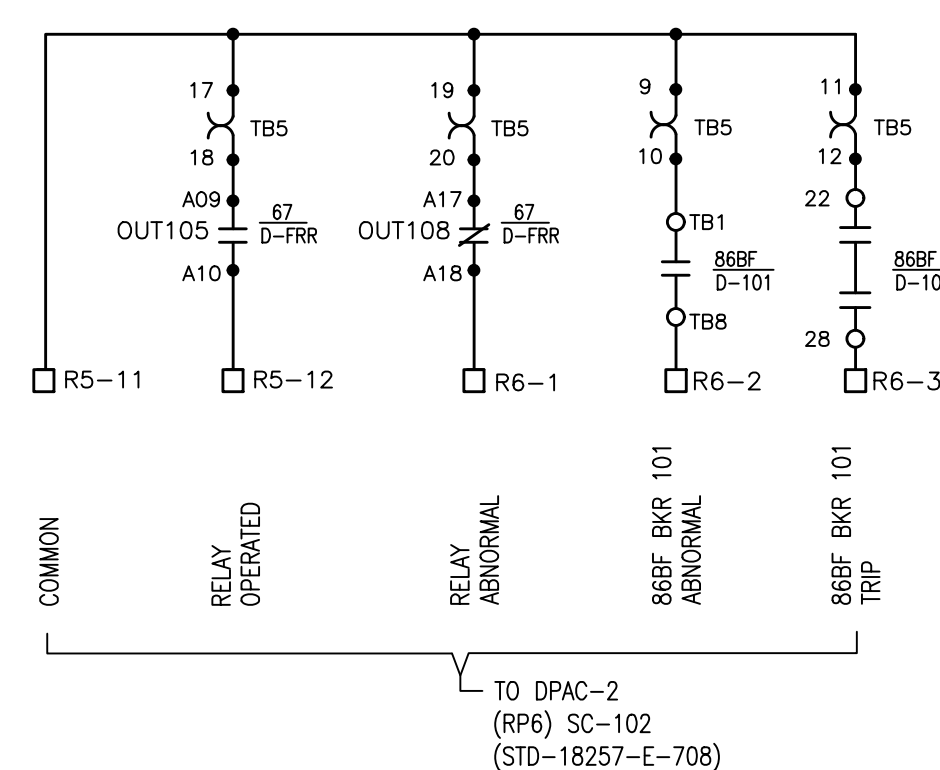

## SCADA ALARMS

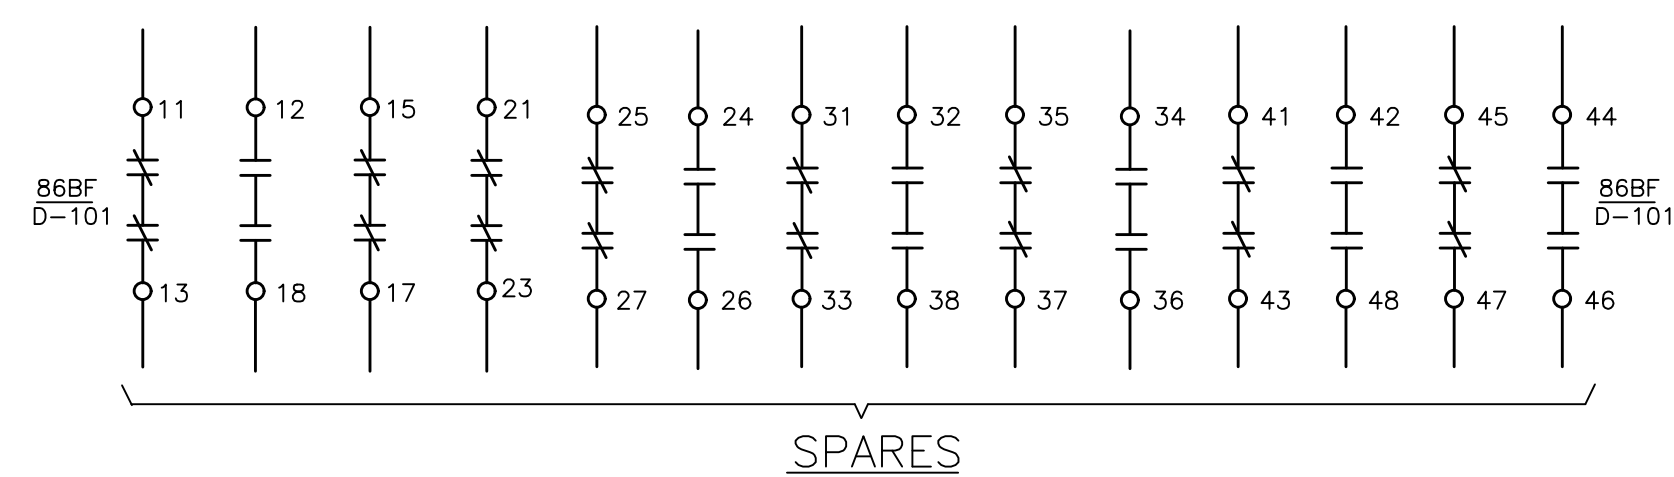
SPARES

DC ELEMENTARY DIAGRAM  
D-FRR

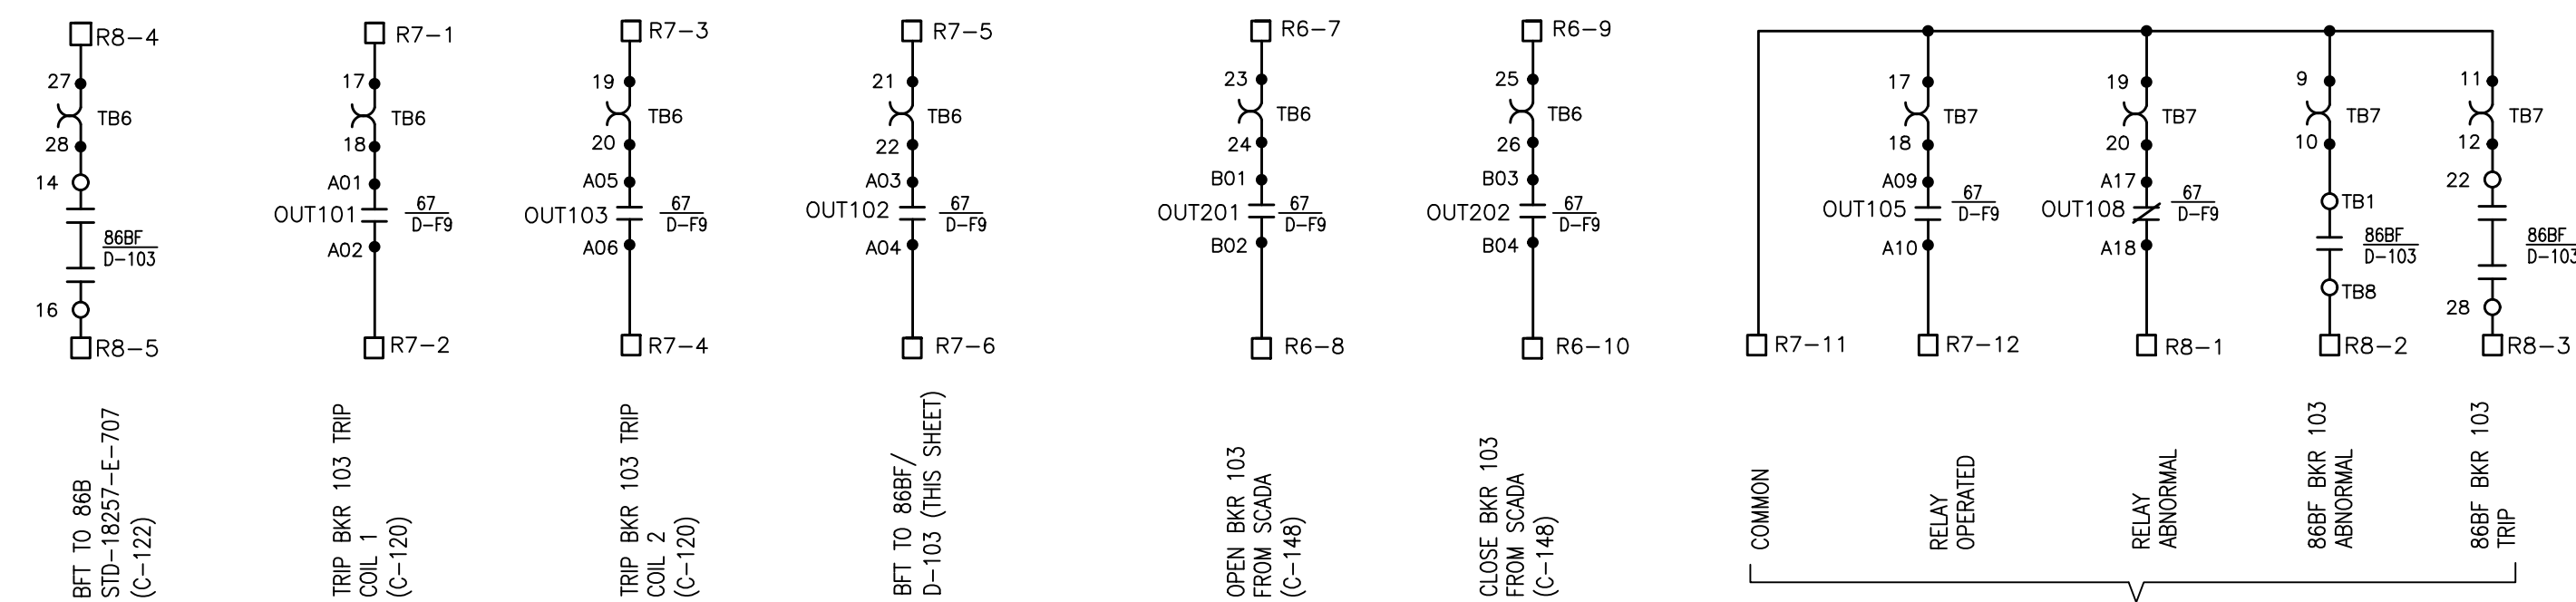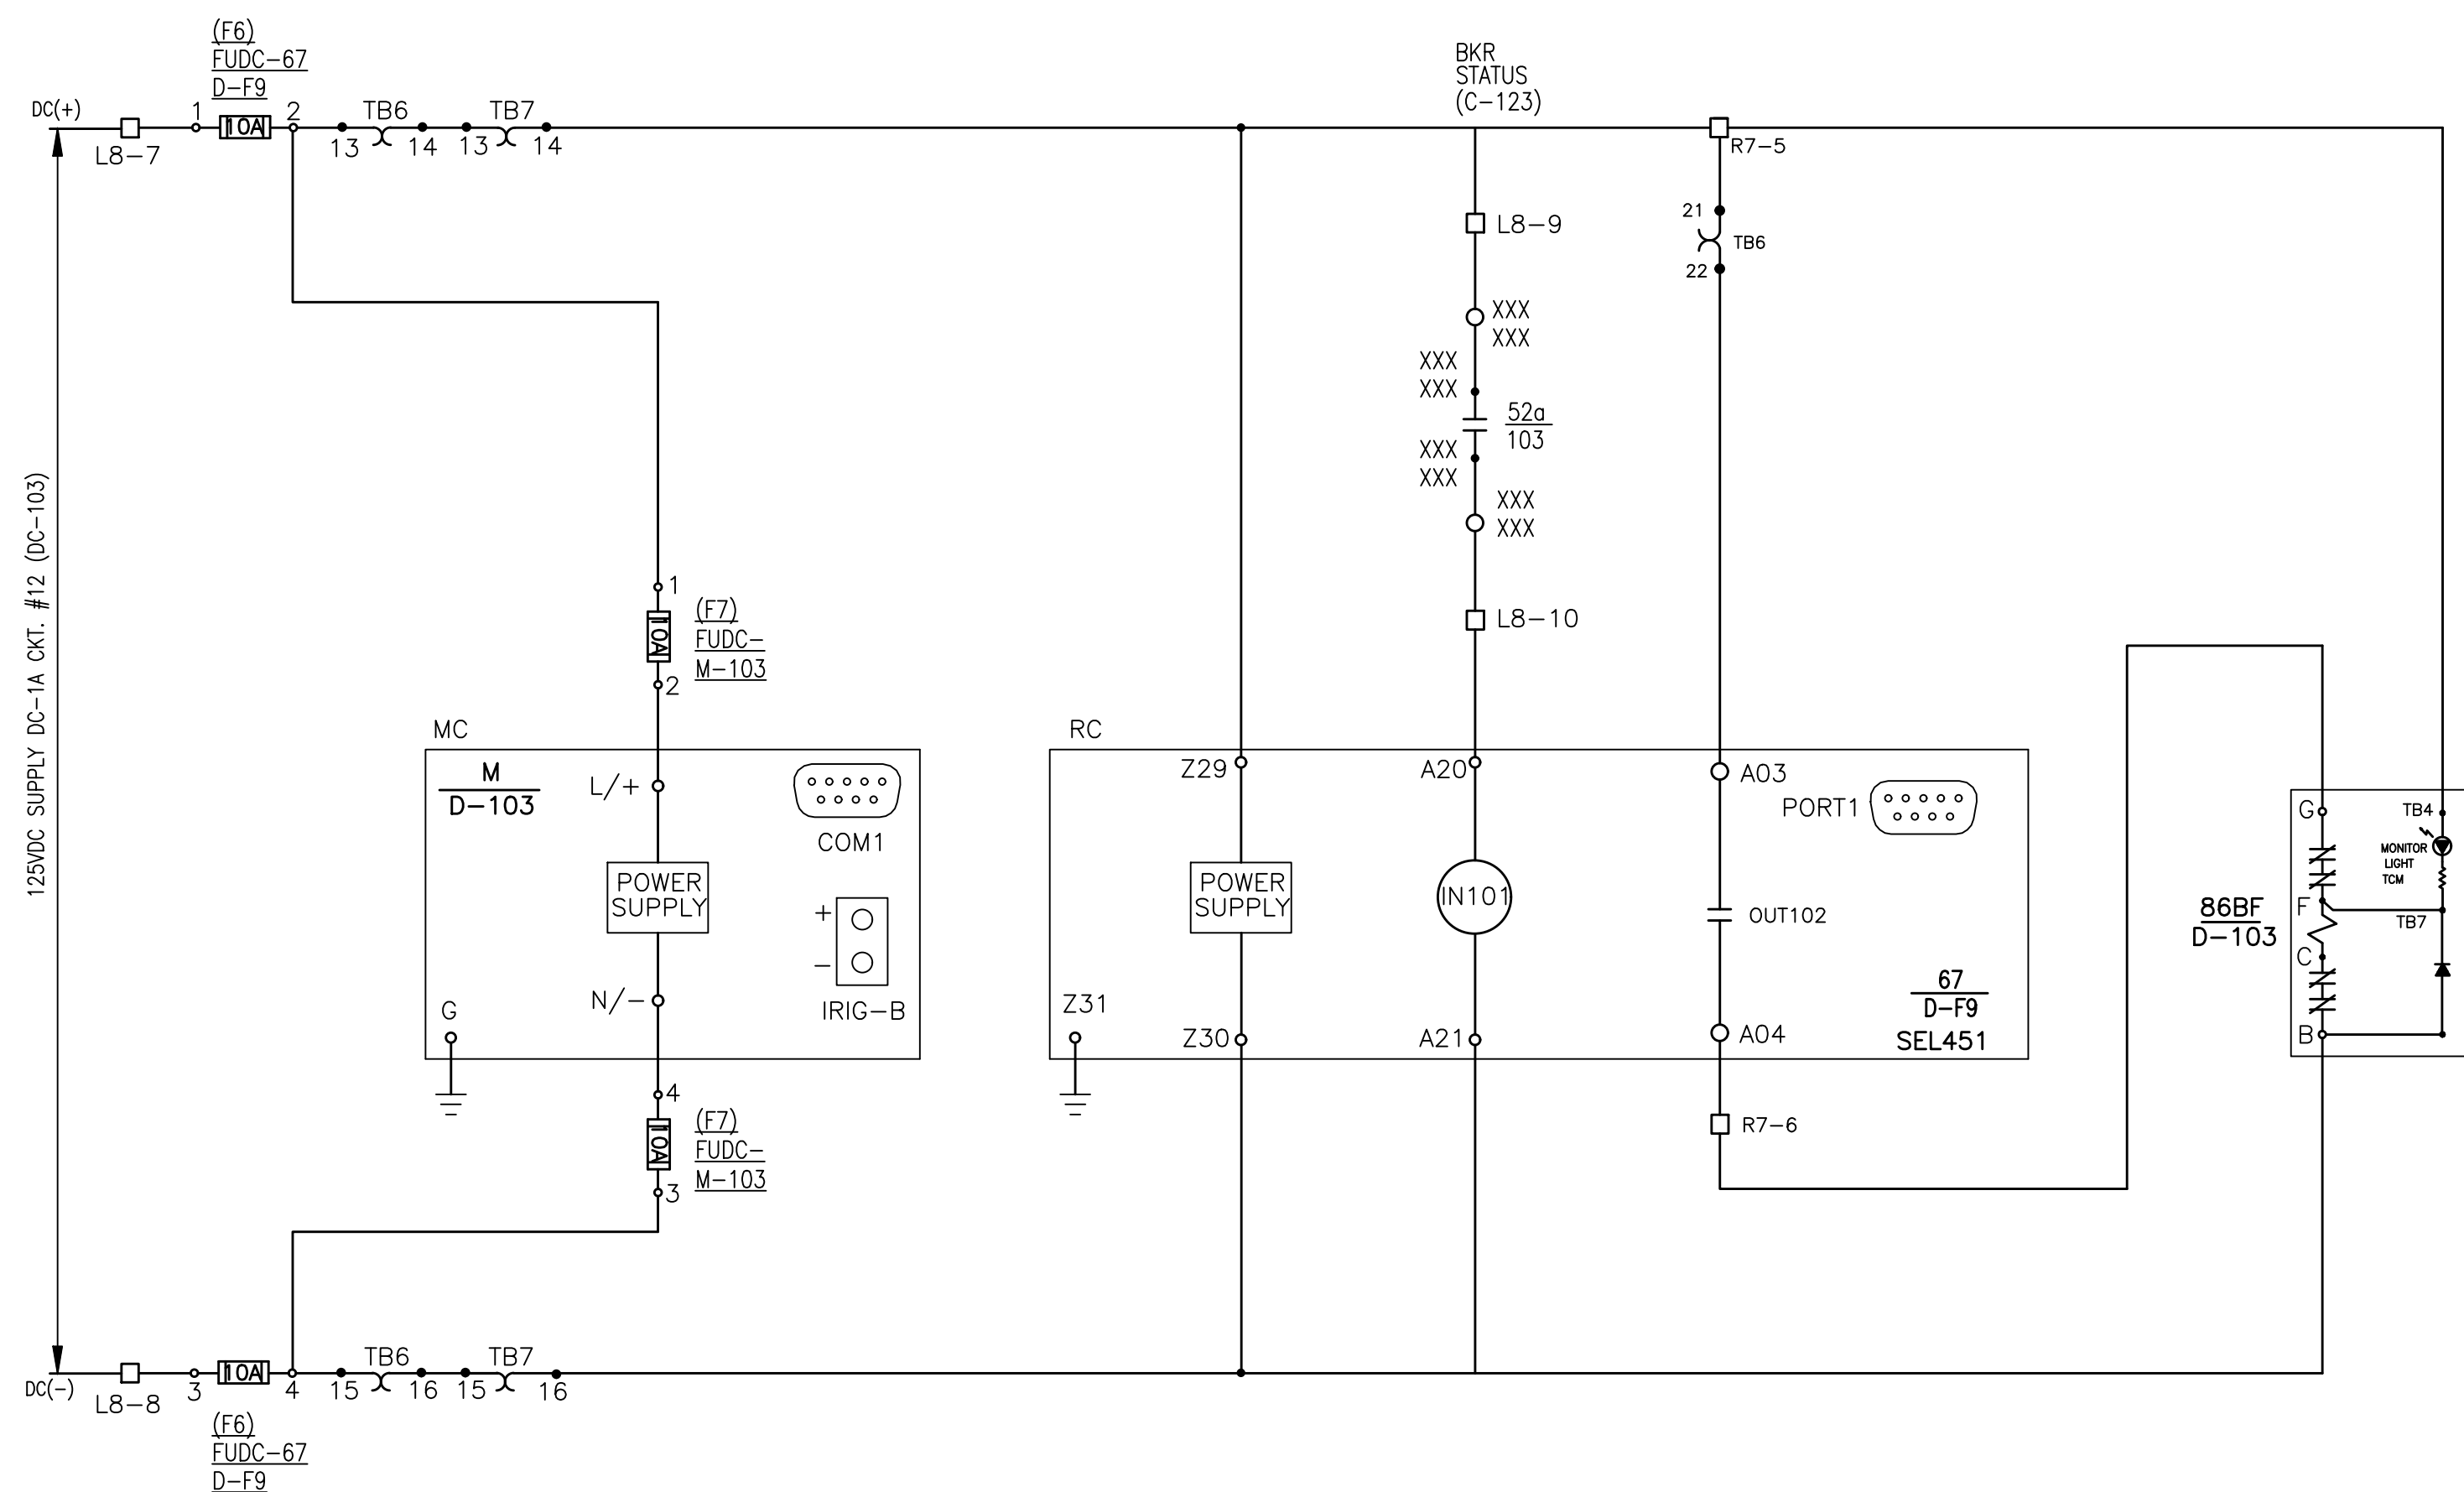


## OUTPUTS

## SCADA CONTROL

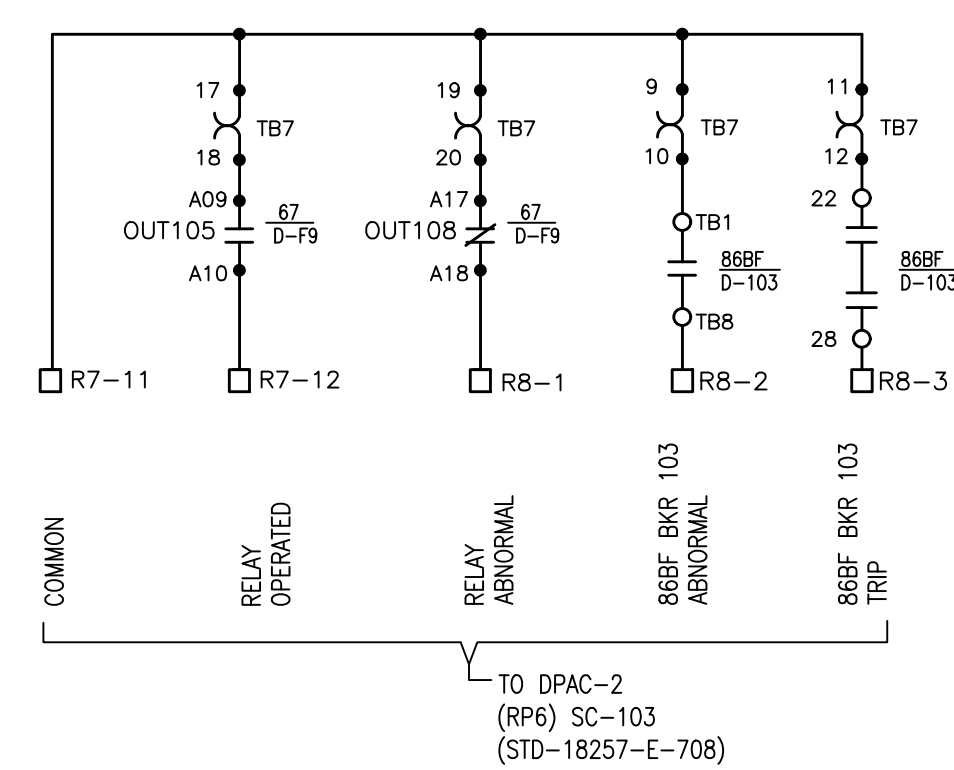

## SCADA ALARMS

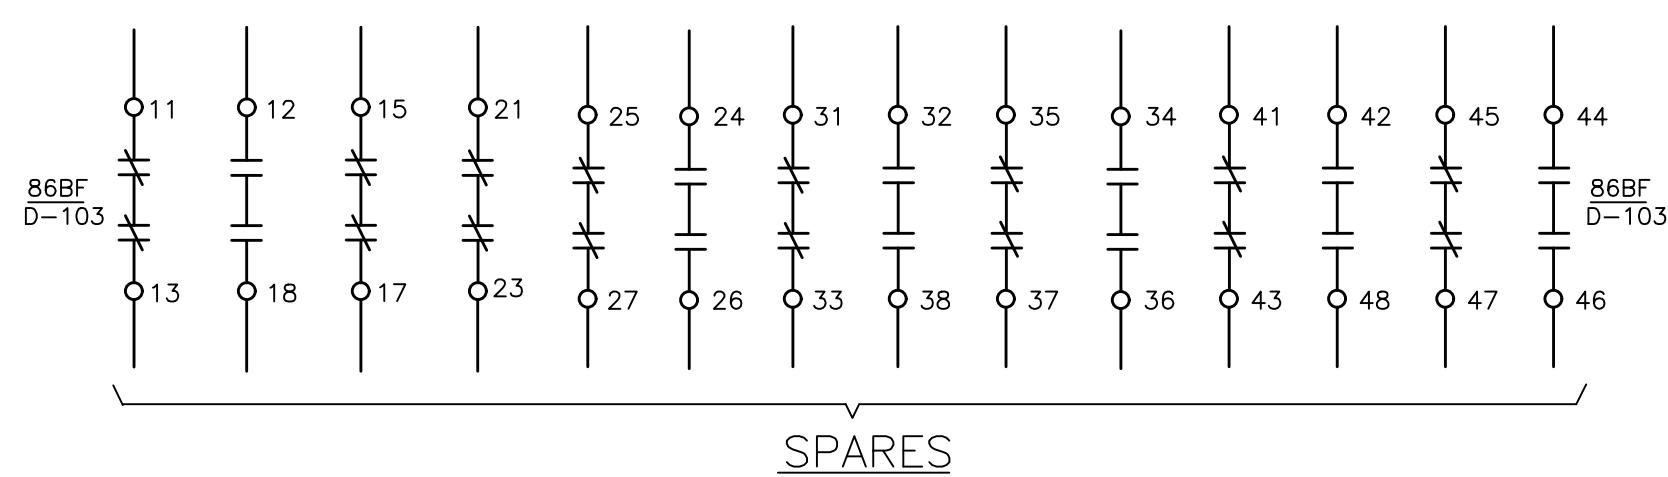SPARES

DC ELEMENTARY DIAGRAM  
D-F9


### LEGEND

67	DIRECTIONAL OVERCURRENT RELAY
TB1	TEST BLOCK & NUMBER
BKR	POWER CIRCUIT BREAKER
<input type="checkbox"/>	LOCATED IN RELAY PANEL 5
<input type="radio"/>	LOCATED AT 13.2KV GIS

## REFERENCE DRAWINGS

34.5/13.2kV SUBSTATION ONE-LINE DIAGRAM  
RELAY PANEL 5 WIRING DIAGRAM  
DC ELEMENTARY DIAGRAM 13.2kV BUS DIFFERENTIAL PROTECTION  
DC ELEMENTARY DIAGRAM DPAC-2  
VENDOR BKR D-101 THREE LINE DIAGRAM  
VENDOR BKR D-103 THREE LINE DIAGRAM

STD-18257-E-600  
STD-18257-E-710  
STD-18257-E-707  
STD-18257-E-708  
XXXXXXXXXXXX  
XXXXXXXXXXXX

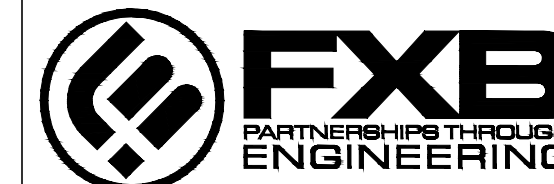


5 Christy Drive, Suite 307  
Chadds Ford, PA 19317  
610.558.3464 office  
www.fxbinc.com

Engineering Excellence Since 1968

Sea

Client

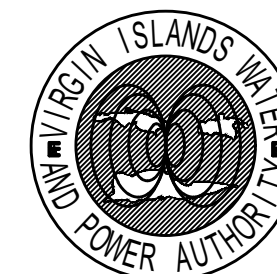

Virgin Islands  
Water and Power  
Authority  
U.S. Virgin Islands

Project Name

East End Substation  
Restoration &  
Expansion Project  
St. Thomas, USVI  
Phase 2 (13.2kV GIS)

[illegible]

Drawn By: P 10

Chk'd By: \_\_\_\_\_

Date: 10.17.15

Scale:	10.17.15
--------	----------

Project Number:	AS Notes
-----------------	----------

VII 1825

Drawing Title:

DC ELEMENTARY  
DIAGRAM D-FRR/D-F9  
FEEDER PROTECTION  
RELAYS  
13.2kV RP5

Drawing Number




STD-18257-E-703

Sheet Number 1 of 1




© 2019 FXB, Inc





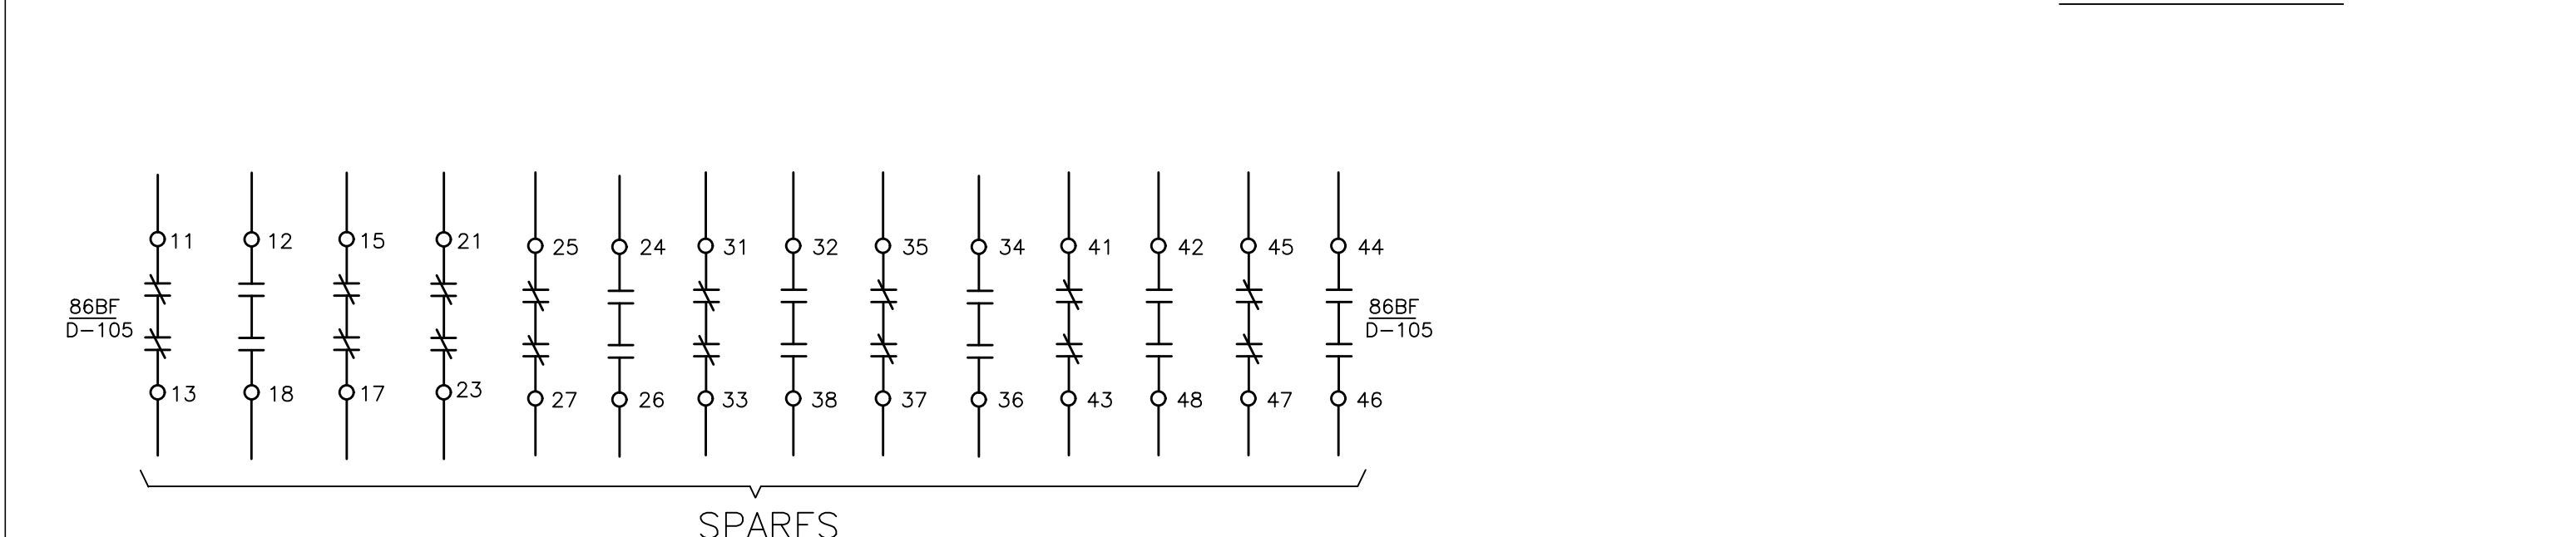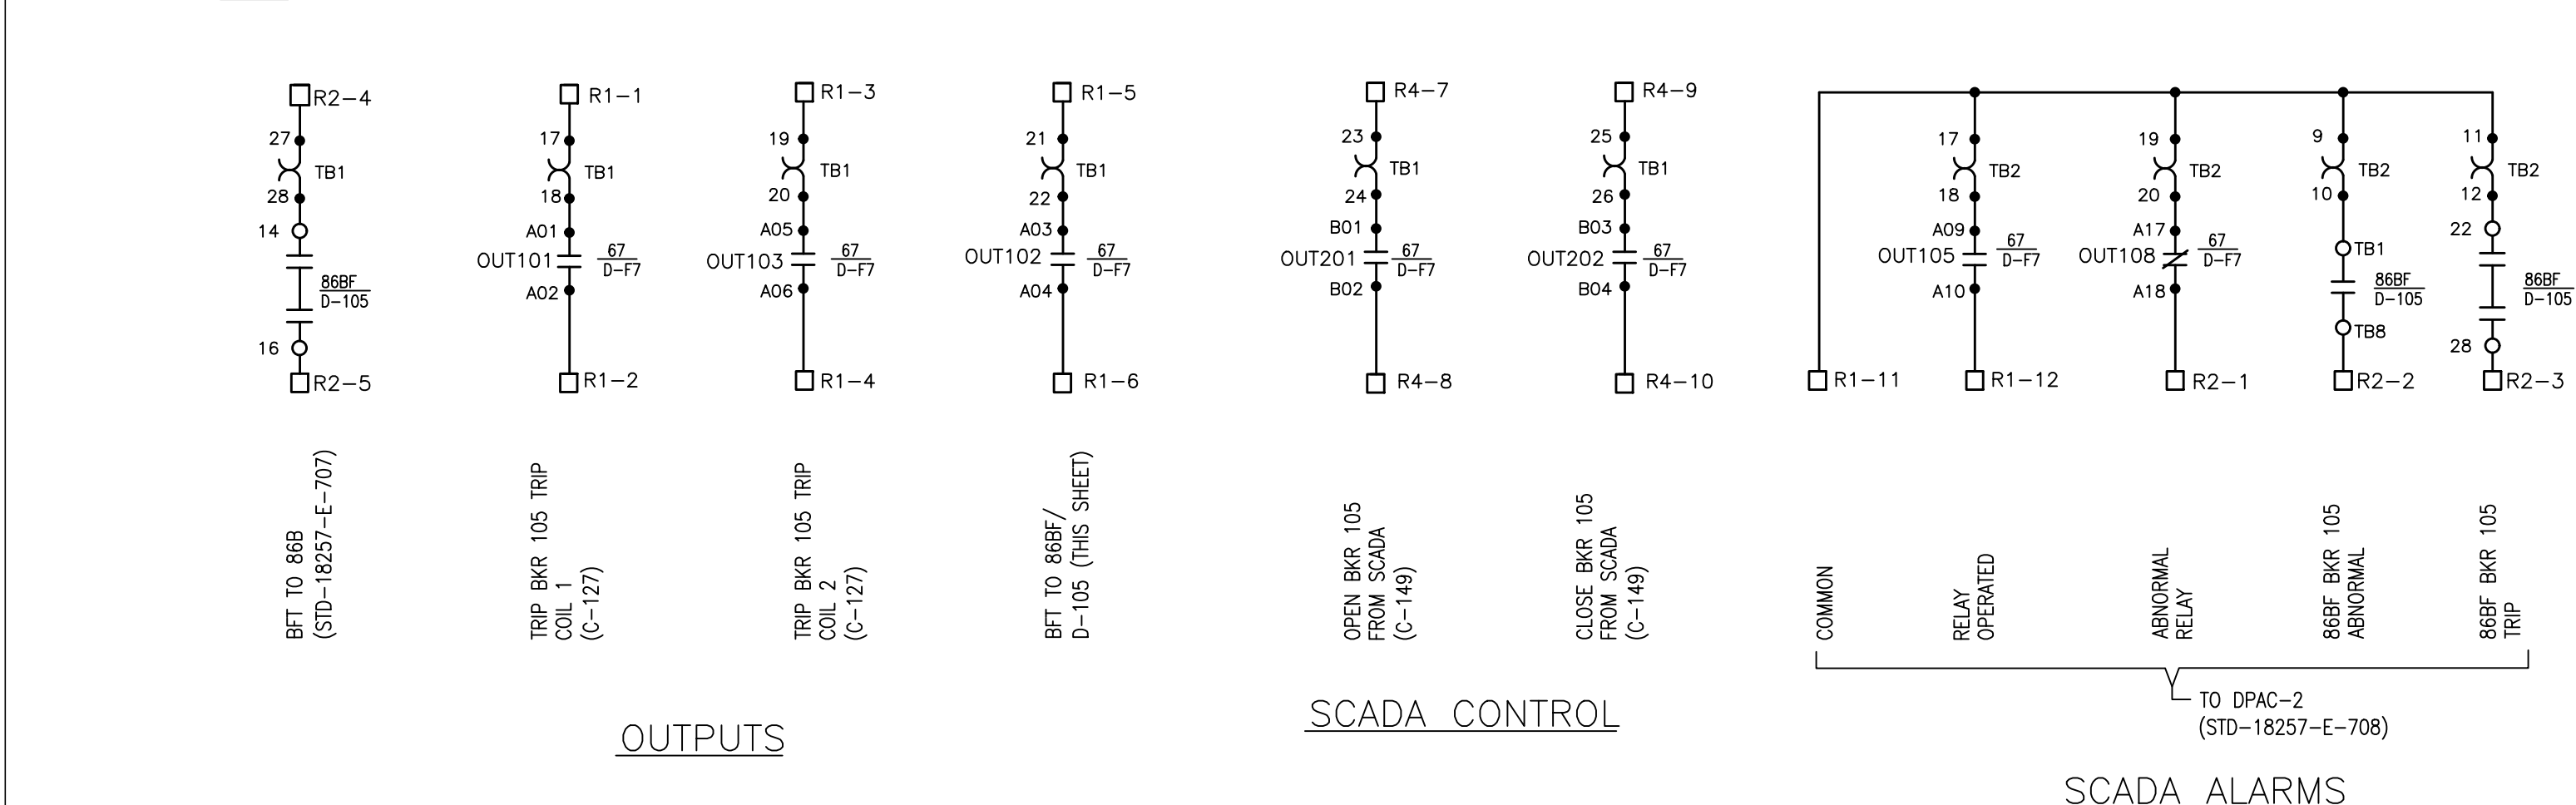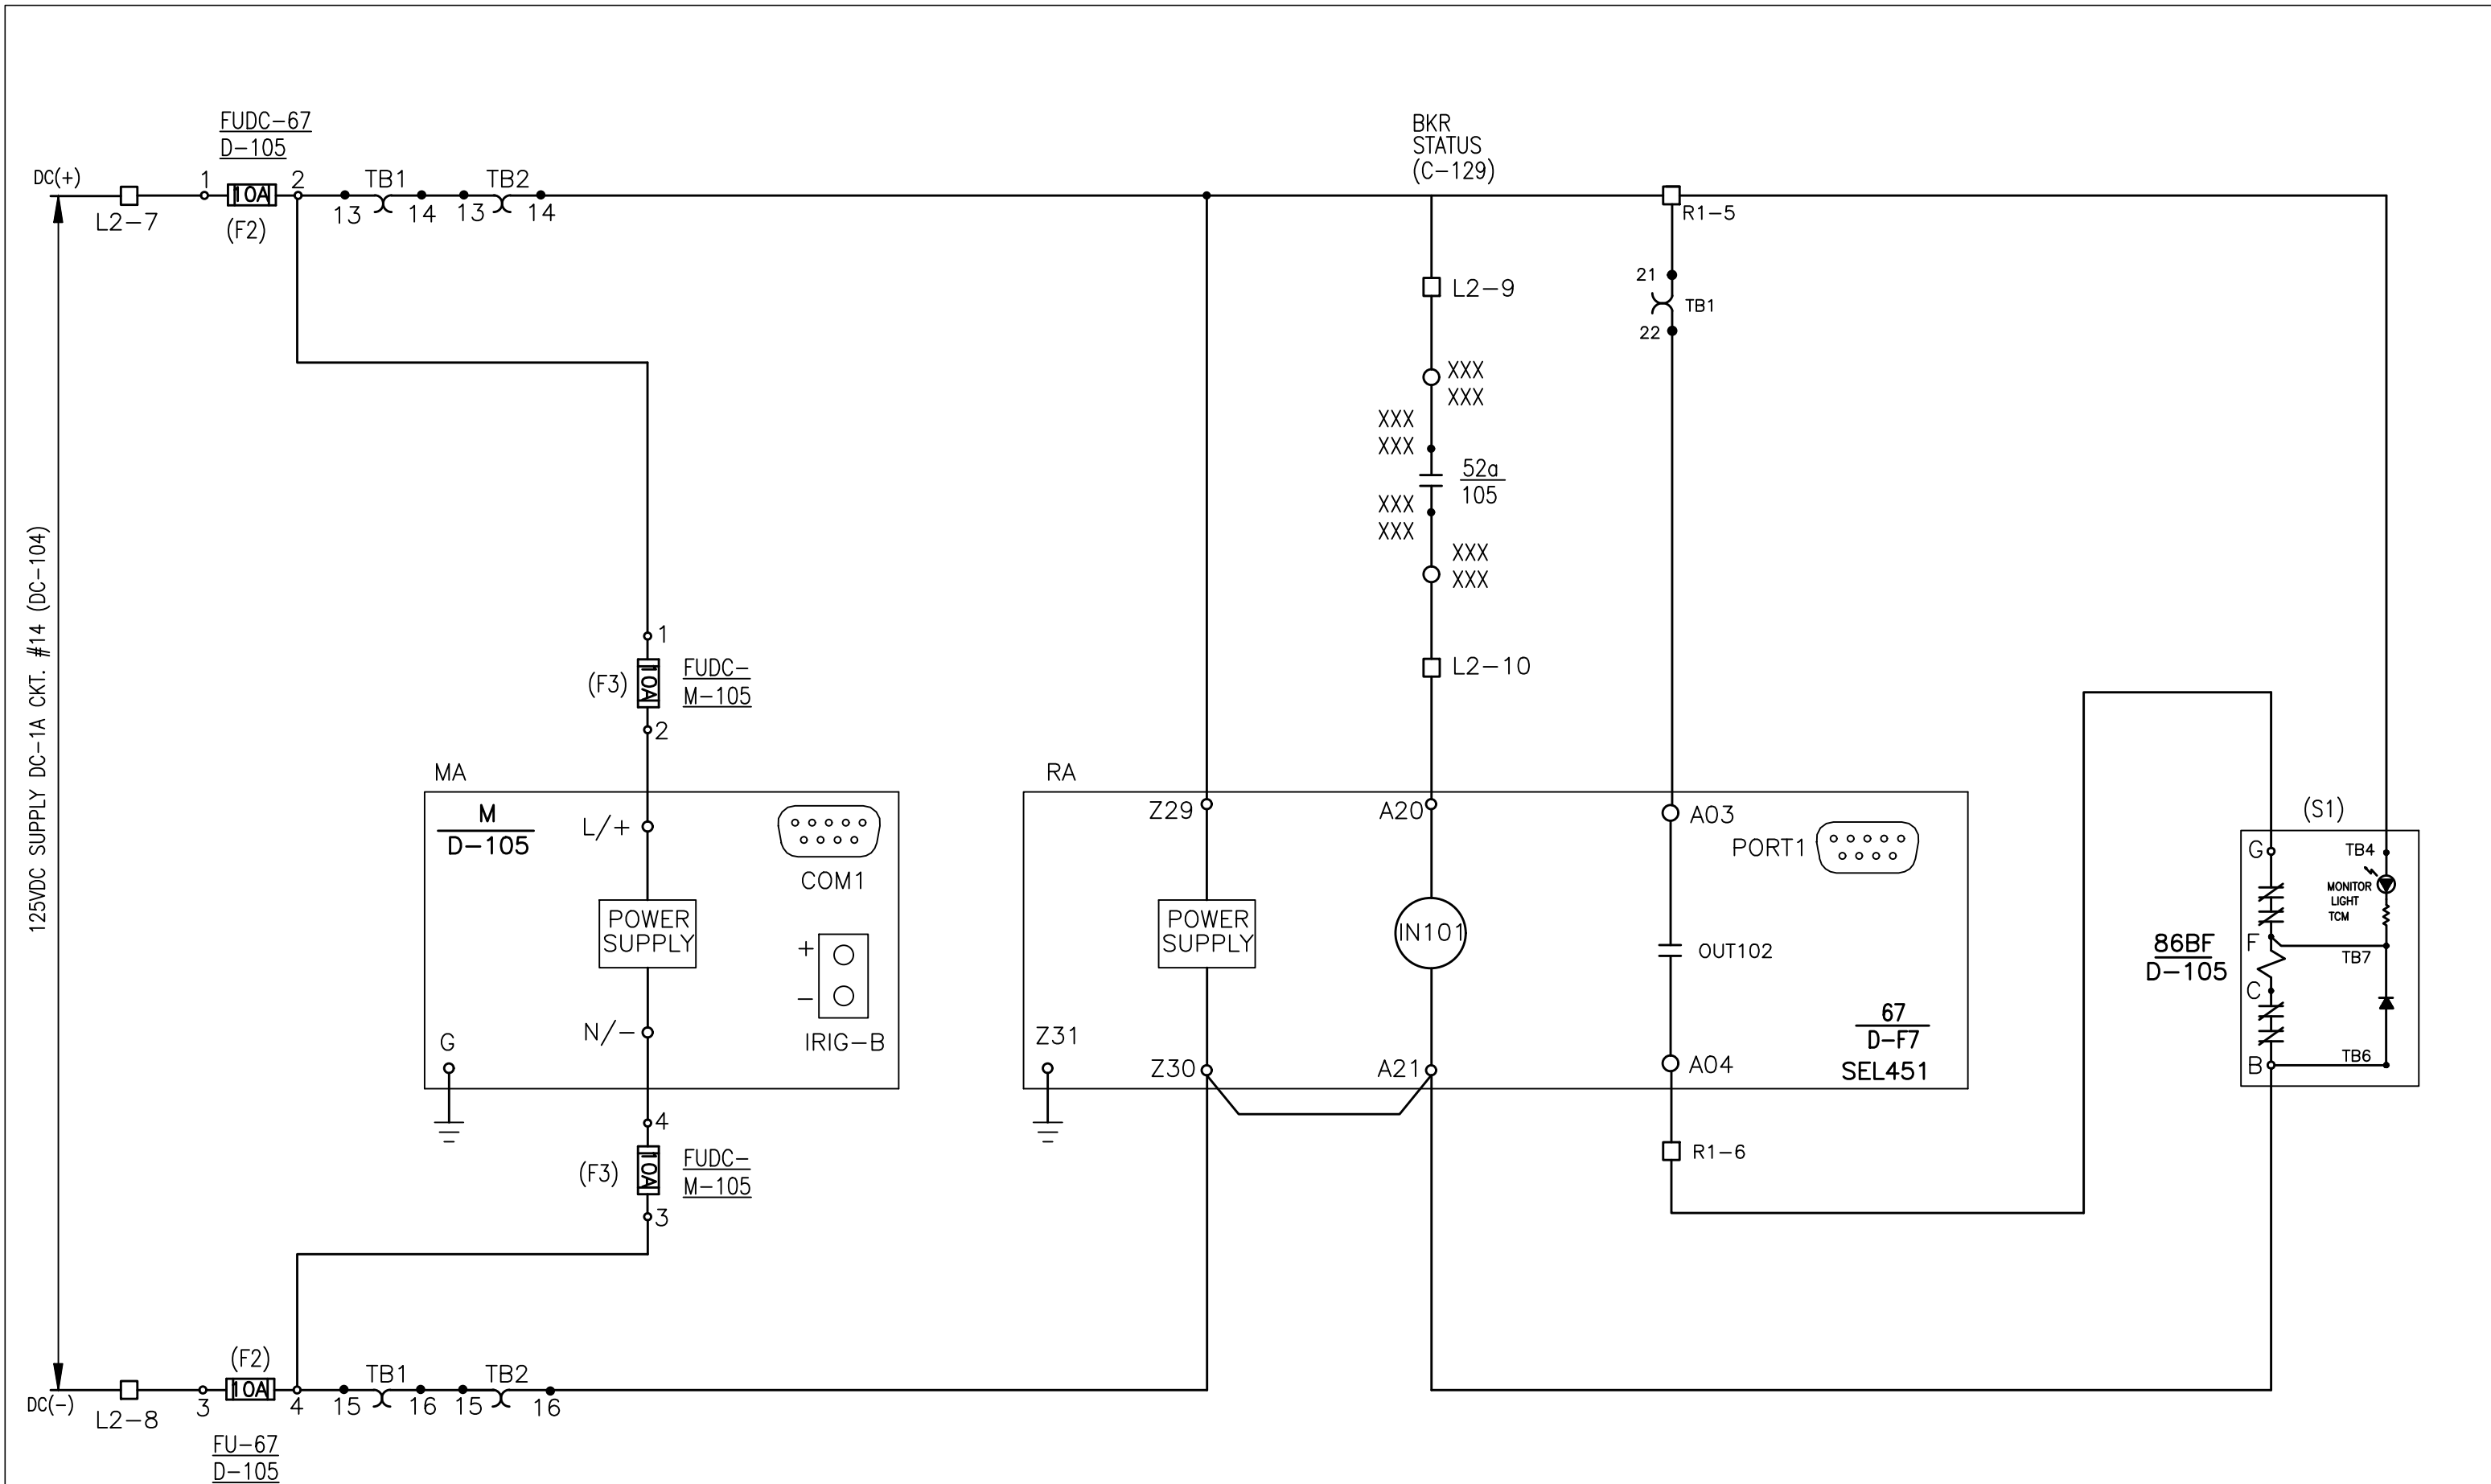

DC ELEMENTARY DIAGRAM  
D-F7

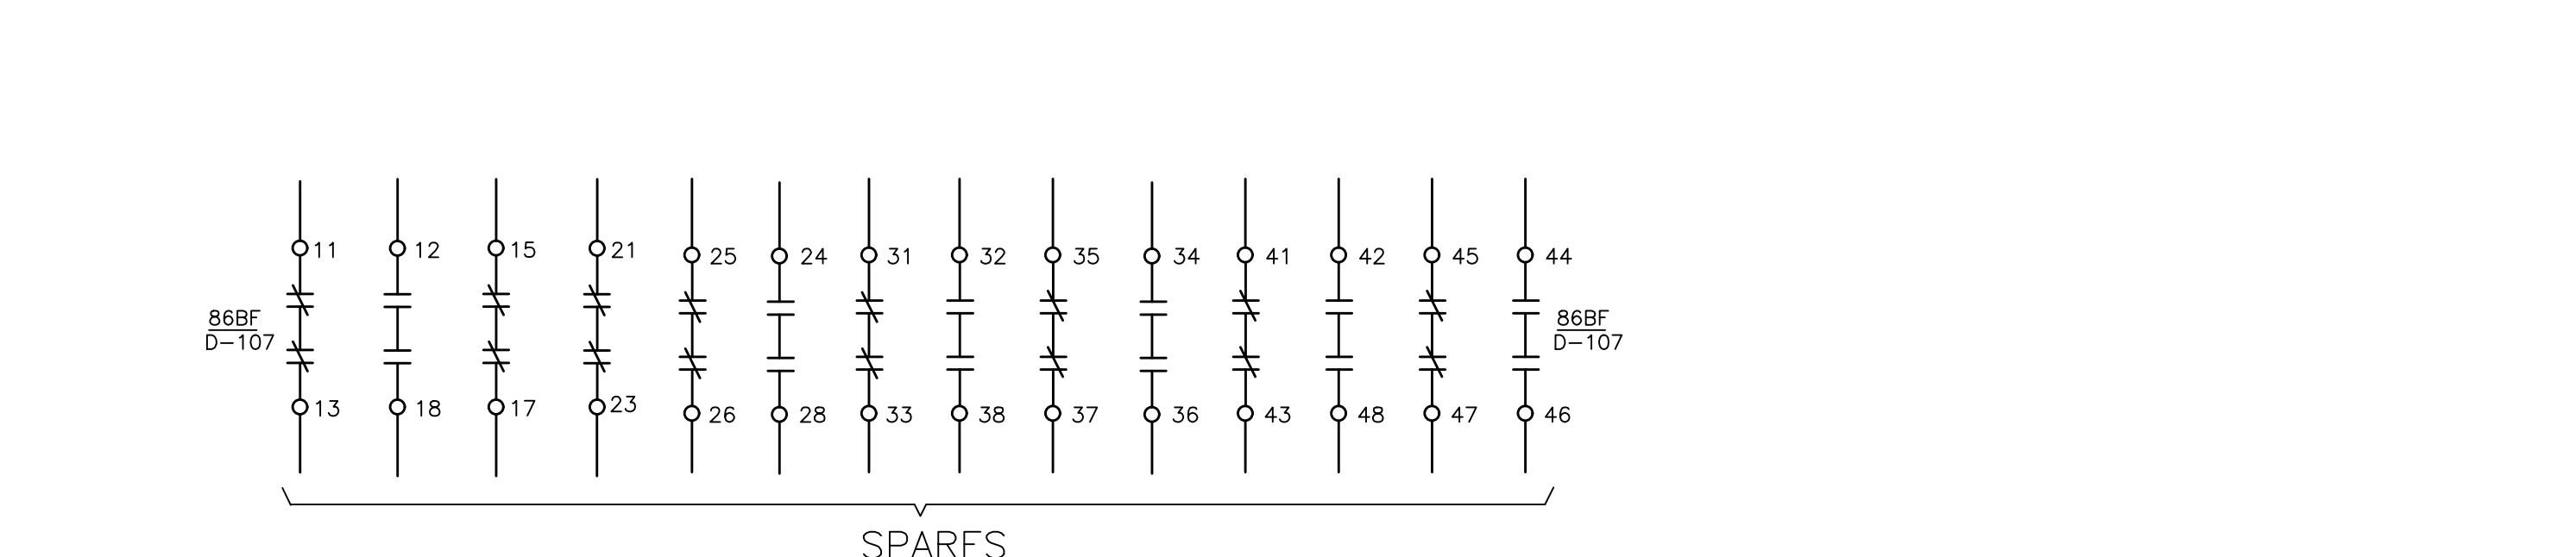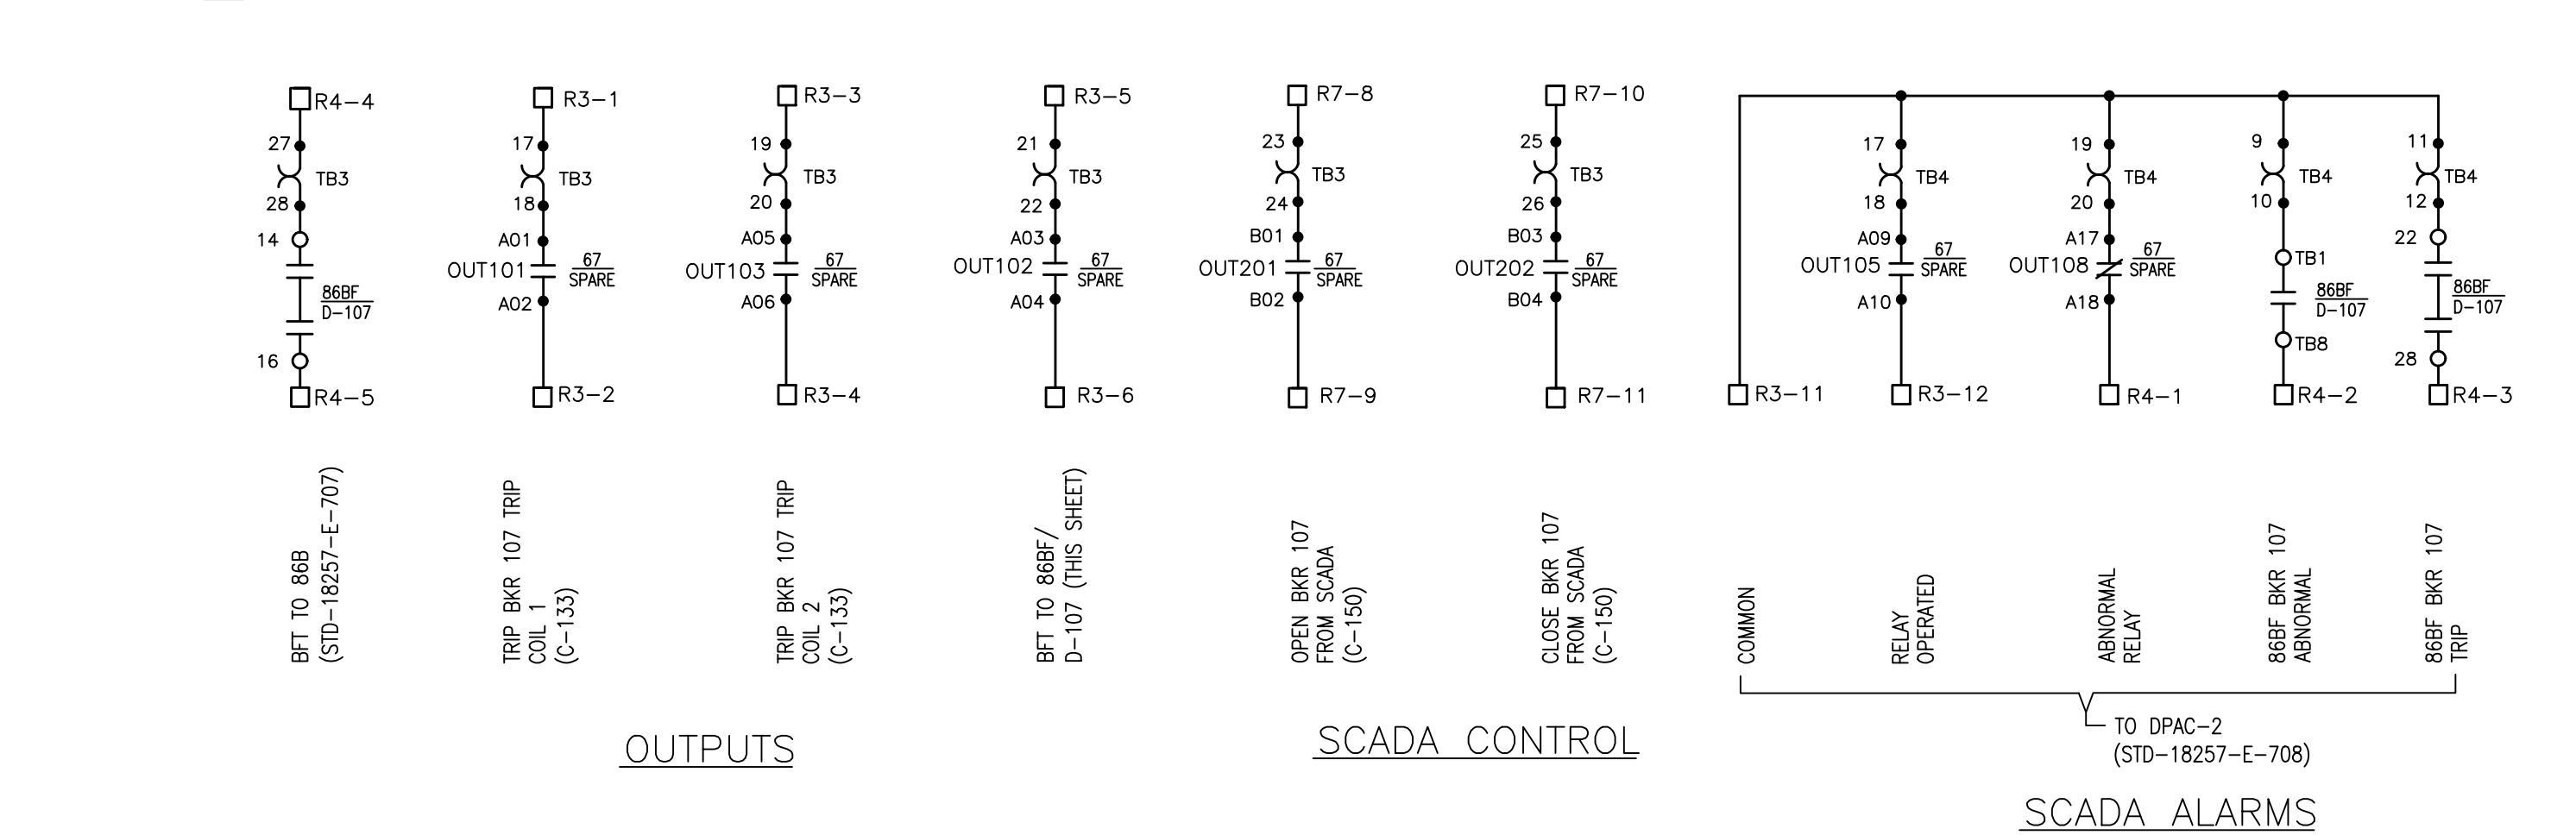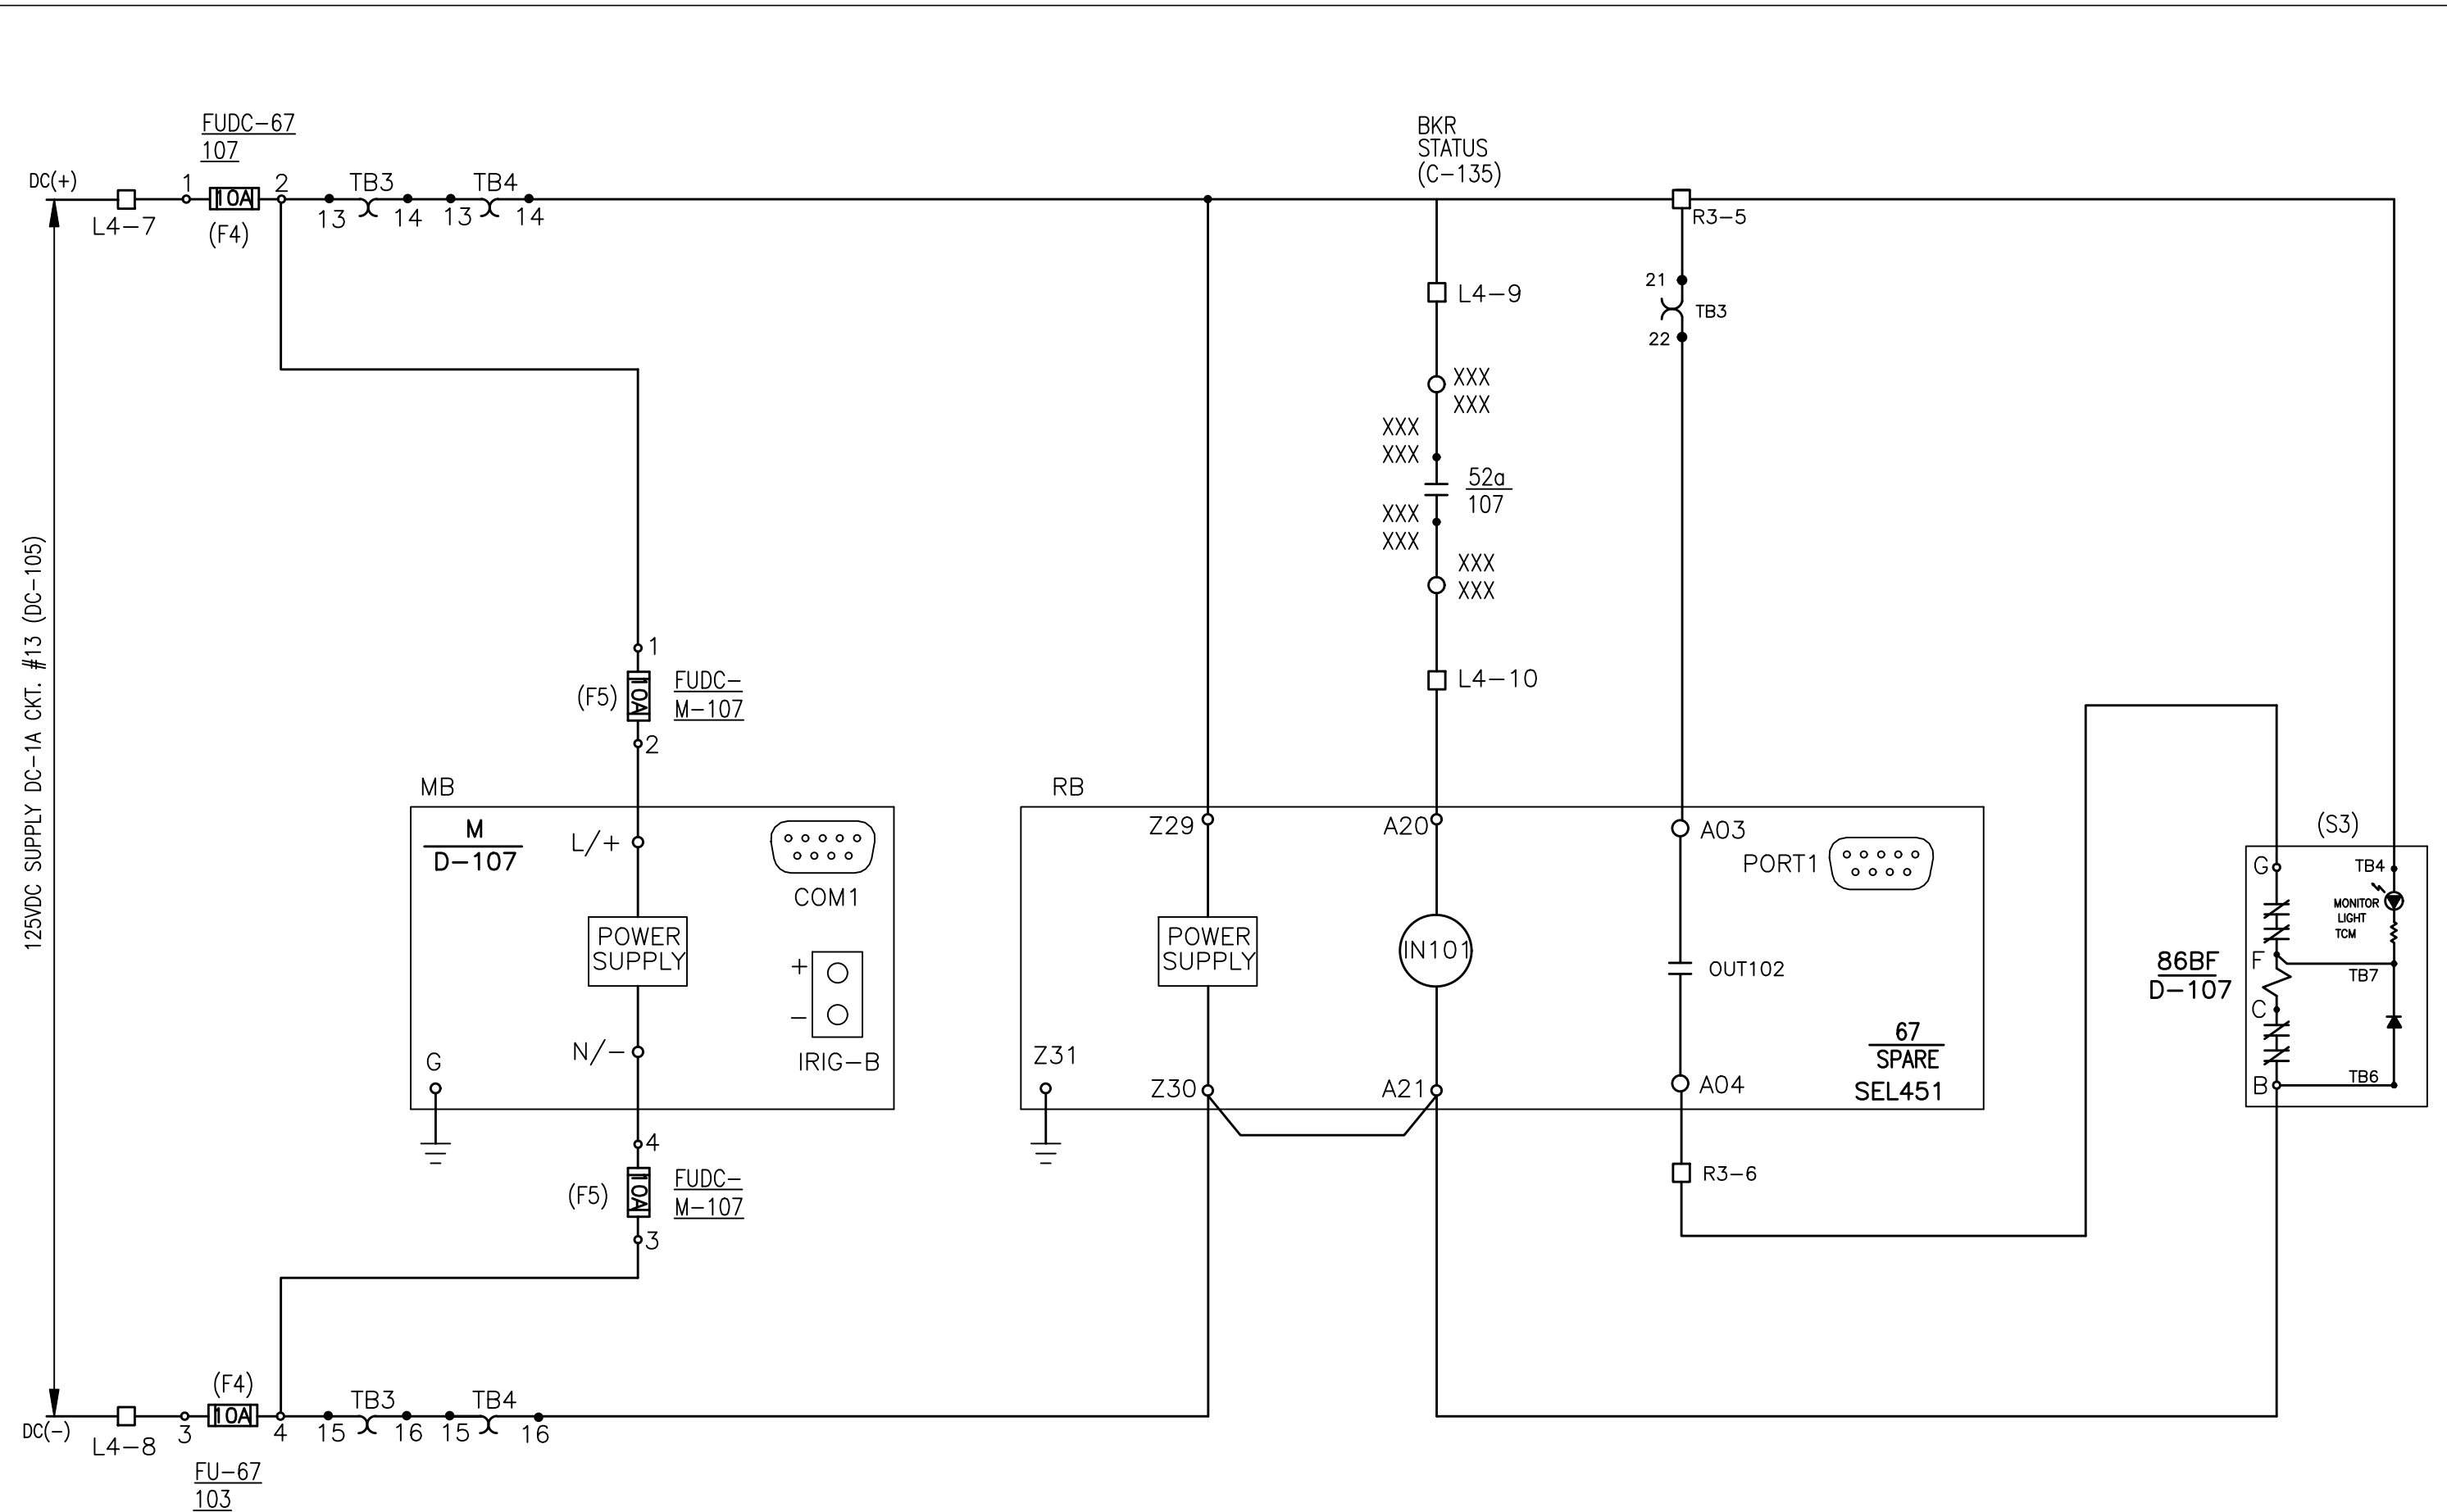

DC ELEMENTARY DIAGRAM  
SPARE

LEGEND

- 67 DIRECTIONAL OVERCURRENT RELAY
- TB1 TEST BLOCK & NUMBER
- BKR POWER CIRCUIT BREAKER
- LOCATED IN RELAY PANEL 6
- LOCATED AT 13.2KV GIS

REFERENCE DRAWINGS

- 34.5/13.2kV SUBSTATION ONE-LINE DIAGRAM
- RELAY PANEL 6 WIRING DIAGRAM
- DC ELEMENTARY DIAGRAM 13.2kV BUS DIFFERENTIAL PROTECTION
- DC ELEMENTARY DIAGRAM DPAC-2
- VENDOR BKR D-105 THREE LINE DIAGRAM
- VENDOR BKR D-107 THREE LINE DIAGRAM

- STD-18257-E-600
- STD-18257-E-711
- STD-18257-E-707
- STD-18257-E-708
- XXXXXXXXXXXX
- XXXXXXXXXXXX

5 Christy Drive, Suite 307  
Chadds Ford, PA 19317  
610.558.3464 office  
www.fxbinco.com

Engineering Excellence Since 1968

Seal:

Client:

Virgin Islands  
Water and Power  
Authority  
U.S. Virgin Islands


Project Name:

East End Substation  
Restoration &  
Expansion Project  
St. Thomas, USVI  
Phase 2 (13.2kV GIS)

Issue / Revisions:

#	Date	Description
A	07.25.19	Issue for Phase 2 Bid Review
O	10.17.19	Issue for Phase 2 Bid

Drawn By: PJB  
Checked By: PJB  
Date: 10.17.19  
Scale: As Noted  
Project Number: VIT 18257  
Drawing Title:  
DC ELEMENTARY  
DIAGRAM D-F7/SPARE  
FEEDER PROTECTION  
RELAYS  
13.2kV RP6  
Drawing Number:  
STD-18257-E-705  
Sheet Number 1 of 1  
©2019 FXB, Inc

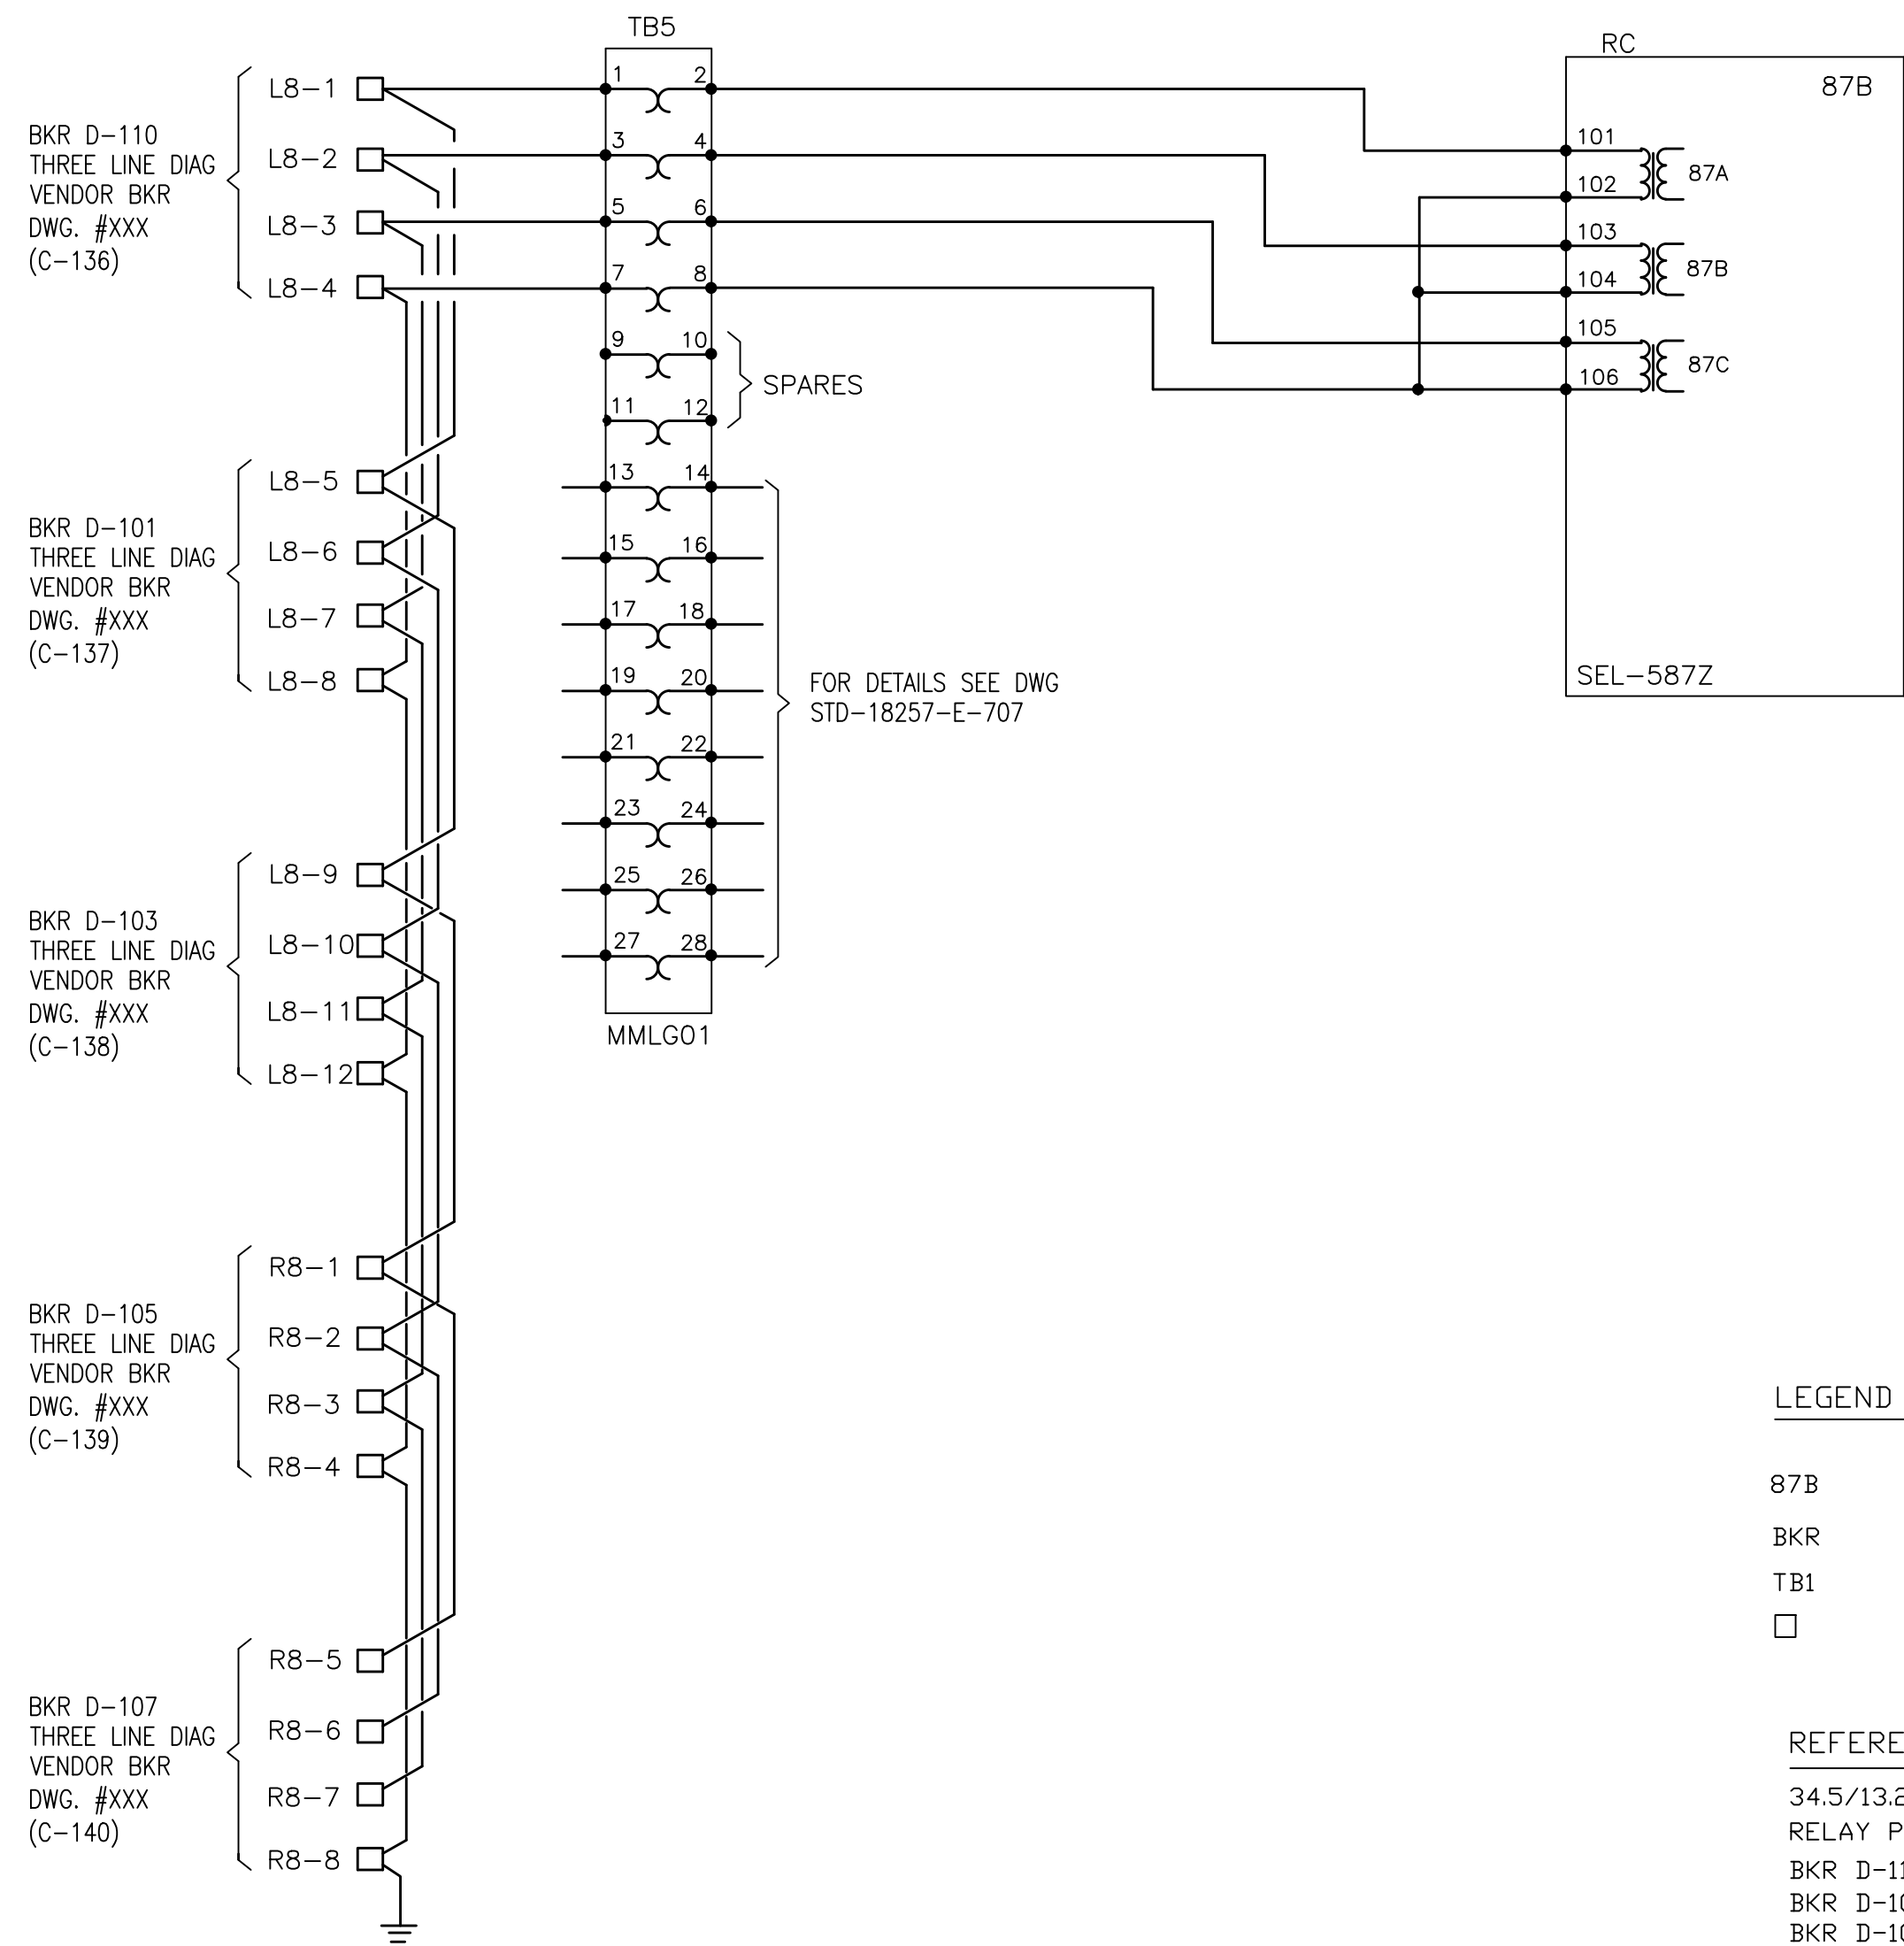

LEGEND

- 87B HIGH IMPEDEENCE BUS DIFFERENTIAL RELAY  
BKR POWER CIRCUIT BREAKER  
TB1 TEST BLOCK & NUMBER  
□ LOCATED IN RELAY PANEL 6


REFERENCE DRAWINGS

- 34.5/13.2KV SUBSTATION ONE-LINE DIAGRAM STD-18257-E-600  
RELAY PANEL 6 WIRING DIAGRAM STD-18257-E-711  
BKR D-110 THREE LINE DIAGRAM XXXXXXXXXXXX  
BKR D-101 THREE LINE DIAGRAM XXXXXXXXXXXX  
BKR D-103 THREE LINE DIAGRAM XXXXXXXXXXXX  
BKR D-105 THREE LINE DIAGRAM XXXXXXXXXXXX  
BKR D-107 THREE LINE DIAGRAM XXXXXXXXXXXX

AC ELEMENTARY DIAGRAM  
87B

Seal:

Client:

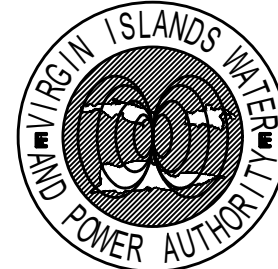

*Virgin Islands  
Water and Power  
Authority  
U.S. Virgin Islands*

Project Name:

East End Substation  
Restoration &  
Expansion Project  
St. Thomas, USVI  
Phase 2 (13.2kV GIS)

Issue / Revisions:

#	Date	Description
A	07.25.19	Issue for Phase 2 Bid Review
O	10.17.19	Issue for Phase 2 Bid




Drawn By: PJB  
Checked By: PJB  
Date: 10.17.19  
Scale: As Noted  
Project Number: VIT 18257

Drawing Title:  
**AC ELEMENTARY  
DIAGRAM 13.2KV BUS  
DIFFERENTIAL  
PROTECTION  
(87B) 13.2 KV RP6**

Drawing Number:

**STD-18257-E-706**



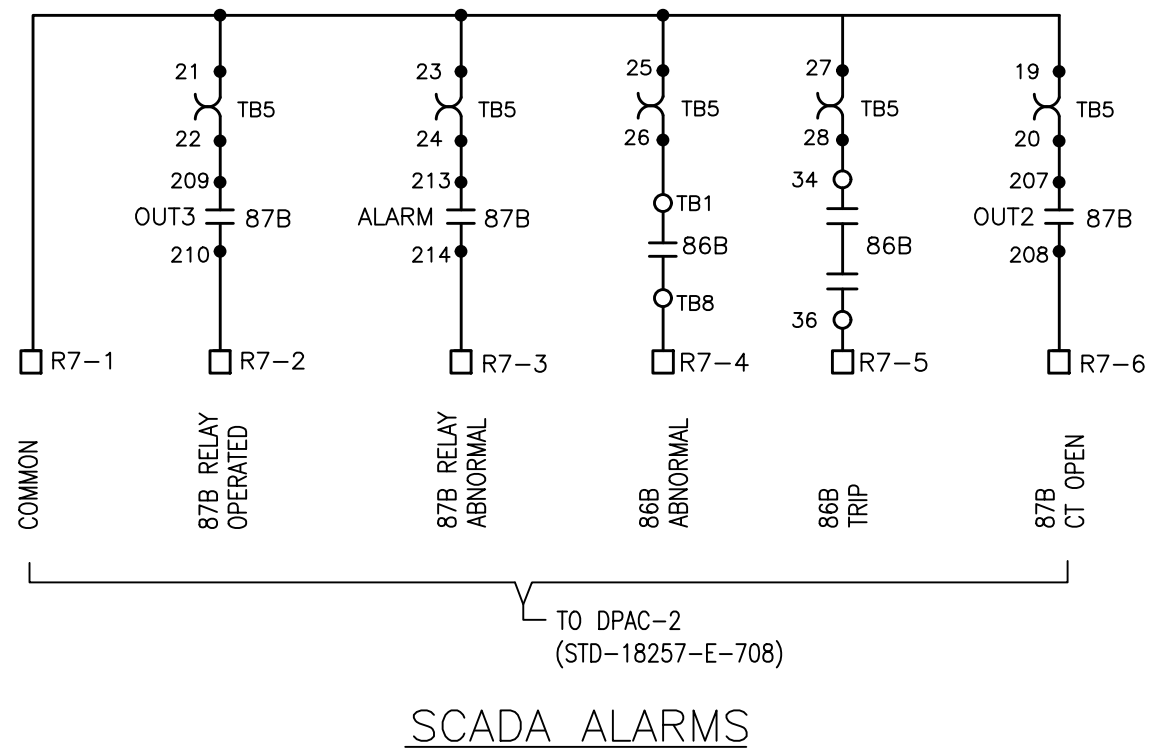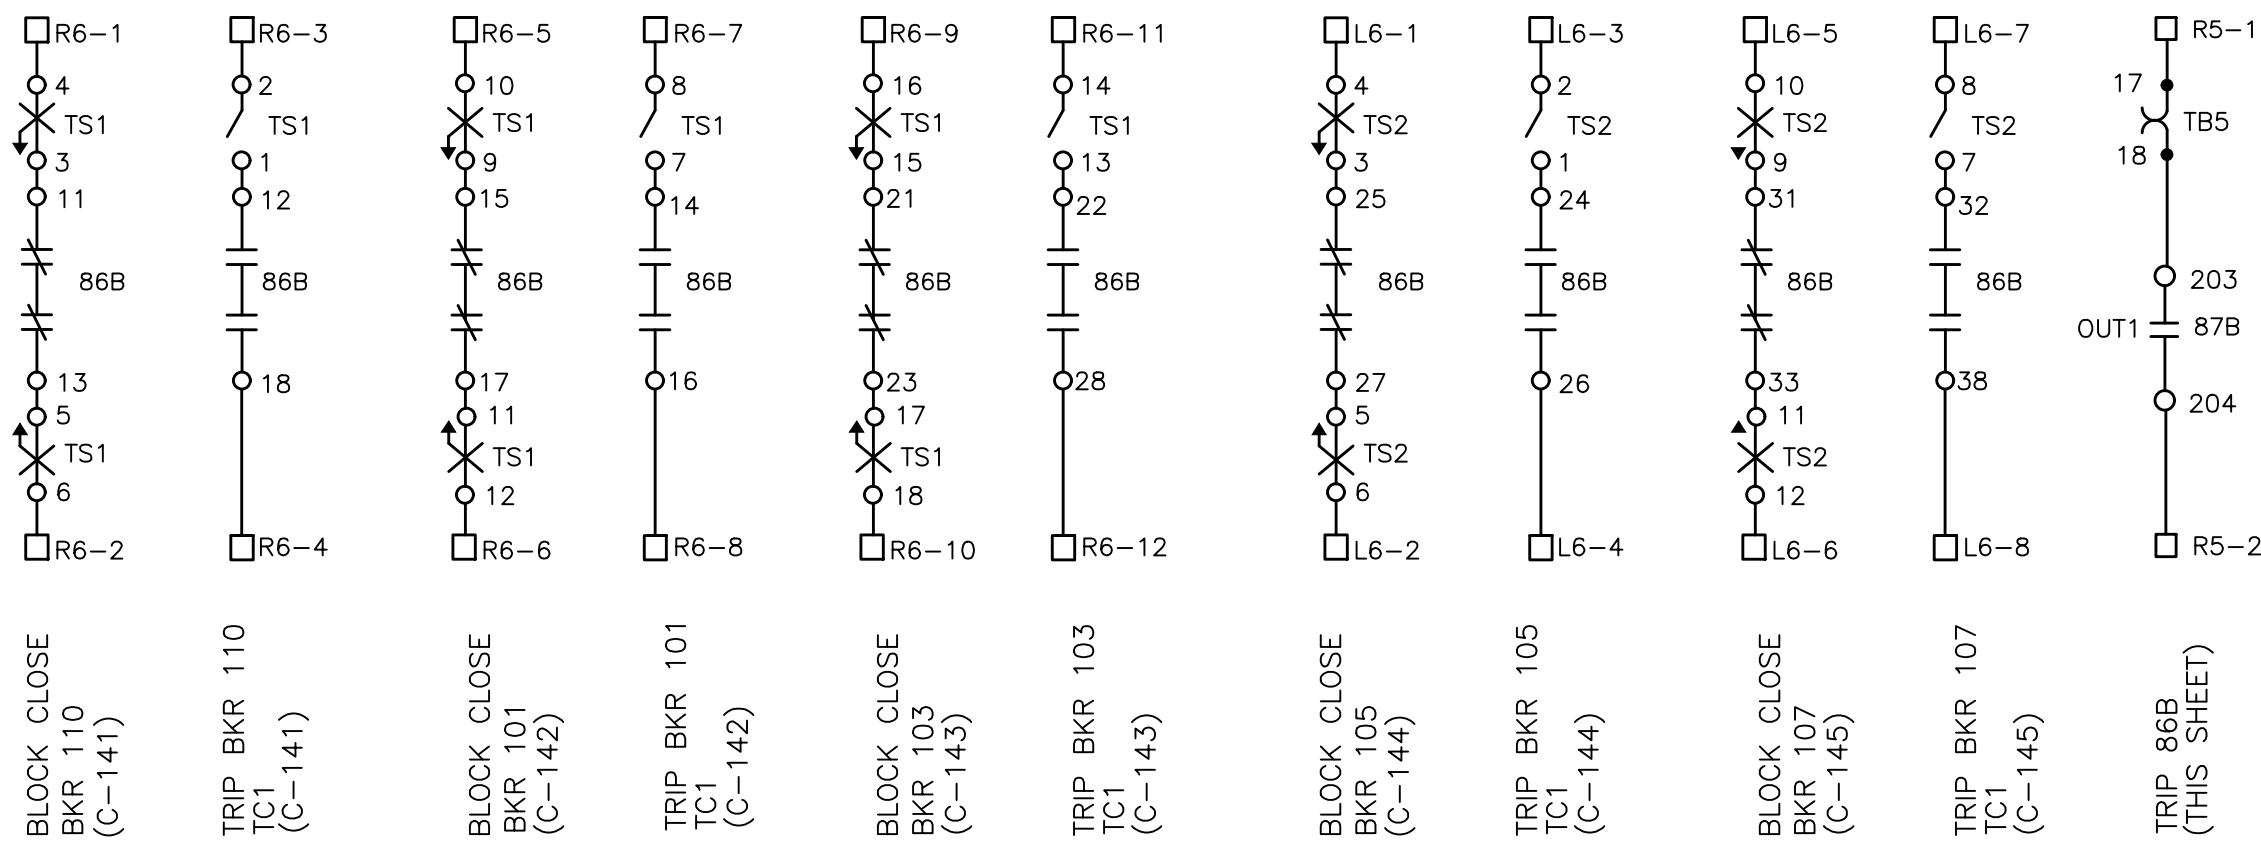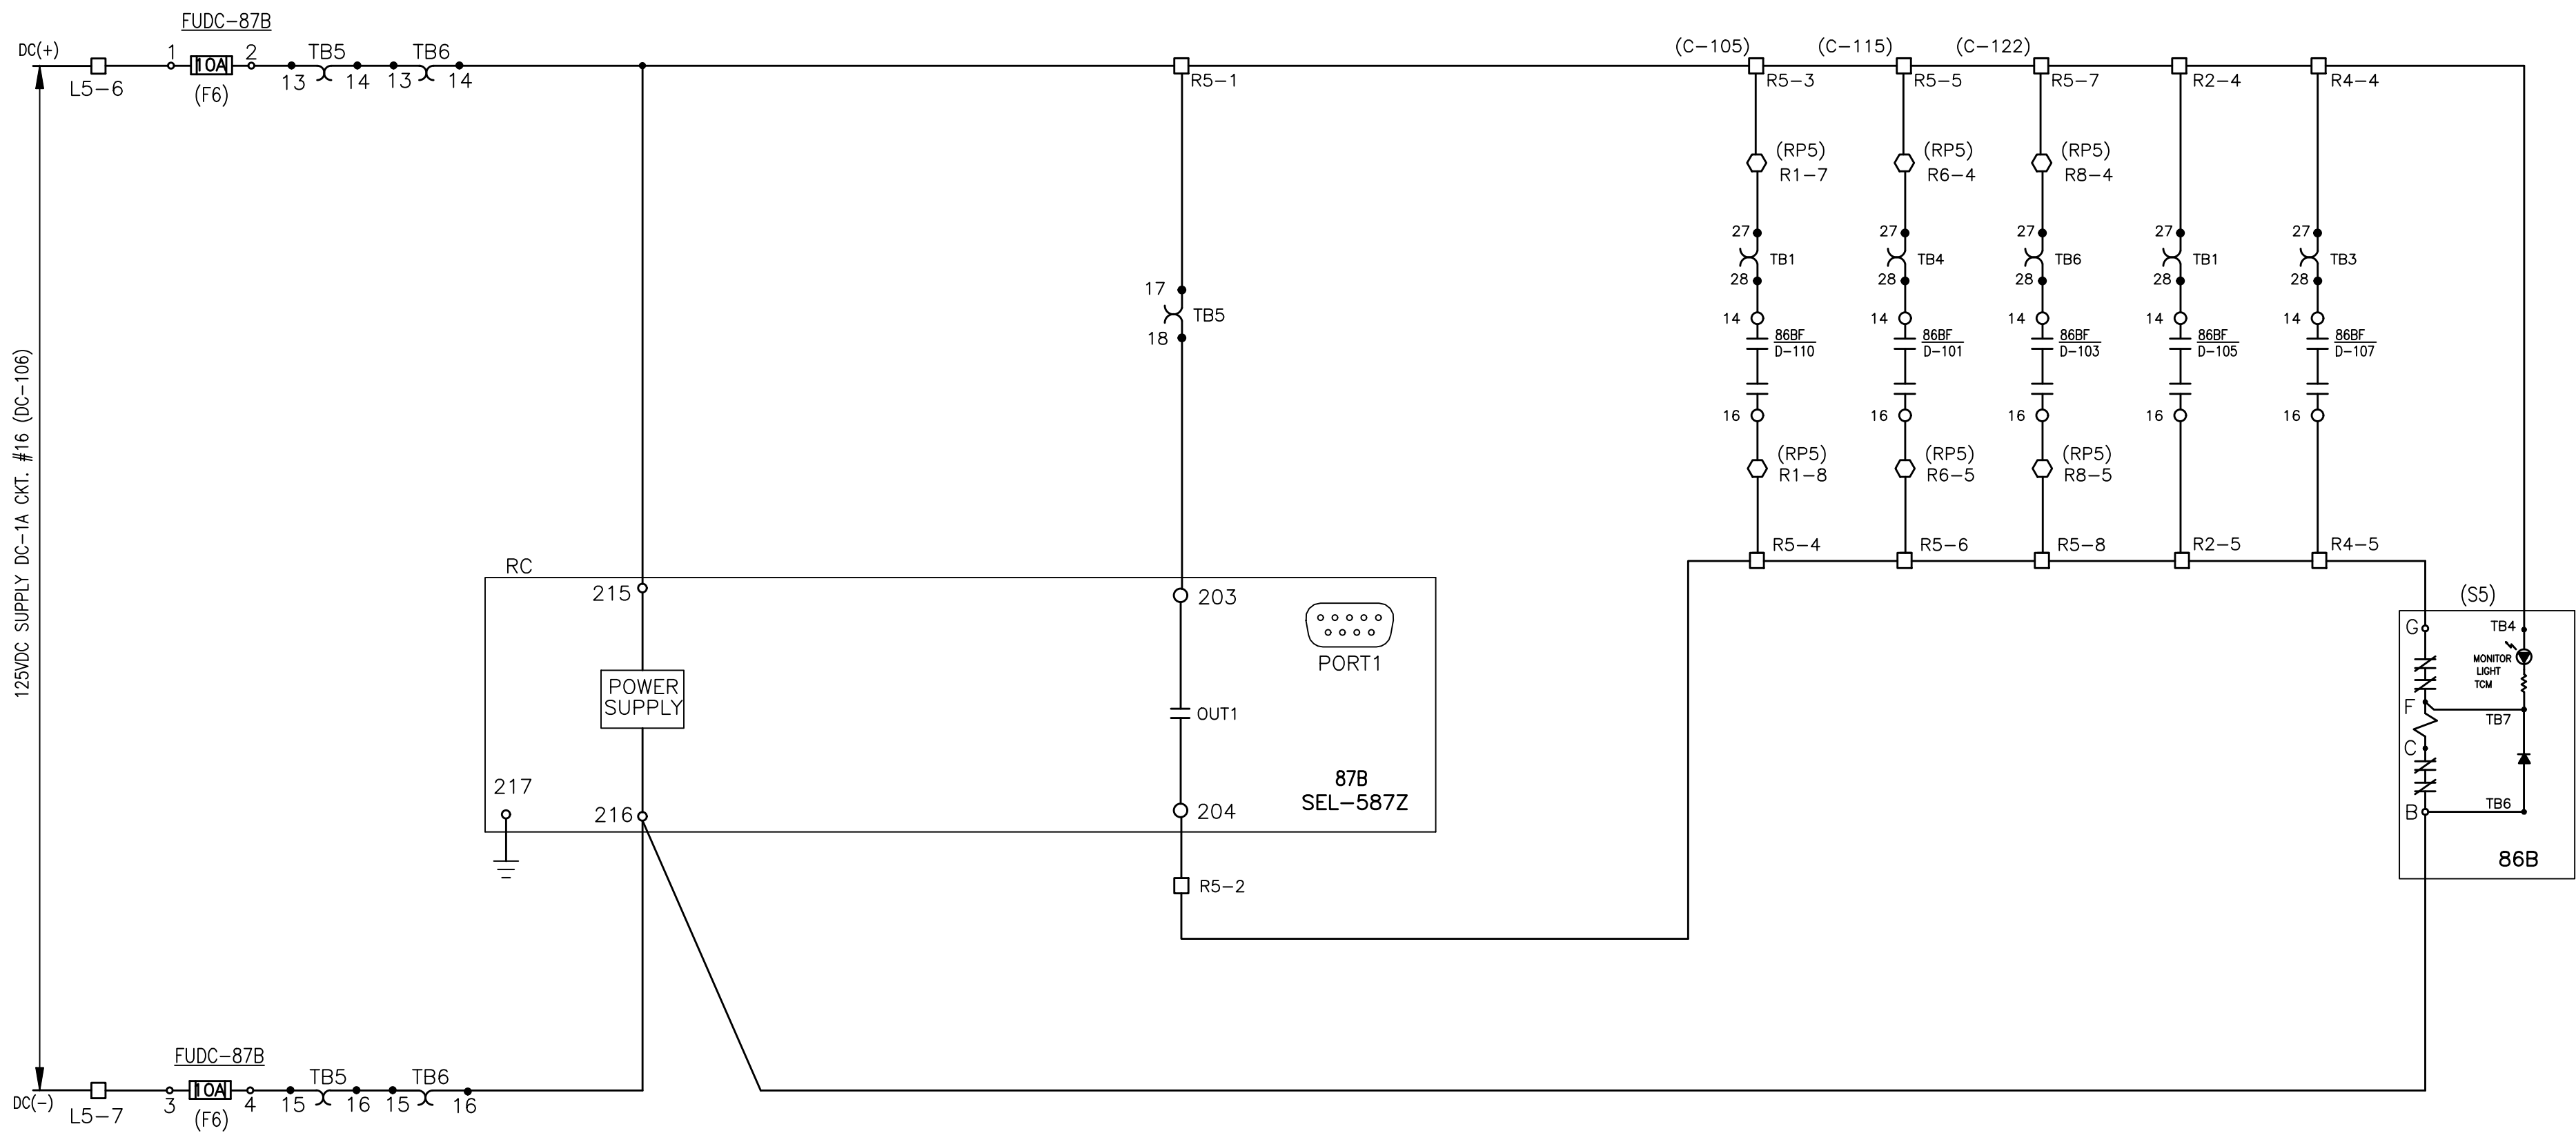


LEGEND

- 87B HIGH IMPEDANCE BUS DIFFERENTIAL RELAY  
86B BUS DIFFERENTIAL LOCKOUT  
TB1 TEST BLOCK & NUMBER  
TS1 TEST SWITCH & NUMBER  
BKR POWER CIRCUIT BREAKER  
□ LOCATED IN RELAY PANEL 6  
○ LOCATED IN RELAY PANE 5

REFERENCE DRAWINGS

- 34.5/13.2kV SUBSTATION ONE-LINE DIAGRAM  
RELAY PANEL 6 WIRING DIAGRAM  
DC ELEMENTARY DIAGRAM D-T1 LOW SIDE PROTECTION  
DC ELEMENTARY DIAGRAM D-FRR/D-F9 FEEDER PROTECTION  
DC ELEMENTARY DIAGRAM D-F7/SPARE FEEDER PROTECTION  
DC ELEMENTARY DIAGRAM DPAC-2  
DC ELEMENTARY DIAGRAM BKR D-110  
DC ELEMENTARY DIAGRAM BKR D-101  
DC ELEMENTARY DIAGRAM BKR D-103  
DC ELEMENTARY DIAGRAM BKR D-105  
DC ELEMENTARY DIAGRAM BKR D-107

- STD-18257-E-600  
STD-18257-E-711  
STD-18257-E-701  
STD-18257-E-703  
STD-18257-E-705  
STD-18257-E-708  
XXX  
XXX  
XXX  
XXX  
XXX

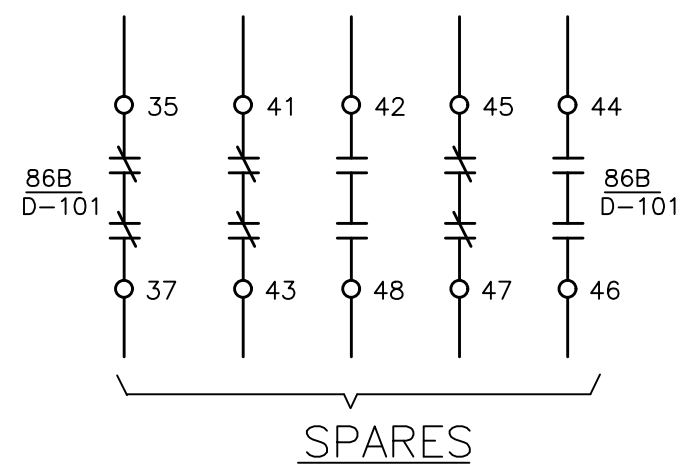

DC ELEMENTARY DIAGRAM  
87B




5 Christy Drive, Suite 307  
Chadds Ford, PA 19317  
610.558.3464 office  
www.fxbinco.com

Engineering Excellence Since 1968

Seal:

Client:

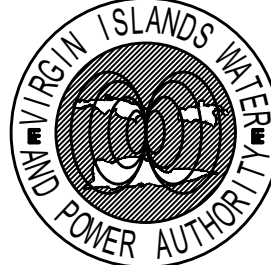

Virgin Islands  
Water and Power  
Authority  
U.S. Virgin Islands

Project Name:

East End Substation  
Restoration &  
Expansion Project  
St. Thomas, USVI  
Phase 2 (13.2kV GIS)

Issue / Revisions:

#	Date	Description
A	07.25.19	Issue for Phase 2 Bid Review
O	10.17.19	Issue for Phase 2 Bid


Drawn By:	PJB
Checked By:	PJB
Date:	10.17.19
Scale:	As Noted
Project Number:	VIT 18257

Drawing Title:  
**DC ELEMENTARY  
DIAGRAM  
13.2KV BUS DIFFERENTIAL  
PROTECTION  
(87B) 13.2KV RP6**

Drawing Number:

STD-18257-E-707

Sheet Number 1 of 1  
©2019 FXB, Inc

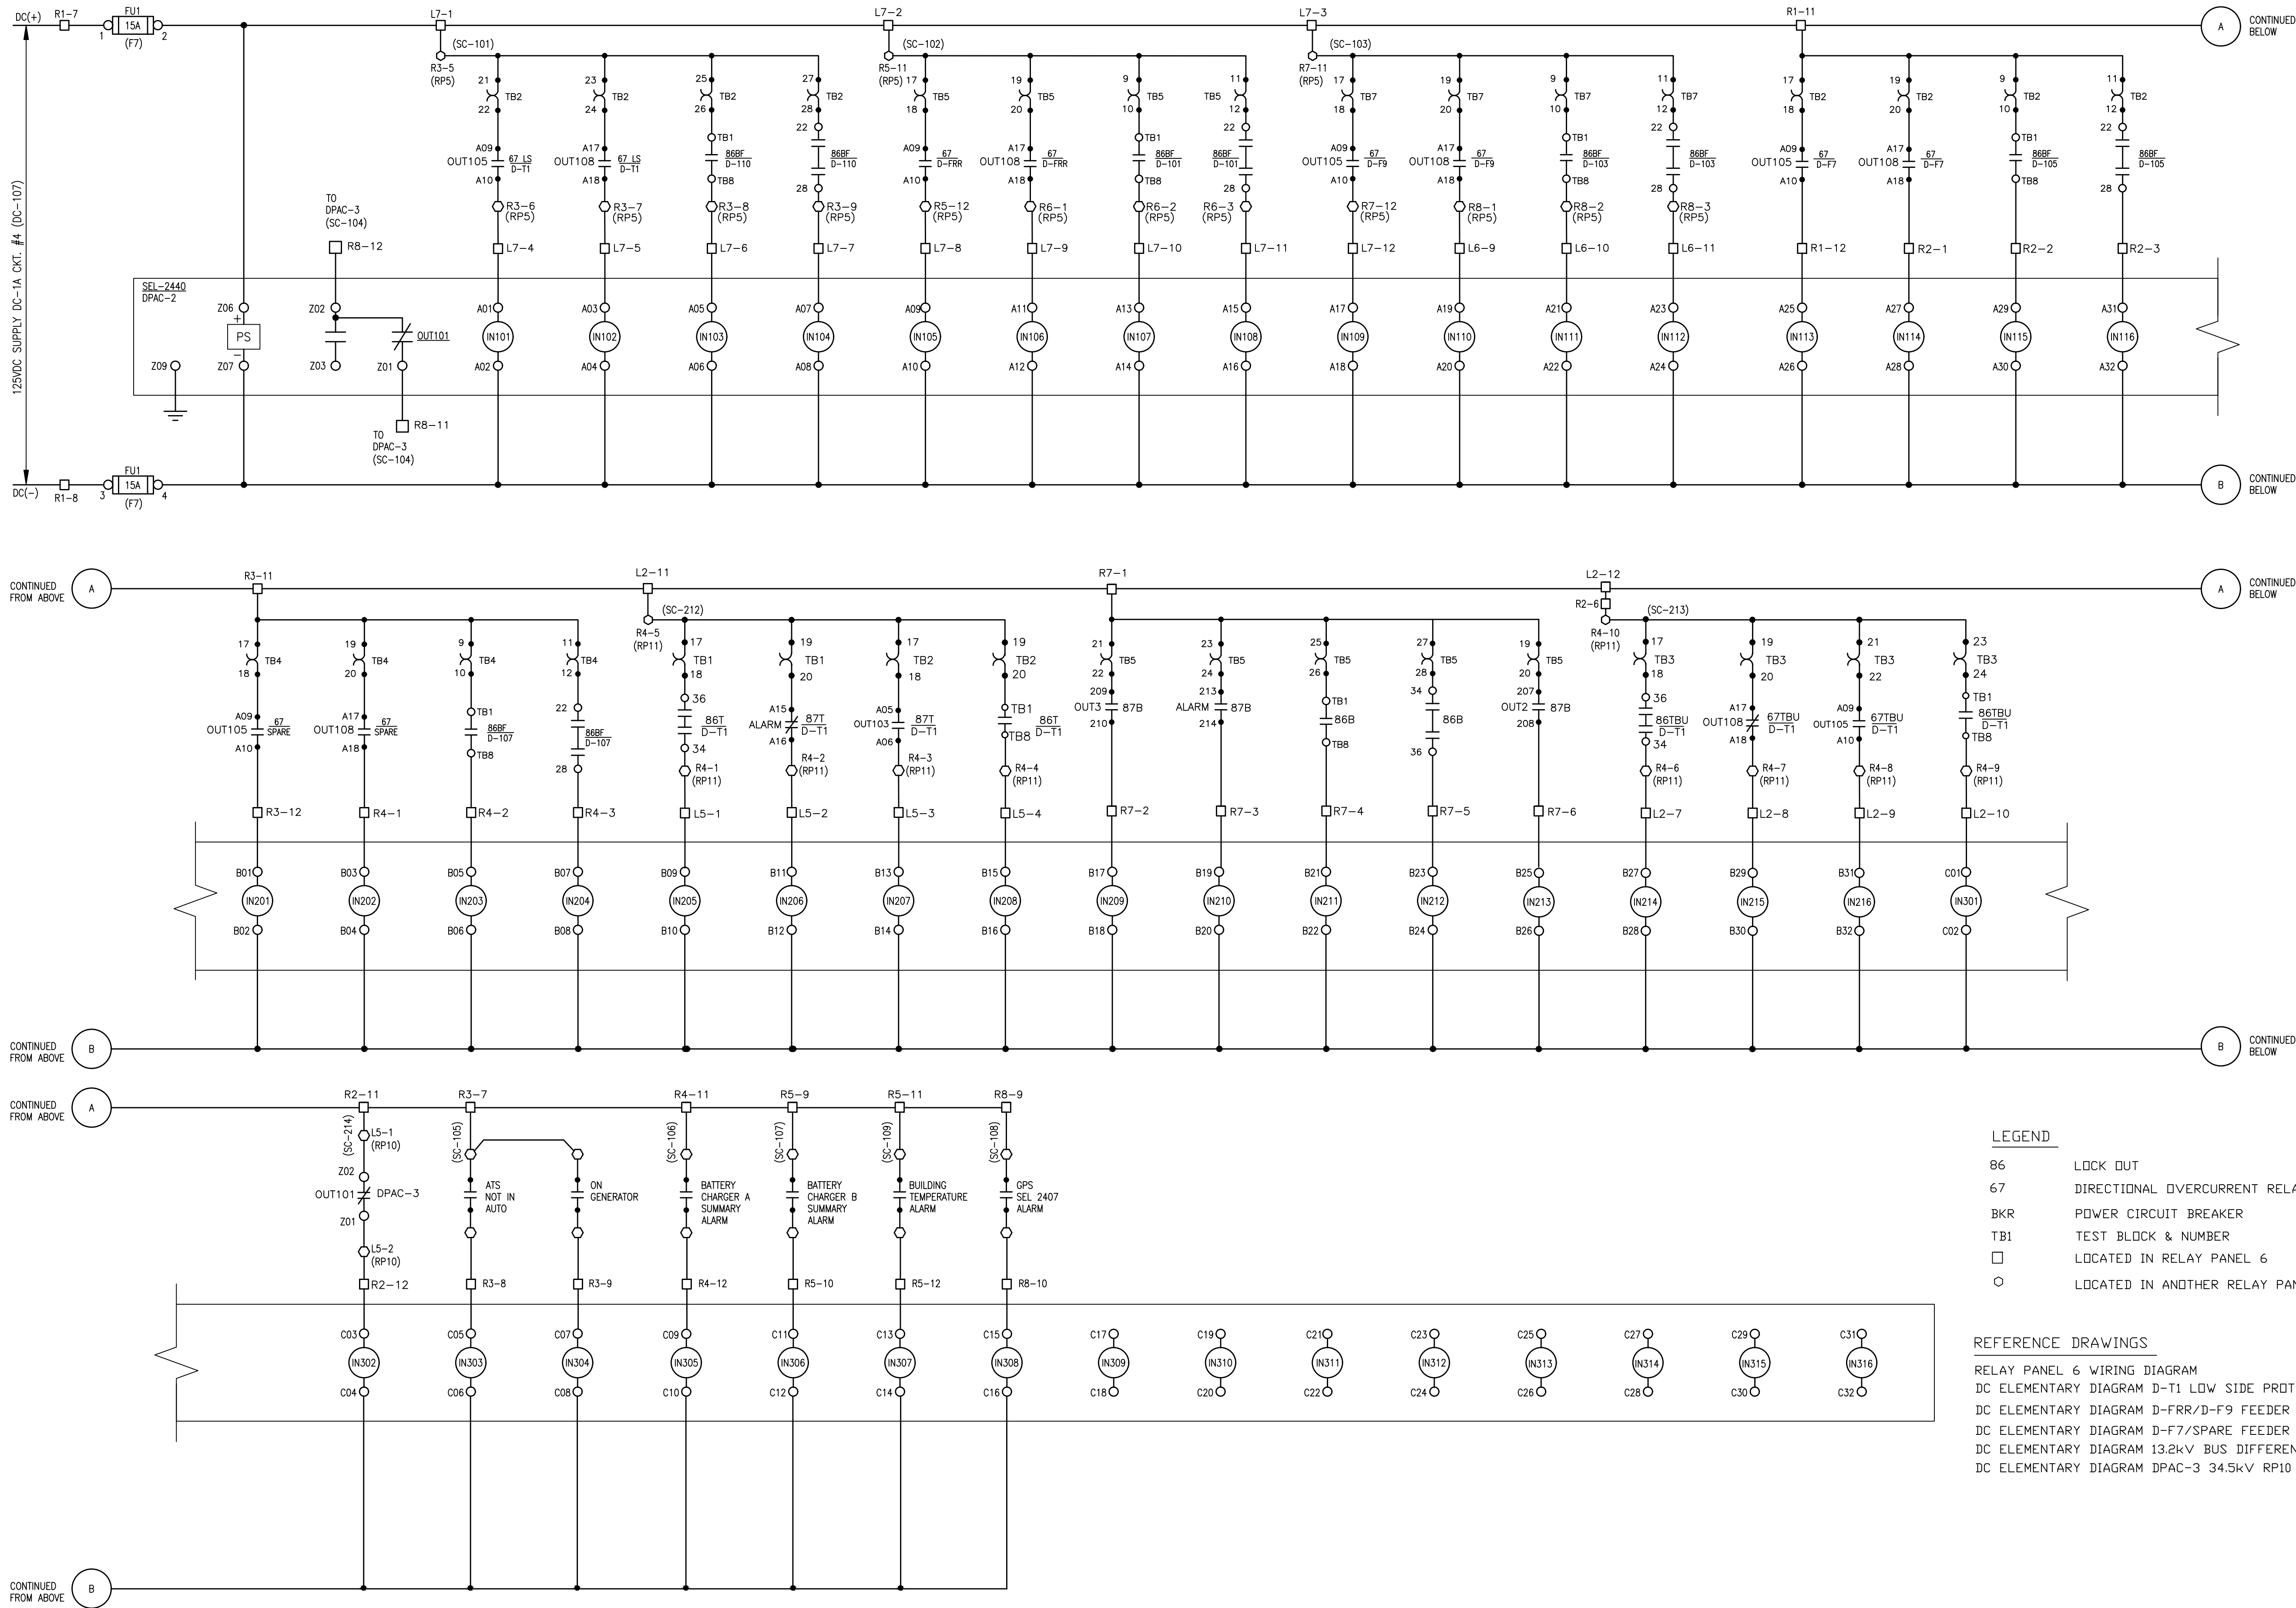


DC ELEMENTARY DIAGRAM  
DPAC-2



5 Christy Drive, Suite 307  
Chadds Ford, PA 19317  
610.558.3464 office  
www.fxbinco.com  
Engineering Excellence Since 1968

Seal:

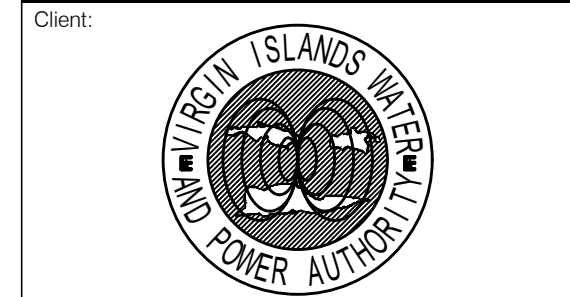

Virgin Islands  
Water and Power  
Authority  
U.S. Virgin Islands

Project Name:

East End Substation  
Restoration &  
Expansion Project  
St. Thomas, USVI  
Phase 2 (13.2kV GIS)

Issue / Revisions:		
#	Date	Description
A	07.25.19	Issue for Phase 2 Bid Review
O	10.17.19	Issue for Phase 2 Bid

Drawn By:	PJB
Checked By:	PJB
Date:	10.17.19
Scale:	As Noted
Project Number:	VIT 18257
Drawing Title:	


DC ELEMENTARY  
DIAGRAM  
DPAC-2  
13.2kV RP6

Drawing Number:

STD-18257-E-708

Sheet Number 1 of 1  
©2019 FXB, Inc



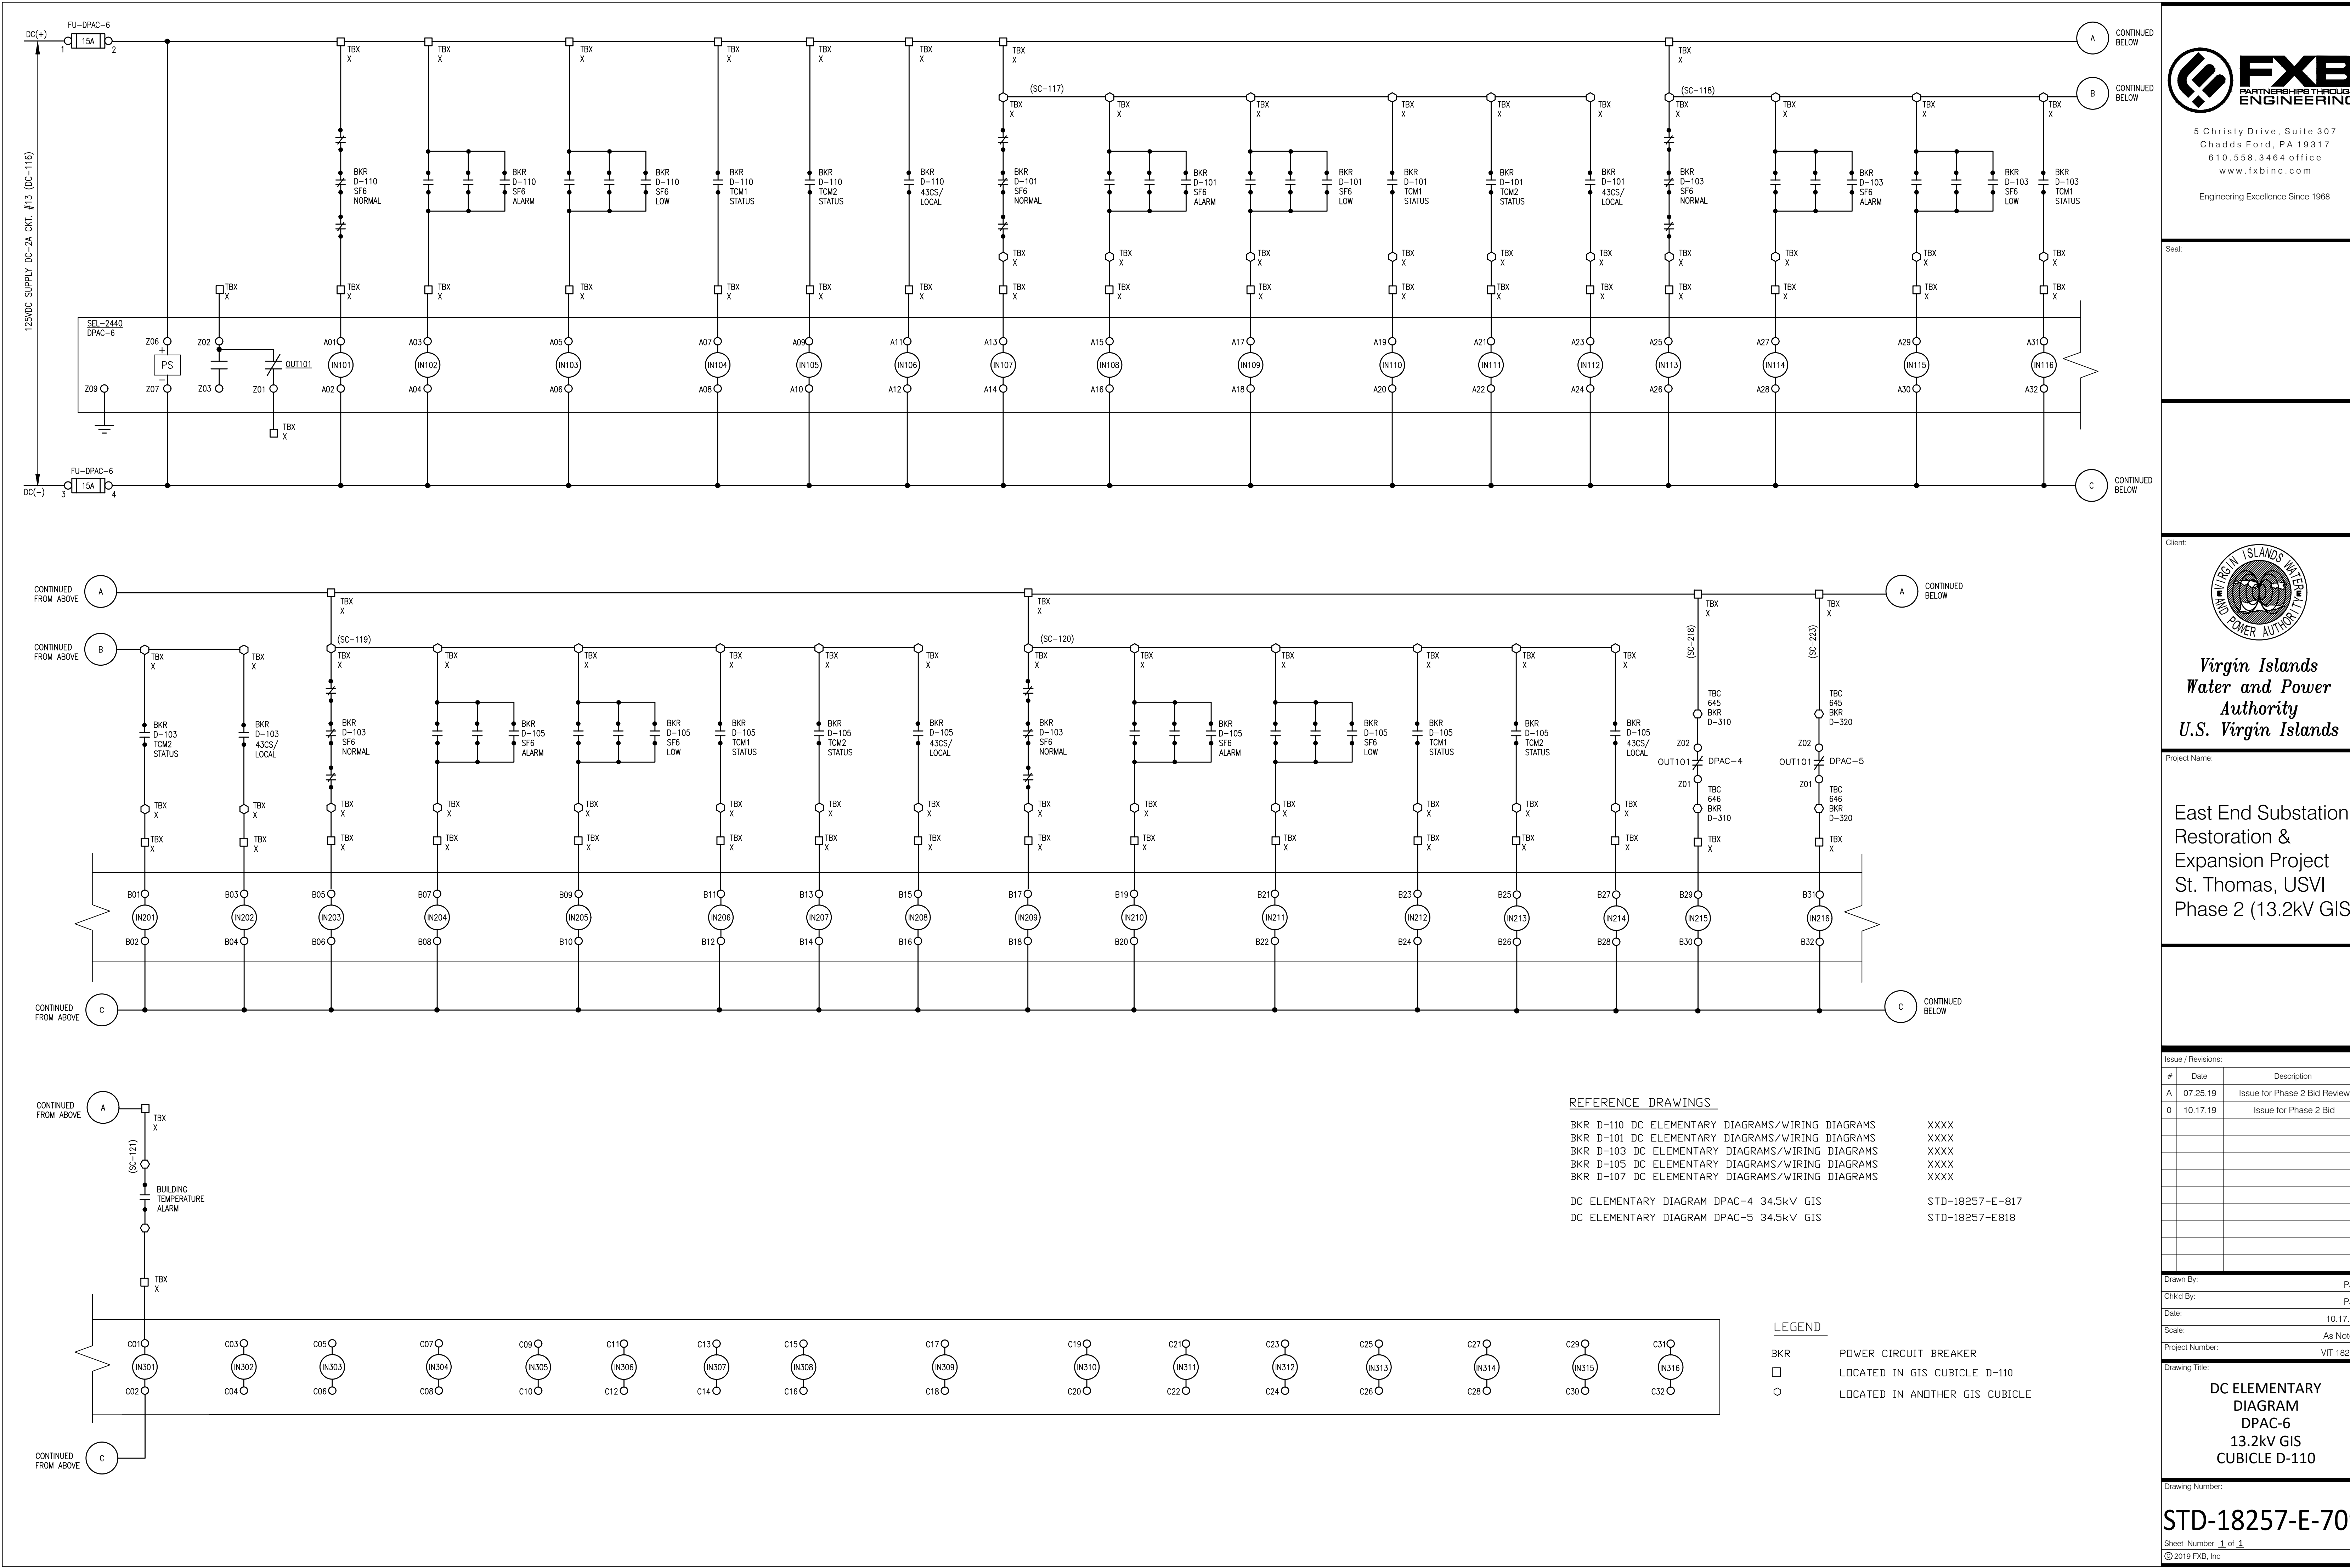

Seal:

Project Name:

East End Substation  
Restoration &  
Expansion Project  
St. Thomas, USVI  
Phase 2 (13.2kV GIS)

Issue / Revisions:		
#	Date	Description
A	07.25.19	Issue for Phase 2 Bid Review
O	10.17.19	Issue for Phase 2 Bid

Drawn By: PJB  
Checked By: PJB  
Date: 10.17.19  
Scale: As Noted  
Project Number: VIT 18257

DC ELEMENTARY  
DIAGRAM  
DPAC-6  
13.2kV GIS  
CUBICLE D-110





E-711

Sheet Number      of     

© 2019 FXB, Inc